



**DRAWING LIST**

SHEET NO.	DWG. NO.	DRAWING DESCRIPTION	SHEET NO.	DWG. NO.	DRAWING DESCRIPTION
1.	CV	COVER SHEET	58.	FM2-3	SANITARY SEWER PLAN & PROFILE - LYTLE FORCE MAIN
2.	GN-1	NOTES, LEGEND AND UTILITY LIST	59.	FM2-4	SANITARY SEWER PLAN & PROFILE - LYTLE FORCE MAIN
3.	GN-2	HOP, MAINTENANCE AND PROTECTION OF TRAFFIC, DRIVEWAY AND LOCAL ROADS NOTES	60.	FM2-5	SANITARY SEWER PLAN & PROFILE - LYTLE FORCE MAIN
4.	GN-3	PAVEMENT HISTORY	61.	FM2-6	SANITARY SEWER PLAN & PROFILE - LYTLE FORCE MAIN
5.	IN	SANITARY SEWER INDEX MAP & DRAWING LIST	62.	FM2-7	SANITARY SEWER PLAN & PROFILE - LYTLE FORCE MAIN
6.	DT-1	WATER MAIN CONSTRUCTION DETAILS	63.	FM2-8	SANITARY SEWER PLAN & PROFILE - LYTLE FORCE MAIN
7.	DT-2	WATER MAIN CONSTRUCTION DETAIL	64.	FM2-9	SANITARY SEWER PLAN & PROFILE - LYTLE FORCE MAIN
8.	DT-3	SANITARY SEWER CONSTRUCTION DETAILS	65.	FM2-10	SANITARY SEWER PLAN & PROFILE - LYTLE FORCE MAIN
9.	DT-4	SANITARY SEWER CONSTRUCTION DETAILS	66.	FM2-11	SANITARY SEWER PLAN & PROFILE - LYTLE FORCE MAIN
10.	DT-5	SANITARY SEWER CONSTRUCTION DETAILS	67.	FM2-12	SANITARY SEWER PLAN & PROFILE - LYTLE FORCE MAIN
11.	DT-6	SANITARY SEWER CONSTRUCTION DETAILS	68.	FM2-13	SANITARY SEWER PLAN & PROFILE - LYTLE FORCE MAIN
12.	DT-7	SANITARY SEWER CONSTRUCTION DETAILS	69.	FM2-14	SANITARY SEWER PLAN & PROFILE - LYTLE FORCE MAIN
13.	DT-8	SANITARY SEWER CONSTRUCTION DETAILS	70.	FM3-1	SANITARY SEWER PLAN & PROFILE - HERTZLER FORCE MAIN
14.	DT-9	SANITARY SEWER CONSTRUCTION DETAILS	71.	FM3-2	SANITARY SEWER PLAN & PROFILE - HERTZLER FORCE MAIN
15.	DT-10	GENERAL CONSTRUCTION DETAILS	72.	FM3-3	SANITARY SEWER PLAN & PROFILE - HERTZLER FORCE MAIN
16.	DT-11	GENERAL CONSTRUCTION DETAILS	73.	FM3-4	SANITARY SEWER PLAN & PROFILE - HERTZLER FORCE MAIN
17.	DT-12	GENERAL CONSTRUCTION DETAILS	74.	FM3-5	SANITARY SEWER PLAN & PROFILE - HERTZLER FORCE MAIN
18.	WAT-1	WATER MAIN PLAN & PROFILE	75.	L-1	LYTLE - EXISTING CONDITION AND DEMOLITION SITE PLAN
19.	WAT-2	WATER MAIN PLAN & PROFILE	76.	L-2	LYTLE - PROPOSED SITE GRADING AND SURFACING PLAN
20.	WAT-3	WATER MAIN PLAN & PROFILE	77.	L-3	LYTLE - PROPOSED SITE PLAN
21.	WAT-4	WATER MAIN PLAN & PROFILE	78.	L-4	LYTLE - EROSION AND SEDIMENT POLLUTION CONTROL PLAN
22.	WAT-5	WATER MAIN PLAN & PROFILE	79.	L-5	LYTLE - PUMP STATION PLAN
23.	WAT-6	WATER MAIN PLAN & PROFILE	80.	L-6	LYTLE - PUMP STATION CROSS SECTIONS
24.	WAT-7	WATER MAIN PLAN & PROFILE	81.	D-1	DEODATE - EXISTING CONDITION AND DEMOLITION SITE PLAN
25.	WAT-8	WATER MAIN PLAN & PROFILE	82.	D-2	DEODATE - PROPOSED SITE GRADING AND SURFACING PLAN
26.	WAT-9	WATER MAIN PLAN & PROFILE	83.	D-3	DEODATE - PROPOSED SITE PLAN
27.	WAT-10	WATER MAIN PLAN & PROFILE	84.	D-4	DEODATE - EROSION AND SEDIMENT POLLUTION CONTROL PLAN
28.	WAT-11	WATER MAIN PLAN & PROFILE	85.	D-5	DEODATE - PUMP STATION PLAN
29.	WAT-12	WATER MAIN PLAN & PROFILE	86.	D-6	DEODATE - PUMP STATION CROSS SECTIONS
30.	WAT-13	WATER MAIN PLAN & PROFILE	87.	H-1	HERTZLER - EXISTING CONDITION AND DEMOLITION SITE PLAN
31.	G1-1	SANITARY SEWER PLAN & PROFILE - LYTLE PUMP STATION	88.	H-2	HERTZLER - PROPOSED SITE GRADING AND SURFACING PLAN
32.	G1-2	SANITARY SEWER PLAN & PROFILE - LYTLE PUMP STATION	89.	H-3	HERTZLER - PROPOSED SITE PLAN
33.	G1-3	SANITARY SEWER PLAN & PROFILE - LYTLE PUMP STATION	90.	H-4	HERTZLER - EROSION AND SEDIMENT POLLUTION CONTROL PLAN
34.	G1-4	SANITARY SEWER PLAN & PROFILE - LYTLE PUMP STATION	91.	H-5	HERTZLER - PUMP STATION PLAN AND CROSS SECTION
35.	G1-5	SANITARY SEWER PLAN & PROFILE - LYTLE PUMP STATION	92.	A-01	ARCHITECTURAL GENERAL - PROJECT GENERAL NOTES, SYMBOLS, & ABBREVS
36.	G1-6	SANITARY SEWER PLAN & PROFILE - LYTLE PUMP STATION	93.	A-02	ARCHITECTURAL GENERAL - TYPICAL ADA DETAILS & ASSEMBLIES
37.	G1-7	SANITARY SEWER PLAN & PROFILE - LYTLE PUMP STATION	94.	A-03	INFLUENT PUMP STATION - LIFE SAFETY PLAN AND CODE ANALYSIS
38.	G1-8	SANITARY SEWER PLAN & PROFILE - LYTLE PUMP STATION	95.	A-04	INFLUENT PUMP STATION - PROPOSED PLAN
39.	G2-1	SANITARY SEWER PLAN & PROFILE - DEODATE PUMP STATION	96.	A-05	INFLUENT PUMP STATION - PROPOSED ROOF PLAN & RCP
40.	G2-1.1	SANITARY SEWER PLAN & PROFILE - DEODATE PUMP STATION	97.	A-06	INFLUENT PUMP STATION - EXTERIOR ELEVATIONS
41.	G2-2	SANITARY SEWER PLAN & PROFILE - DEODATE PUMP STATION	98.	A-07	INFLUENT PUMP STATION - BUILDING SECTIONS & MISC. DETAILS
42.	G2-3	SANITARY SEWER PLAN & PROFILE - DEODATE PUMP STATION	99.	A-08	INFLUENT PUMP STATION - WALL SECTIONS & DETAILS
43.	G2-4	SANITARY SEWER PLAN & PROFILE - DEODATE PUMP STATION	100.	A-09	INFLUENT PUMP STATION - WALL SECTIONS & DETAILS
44.	G2-5	SANITARY SEWER PLAN & PROFILE - DEODATE PUMP STATION	101.	A-10	INFLUENT PUMP STATION - SCHEDULES & DETAILS
45.	G2-6	SANITARY SEWER PLAN & PROFILE - DEODATE PUMP STATION	102.	005-01	CODE INFORMATION SHEET - STRUCTURAL
46.	G3-1	SANITARY SEWER PLAN & PROFILE - DEODATE PUMP STATION	103.	005-02	PUMP STATION DETAILS - STRUCTURAL
47.	G3-2	SANITARY SEWER PLAN & PROFILE - LATERALS 4189 & 4197	104.	005-03	PUMP STATION DETAILS - STRUCTURAL
48.	G3-3	SANITARY SEWER PLAN & PROFILE - HERTZLER PUMP STATION	105.	005-04	PUMP STATION DETAILS - STRUCTURAL
49.	FM1-1	SANITARY SEWER PLAN & PROFILE - DEODATE FORCE MAIN	106.	005-05	PUMP STATION TYPICAL SECTIONS AND DETAILS - STRUCTURAL
50.	FM1-2	SANITARY SEWER PLAN & PROFILE - DEODATE FORCE MAIN	107.	PL-01	PUMP STATION FLOOR PLANS - STRUCTURAL
51.	FM1-3	SANITARY SEWER PLAN & PROFILE - DEODATE FORCE MAIN	108.	H-1	DEODATE PUMP STATION - HVAC PLAN
52.	FM1-4	SANITARY SEWER PLAN & PROFILE - DEODATE FORCE MAIN	109.	H-2	DEODATE PUMP STATION - HVAC SCHEDULES AND DETAILS
53.	FM1-5	SANITARY SEWER PLAN & PROFILE - DEODATE FORCE MAIN	110.	E-1	NOTES, ABBREVIATIONS AND SYMBOLS - ELECTRICAL
54.	FM1-6	SANITARY SEWER PLAN & PROFILE - DEODATE FORCE MAIN	111.	E-2	DEODATE PROPOSED SITE PLAN AND DETAILS - ELECTRICAL
55.	FM1-7	SANITARY SEWER PLAN & PROFILE - DEODATE FORCE MAIN	112.	E-3	DEODATE - POWER - PUMP STATION PLAN AND DETAILS - ELECTRICAL
56.	FM2-1	SANITARY SEWER PLAN & PROFILE - LYTLE FORCE MAIN	113.	E-4	DEODATE - LIGHTING - PUMP STATION PLAN AND DETAILS - ELECTRICAL DIAGRAM
57.	FM2-2	SANITARY SEWER PLAN & PROFILE - LYTLE FORCE MAIN	114.	E-5	DEODATE - POWER ONE-LINE DIAGRAM - ELECTRICAL
			115.	E-6	DEODATE - SCHEDULES, ELEMENTARY AND DIAGRAMS - ELECTRICAL
			116.	E-7	DEODATE - DIAGRAMS, ELEMENTARIES AND SCHEMATIC - ELECTRICAL
			117.	E-8	LYTLE - PROPOSED SITE PLANS AND DETAILS - ELECTRICAL
			118.	E-9	LYTLE - PUMP STATION PLAN AND DETAILS - ELECTRICAL
			119.	E-10	LYTLE - POWER ONE-LINE DIAGRAM AND SCHEDULE - ELECTRICAL
			120.	E-11	LYTLE - DIAGRAMS, ELEMENTARIES AND SCHEMATIC - ELECTRICAL
			121.	E-12	HERTZLER - PROPOSED SITE PLAN AND DETAILS - ELECTRICAL
			122.	E-13	HERTZLER - PUMP STATION PLAN AND DETAILS - ELECTRICAL
			123.	E-14	HERTZLER - POWER ONE-LINE DIAGRAM - ELECTRICAL
			124.	E-15	HERTZLER - DIAGRAMS, ELEMENTARIES AND SCHEMATIC - ELECTRICAL
			125.	E-16	GENERAL DETAILS - ELECTRICAL

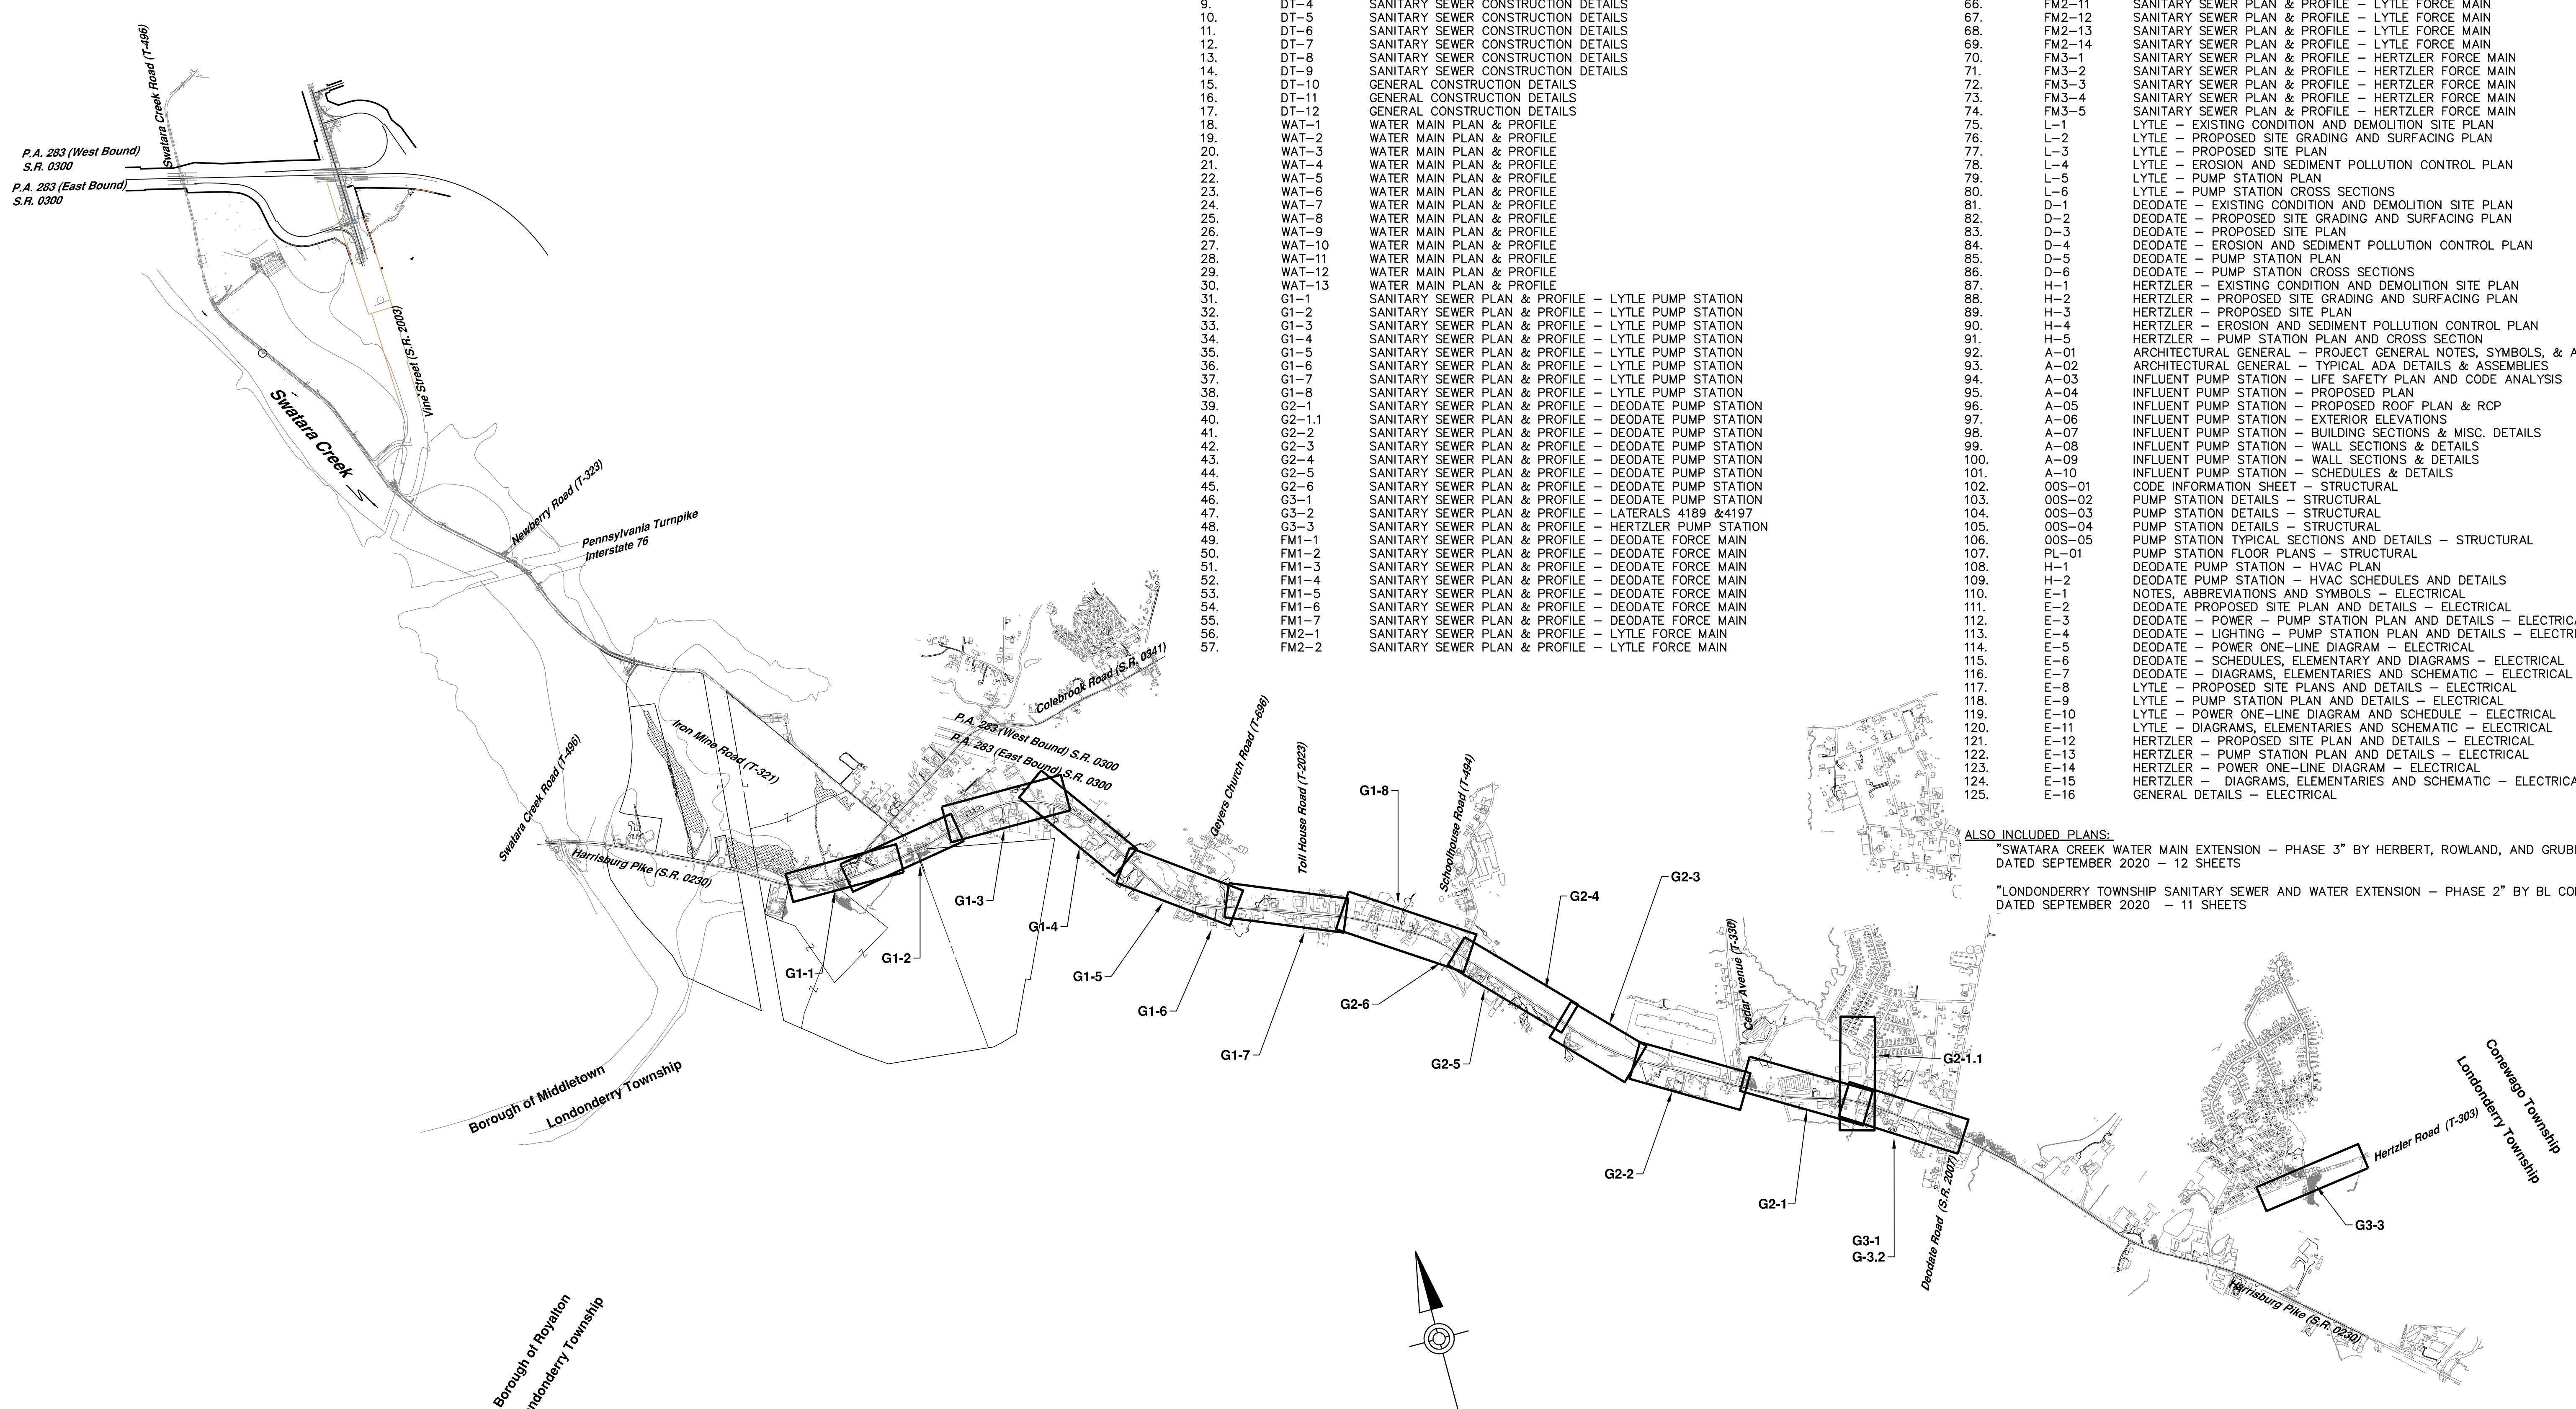


ALSO INCLUDED PLANS:  
 \*SWATARA CREEK WATER MAIN EXTENSION - PHASE 3" BY HERBERT, ROWLAND, AND GRUBIC INC., DATED SEPTEMBER 2020 - 12 SHEETS  
 \*LONDONDERRY TOWNSHIP SANITARY SEWER AND WATER EXTENSION - PHASE 2" BY BL COMPANIES, DATED SEPTEMBER 2020 - 11 SHEETS

**SANITARY SEWER INDEX MAP**  
 SCALE: 1" = 1000'

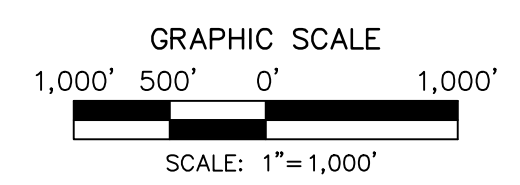

NO.	REVISION	DATE	BY

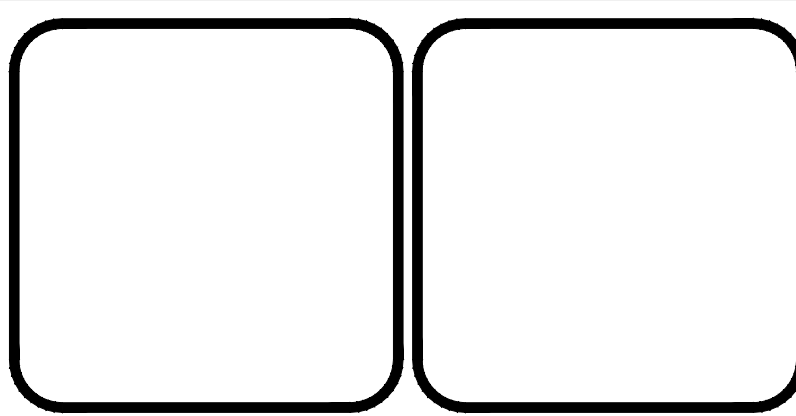


**HRG**  
 Herbert, Rowland & Grubic, Inc.  
 Engineering & Related Services  
 AN EMPLOYEE-OWNED COMPANY  
 369 East Park Drive  
 Harrisburg, PA 17111  
 (717) 564-1121  
 Fax (717) 564-1158  
 hrg@hrg-inc.com  
 www.hrg-inc.com

**CORE5 INDUSTRIAL PARTNERS**  
 1250 N. MOUNTAIN ROAD  
 HARRISBURG, PA 17112  
 (717) 461-7730


**SANITARY SEWER INDEX  
 MAP AND DRAWING LIST  
 FOR LONDONDERRY TOWNSHIP SANITARY  
 SEWER AND WATER EXTENSION PHASE I**  
 LONDONDERRY TOWNSHIP DAUPHIN COUNTY PENNSYLVANIA

PROJ. MGR. - JTF  
 DESIGN - HCK  
 CADD - KRB  
 CHECKED - MDC/SAH  
 SCALE - AS NOTED  
 DATE - SEPT. 2020


DRAWING NO.  
**IN**  
 SHEET NO.  
**5 OF 125**  
 PROJECT 008048.0428

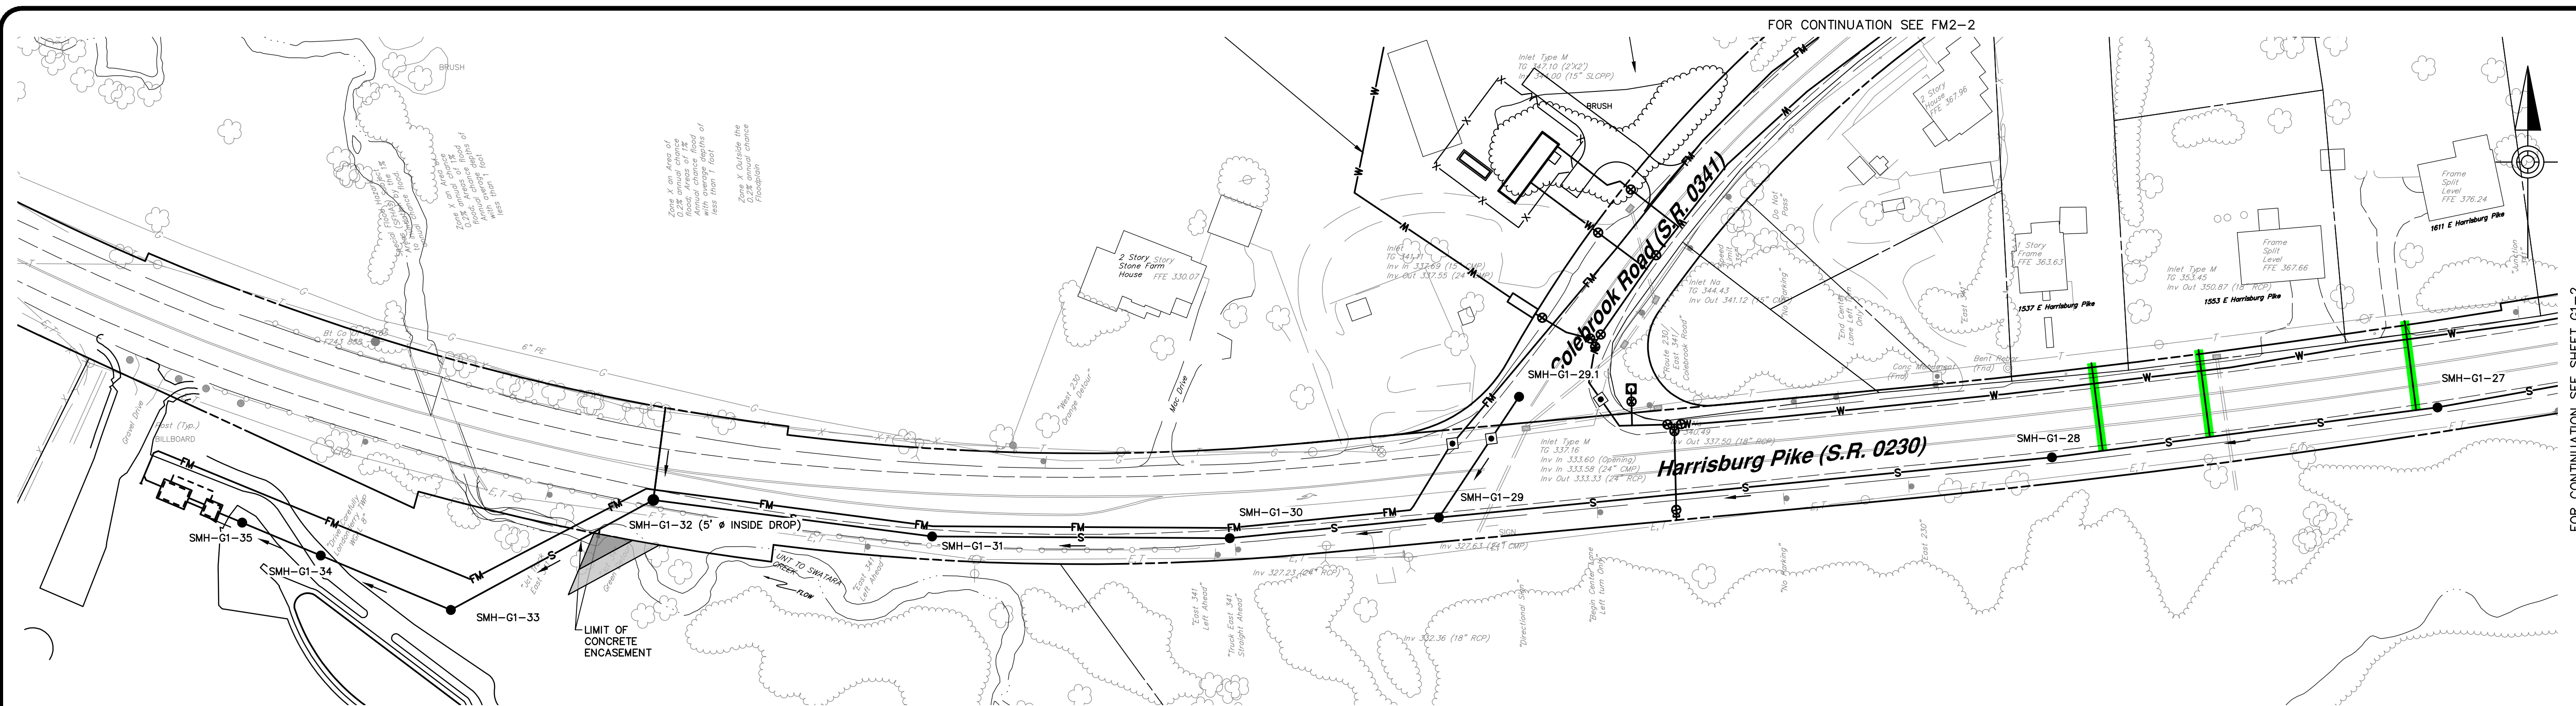


**SANITARY SEWER PLAN**  
SCALE: 1" = 50'

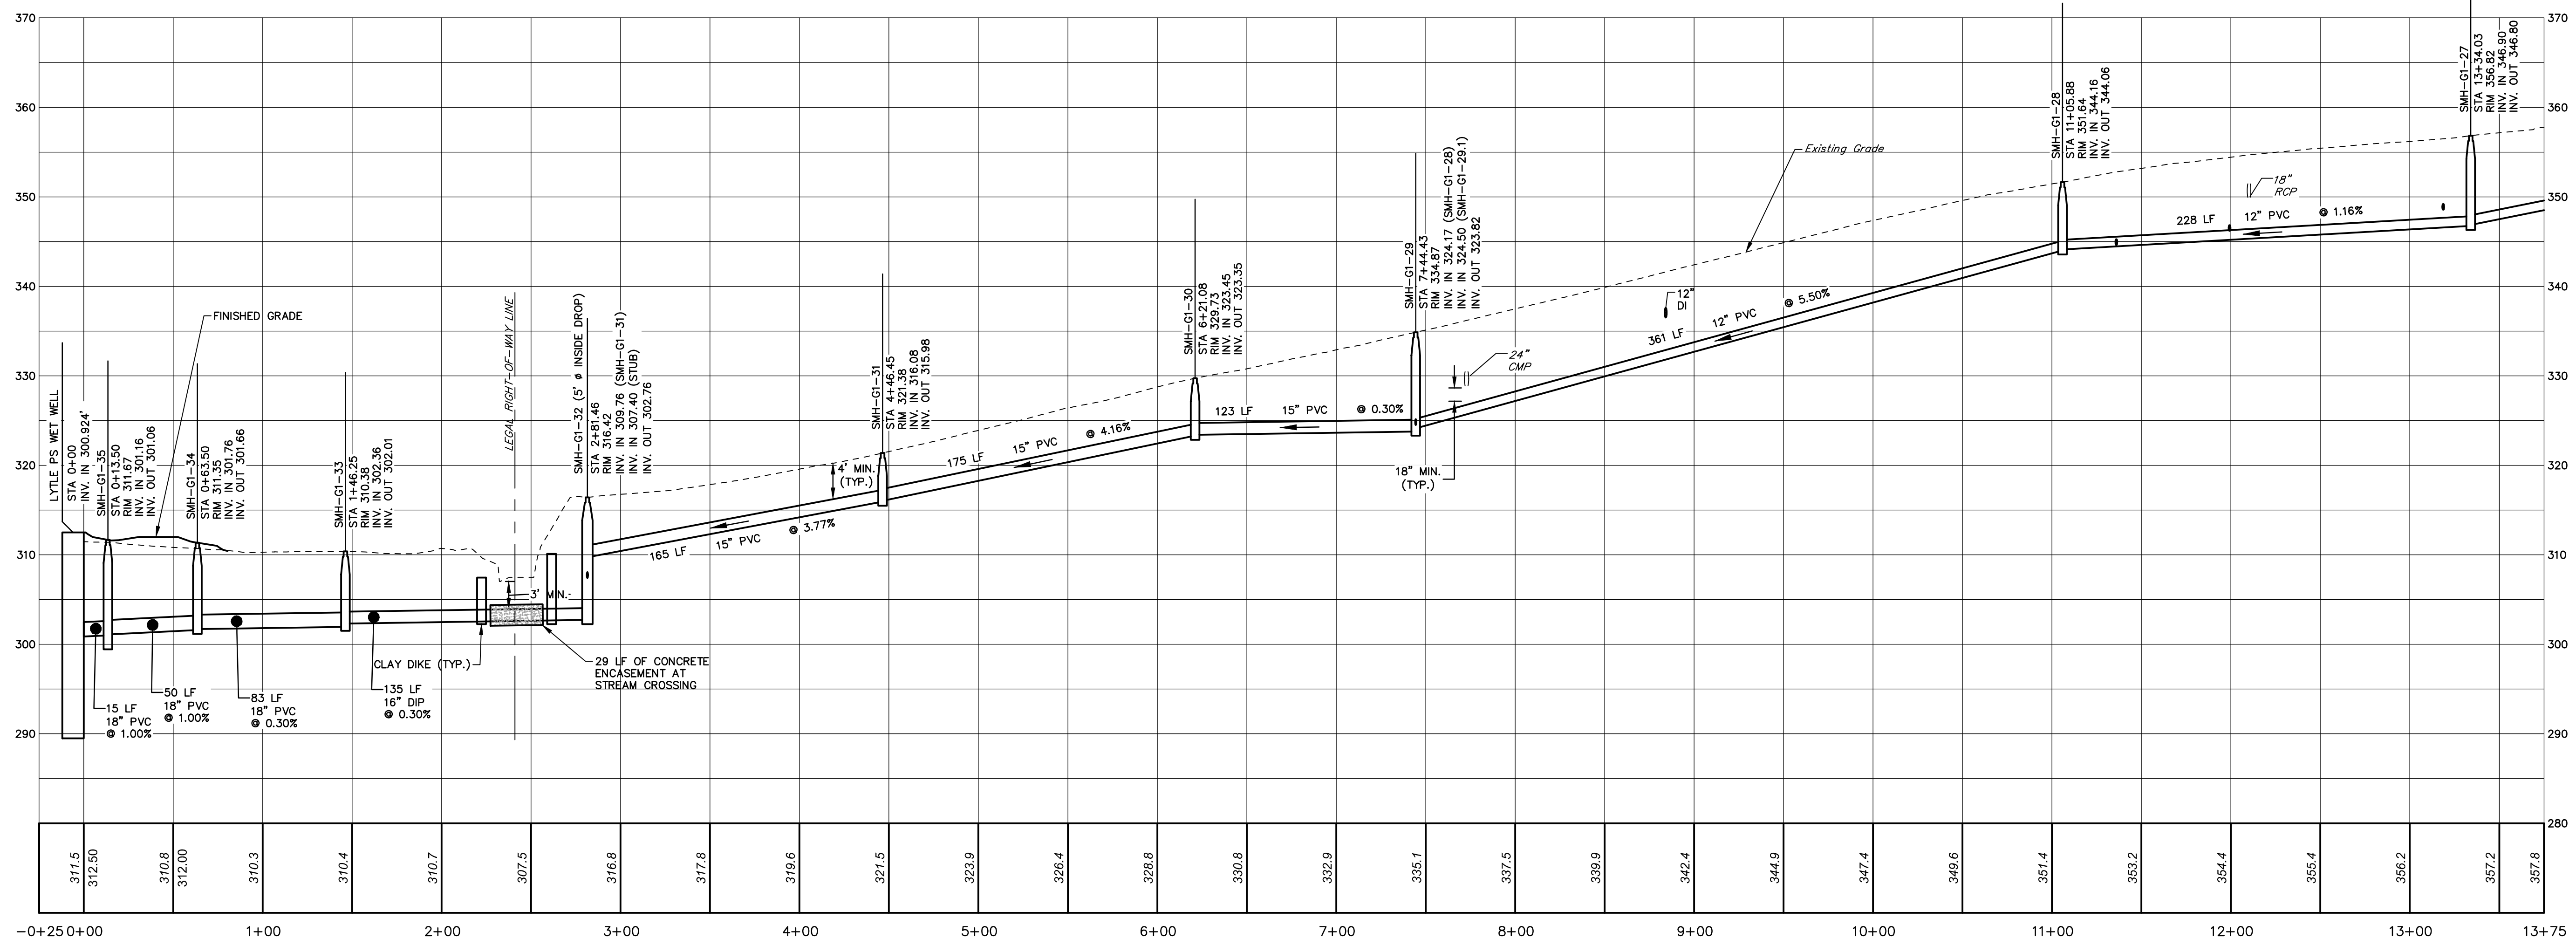


**PROFILE**  
HORIZ. SCALE: 1" = 50'  
VERT. SCALE: 1" = 10'

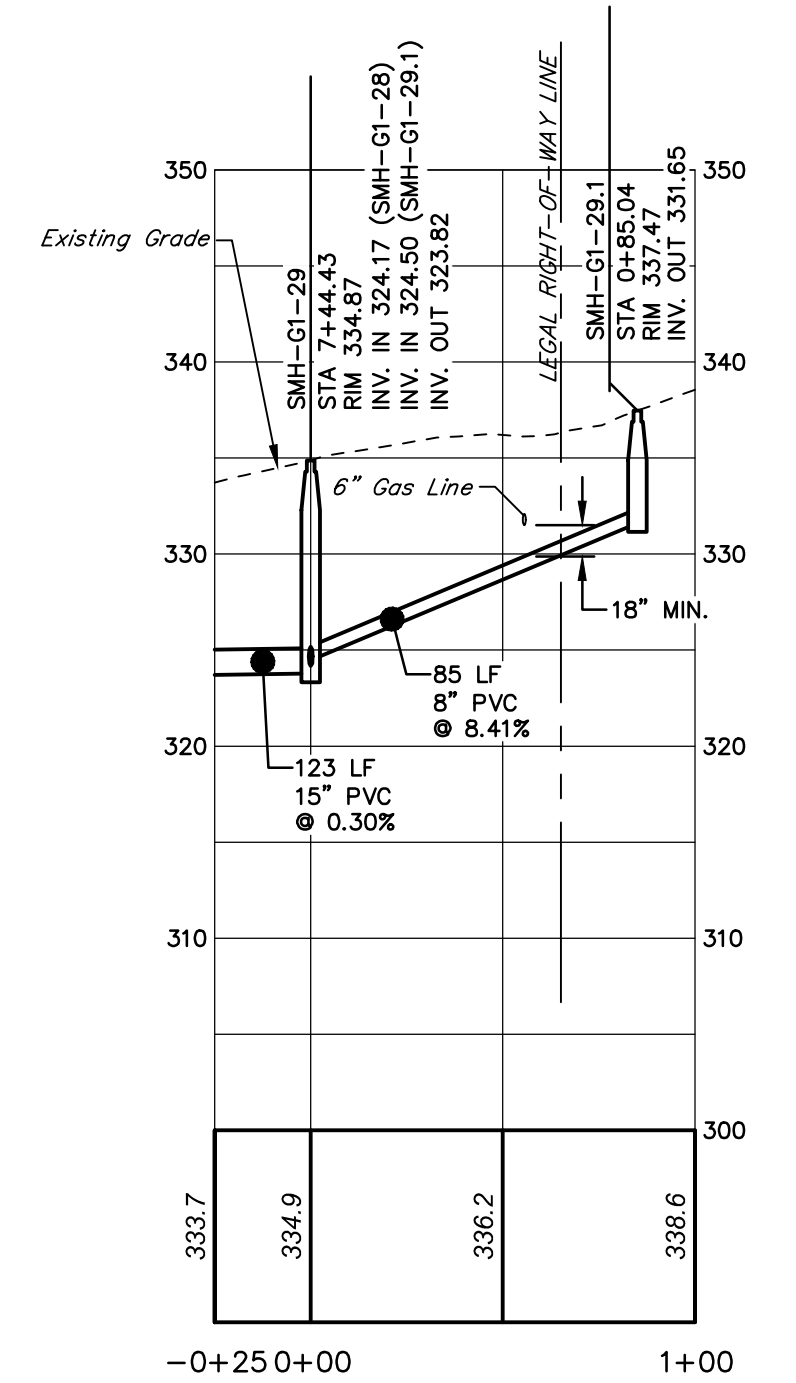

**PROFILE**  
HORIZ. SCALE: 1" = 50'  
VERT. SCALE: 1" = 10'

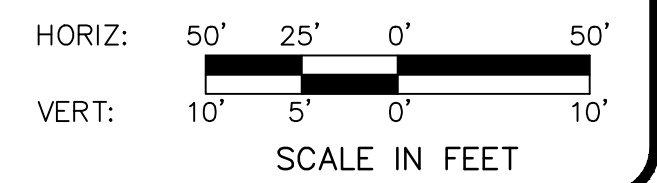

NO.	REVISION	DATE	BY

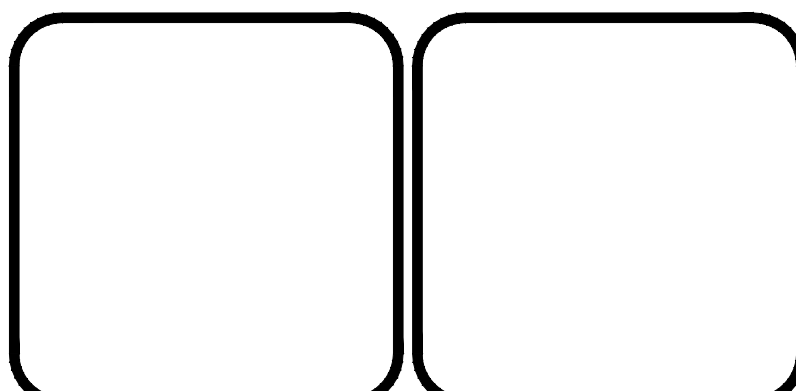

**HRG**  
Herbert, Rowland & Grubic, Inc.  
Engineering & Related Services  
AN EMPLOYEE-OWNED COMPANY

369 East Park Drive  
Harrisburg, PA 17111  
(717) 564-1121  
Fax (717) 564-1158  
hr@hr-g-inc.com  
www.hr-g-inc.com

**CORE5 INDUSTRIAL PARTNERS**  
1250 N. MOUNTAIN ROAD  
HARRISBURG, PA 17112

(717) 461-7730

**SANITARY SEWER PLAN AND PROFILE**  
LYTLE PUMP STATION  
FOR LONDONDERRY TOWNSHIP SANITARY  
SEWER AND WATER EXTENSION PHASE I


LONDONDERRY TOWNSHIP    DAUPHIN COUNTY    PENNSYLVANIA

PROJ. MGR. - JTF
DESIGN - HCK
CADD - KRB
CHECKED - MDC
SCALE - AS NOTED
DATE - SEPT. 2020


DRAWING NO.  
**G1-1**

SHEET NO.  
**31 OF 125**


PROJECT 008048.0428

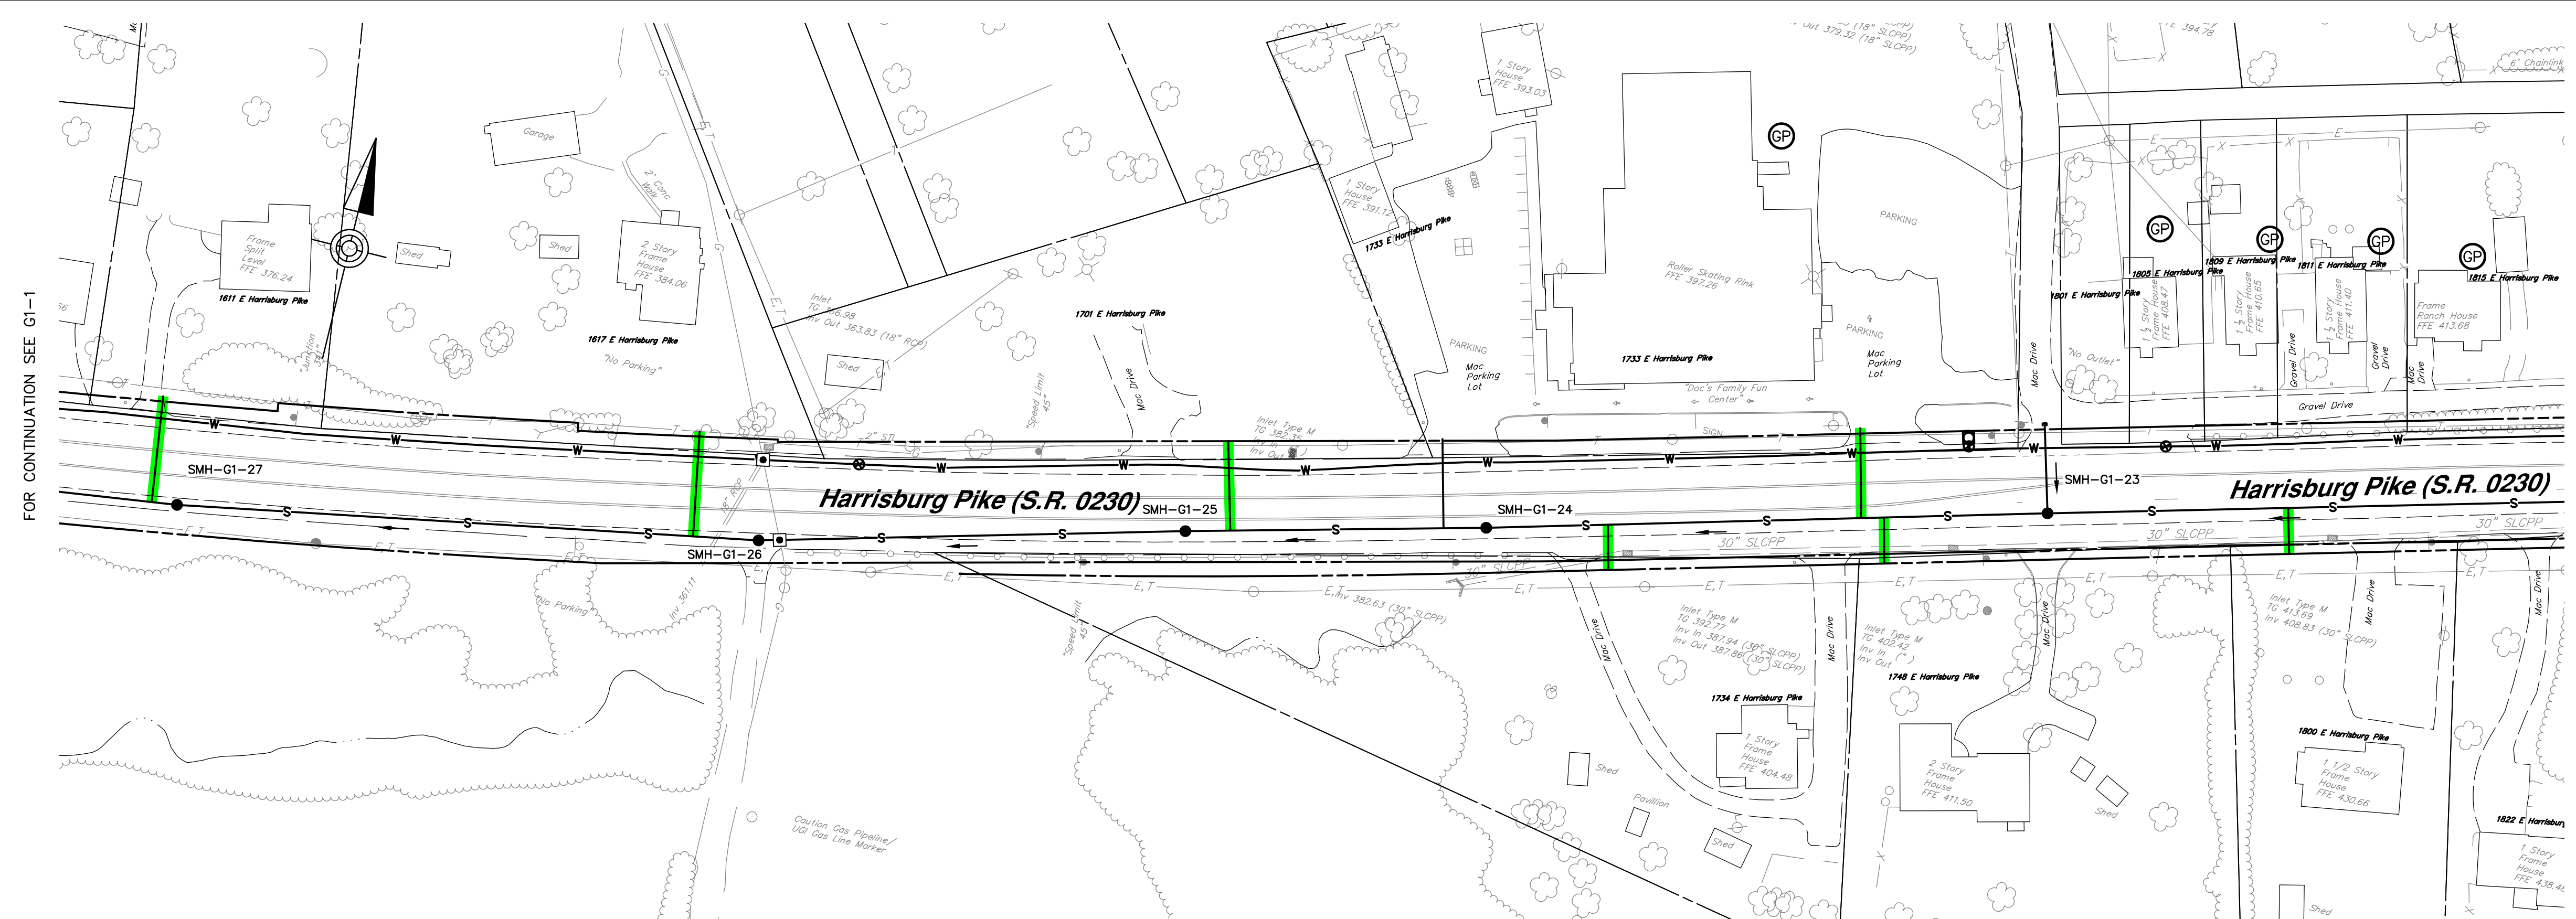


**SANITARY SEWER PLAN**  
SCALE: 1" = 50'

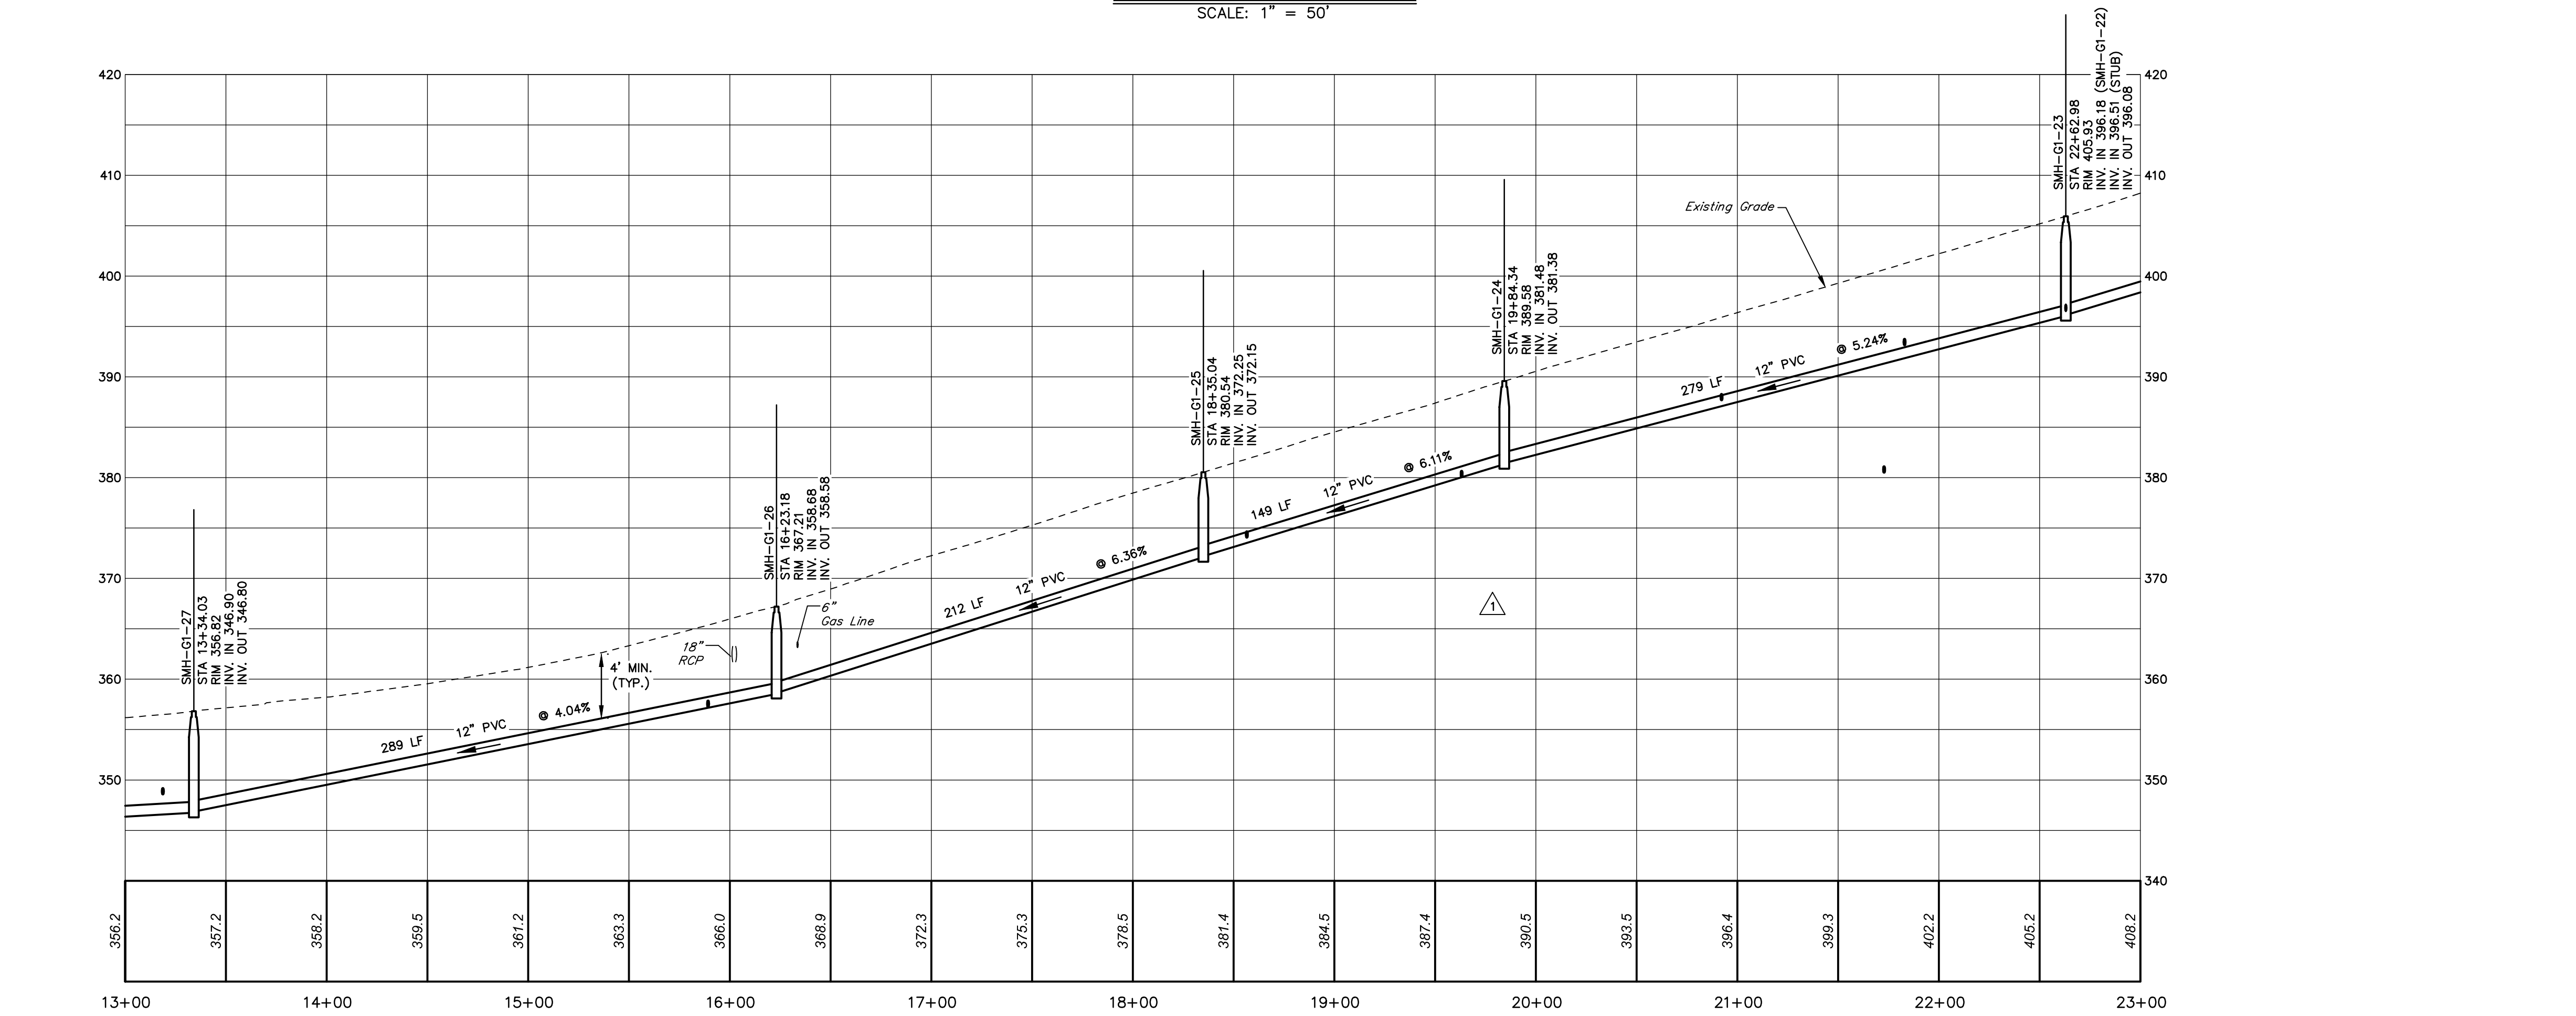

**PROFILE**  
HORIZ. SCALE: 1" = 50'  
VERT. SCALE: 1" = 10'

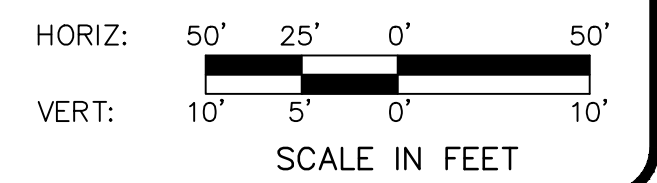

NO.	REVISION	DATE	BY

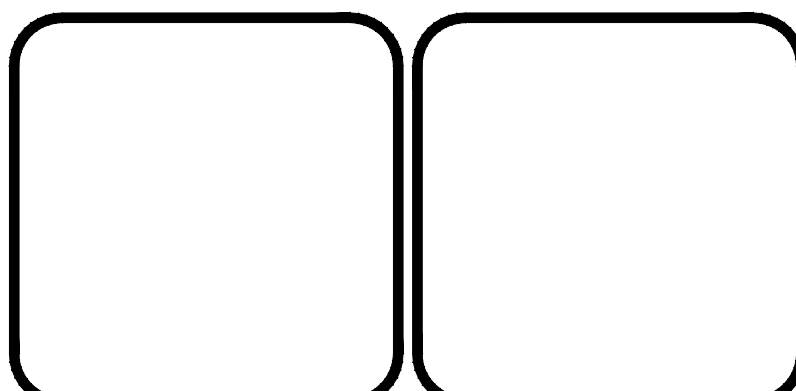

**HRG**  
Herbert, Rowland & Grubic, Inc.  
Engineering & Related Services  
AN EMPLOYEE-OWNED COMPANY

369 East Park Drive  
Harrisburg, PA 17111  
(717) 564-1121  
Fax (717) 564-1158  
hrg@hrg-inc.com  
www.hrg-inc.com

**CORE5 INDUSTRIAL PARTNERS**  
1250 N. MOUNTAIN ROAD  
HARRISBURG, PA 17112  
(717) 461-7730

**SANITARY SEWER PLAN AND PROFILE**  
LYTLE PUMP STATIONS  
FOR LONDONDERRY TOWNSHIP SANITARY  
SEWER AND WATER EXTENSION PHASE I  
LONDONDERRY TOWNSHIP DAUPHIN COUNTY PENNSYLVANIA

PROJ. MGR. - JTF
DESIGN - HCK
CADD - KRB
CHECKED - MDC
SCALE - AS NOTED
DATE - SEPT. 2020

DRAWING NO.  
**G1-2**  
SHEET NO.  
**32 OF 125**  
PROJECT 008048.0428




FOR CONTINUATION SEE SHEET G1-2


FOR CONTINUATION SEE SHEET G1-4

**SANITARY SEWER PLAN**


SCALE: 1" = 50'

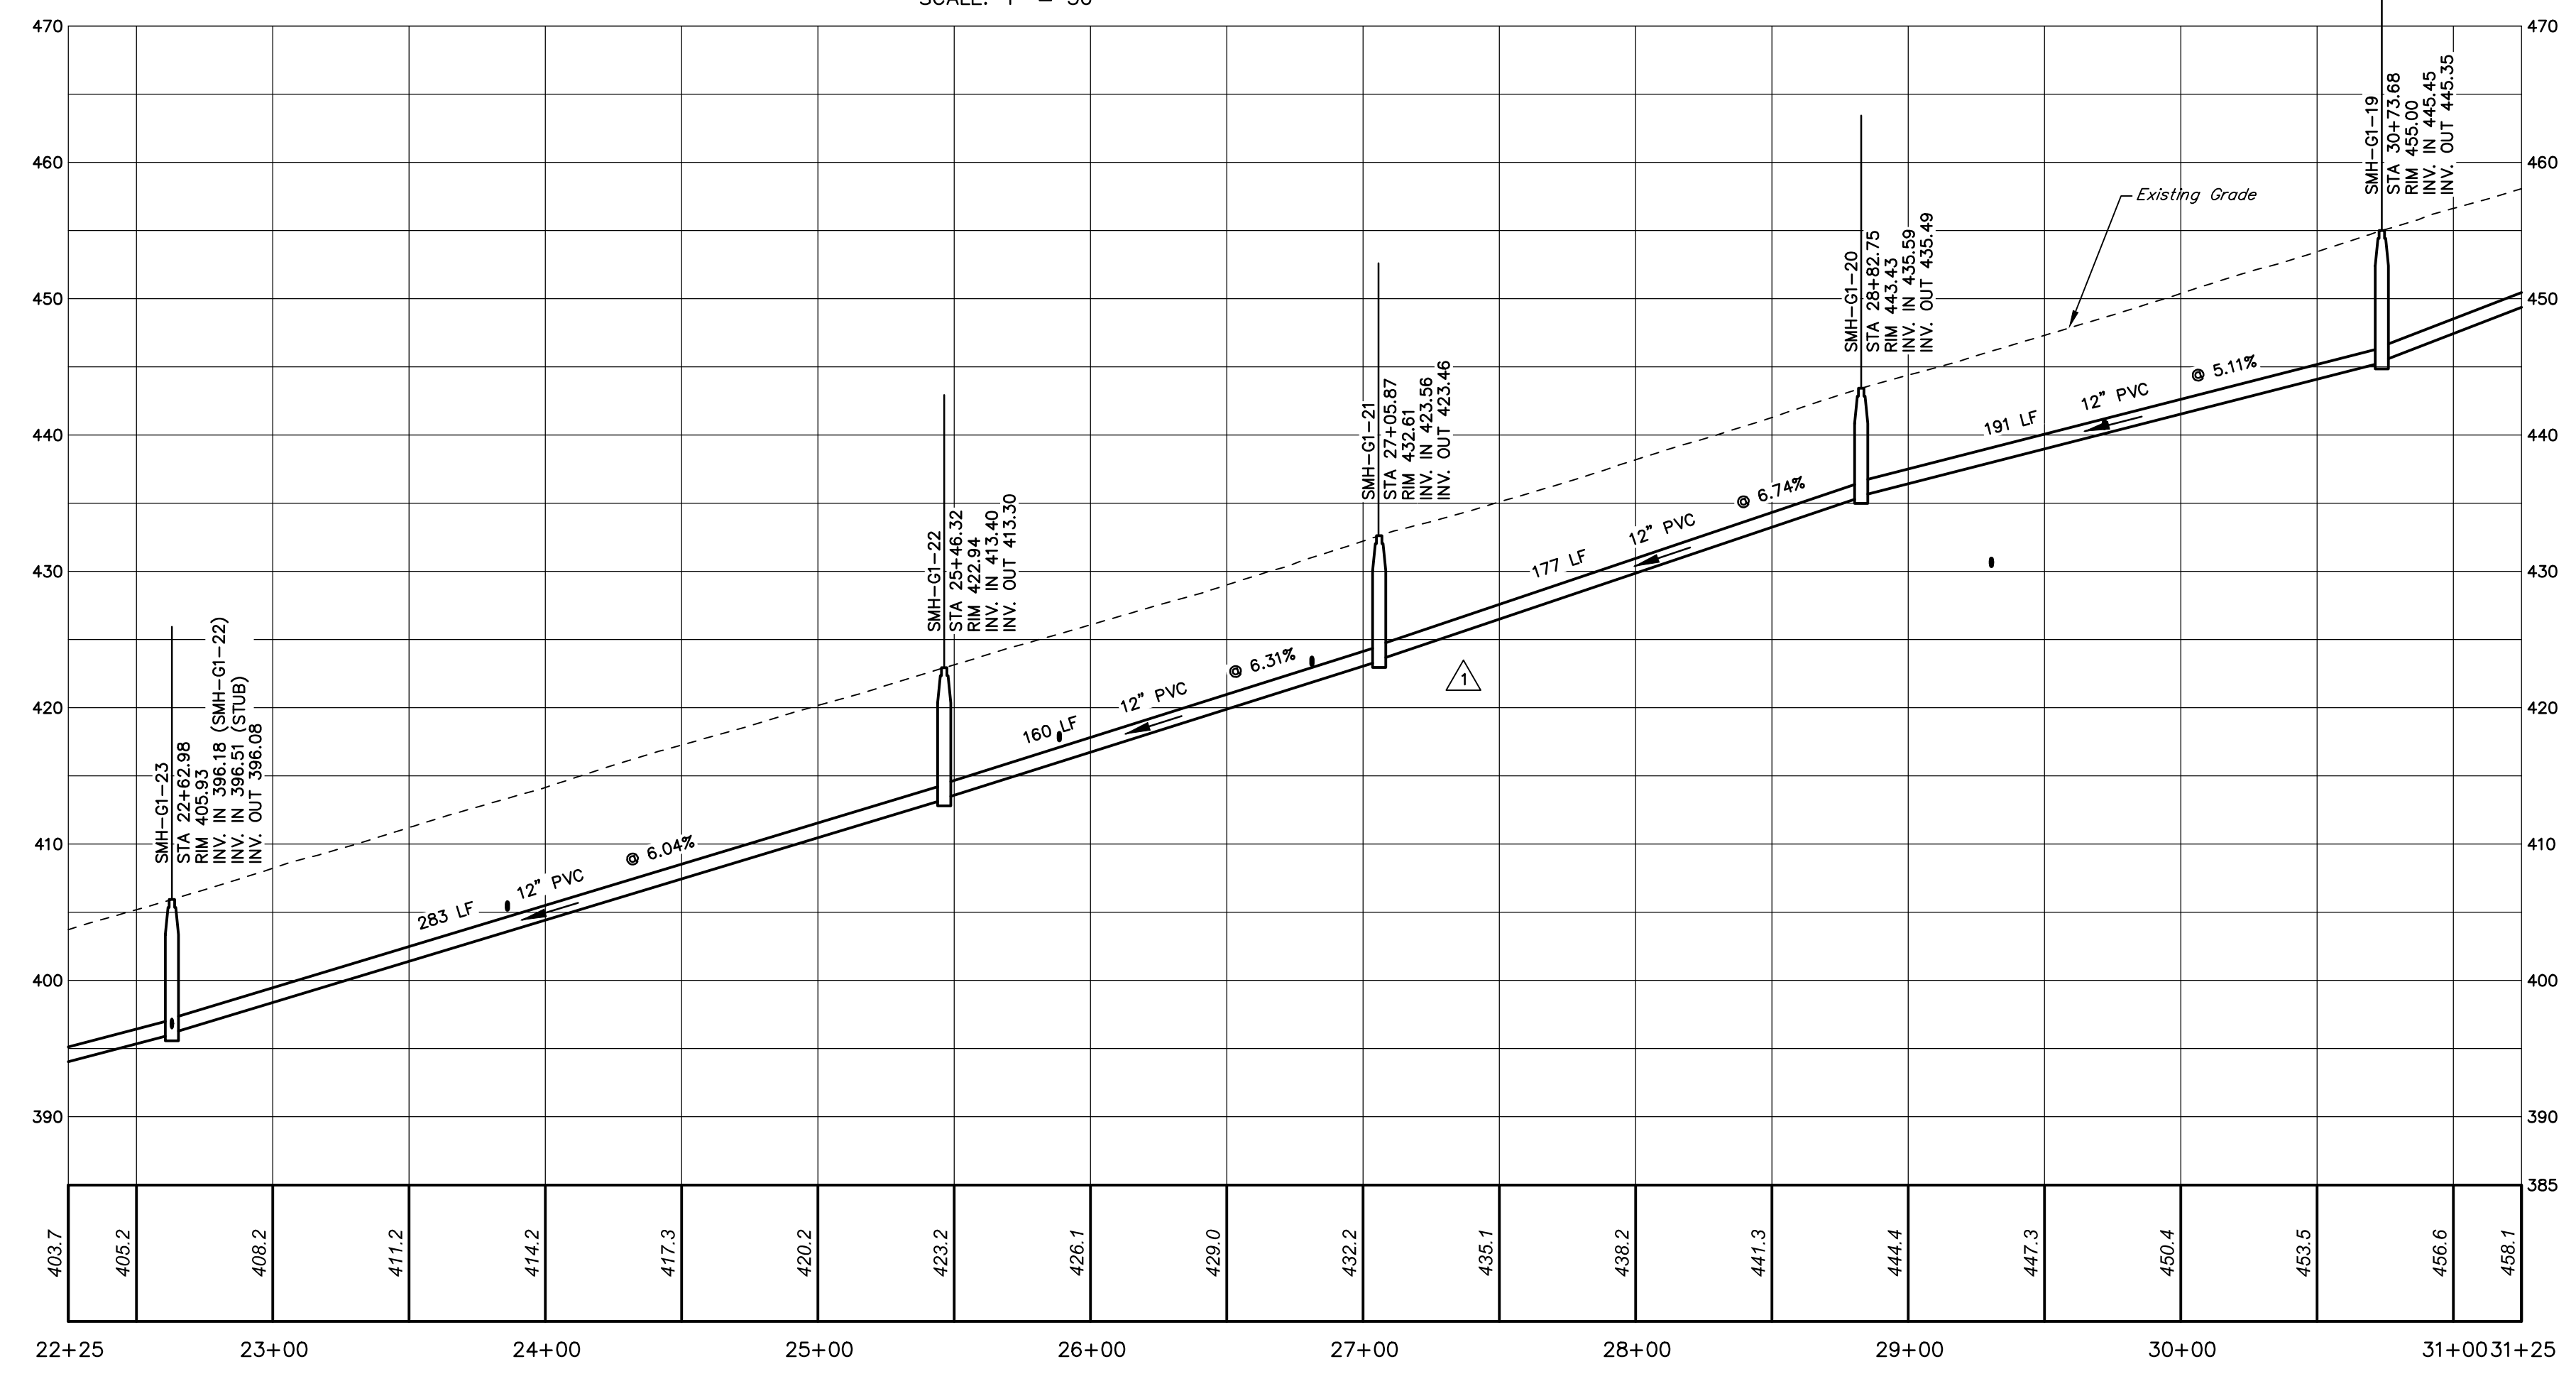

**PROFILE**  
 HORIZ. SCALE: 1" = 50'  
 VERT. SCALE: 1" = 10'

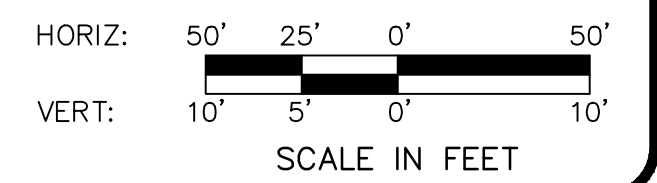

NO.	REVISION	DATE	BY

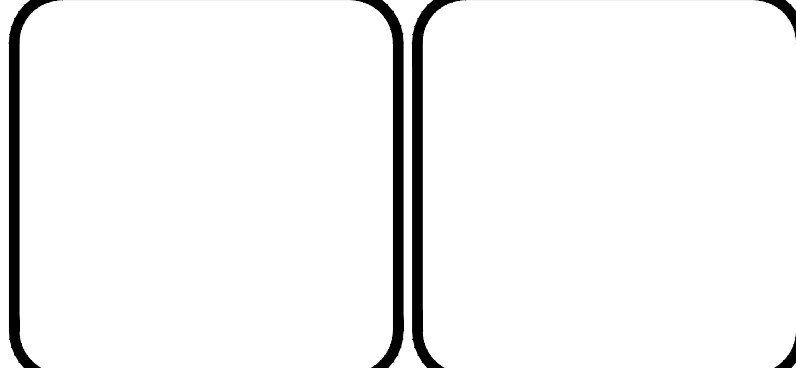

**HRG**  
 Herbert, Rowland & Grubic, Inc.  
 Engineering & Related Services  
 AN EMPLOYEE-OWNED COMPANY


369 East Park Drive  
 Harrisburg, PA 17111  
 (717) 564-1121  
 Fax (717) 564-1158  
 hrg@hrg-inc.com  
 www.hrg-inc.com

**CORE5 INDUSTRIAL PARTNERS**  
 1250 N. MOUNTAIN ROAD  
 HARRISBURG, PA 17112  
 (717) 461-7730

**SANITARY SEWER PLAN AND PROFILE**  
 LYTLE PUMP STATION  
 FOR LONDONDERRY TOWNSHIP SANITARY  
 SEWER AND WATER EXTENSION PHASE I  
 LONDONDERRY TOWNSHIP DAUPHIN COUNTY PENNSYLVANIA

PROJ. MGR. - JTF
DESIGN - HCK
CADD - KRB
CHECKED - MDC
SCALE - AS NOTED
DATE - SEPT. 2020


DRAWING NO.  
**G1-3**  
 SHEET NO.  
**33 OF 125**  
 PROJECT 008048.0428

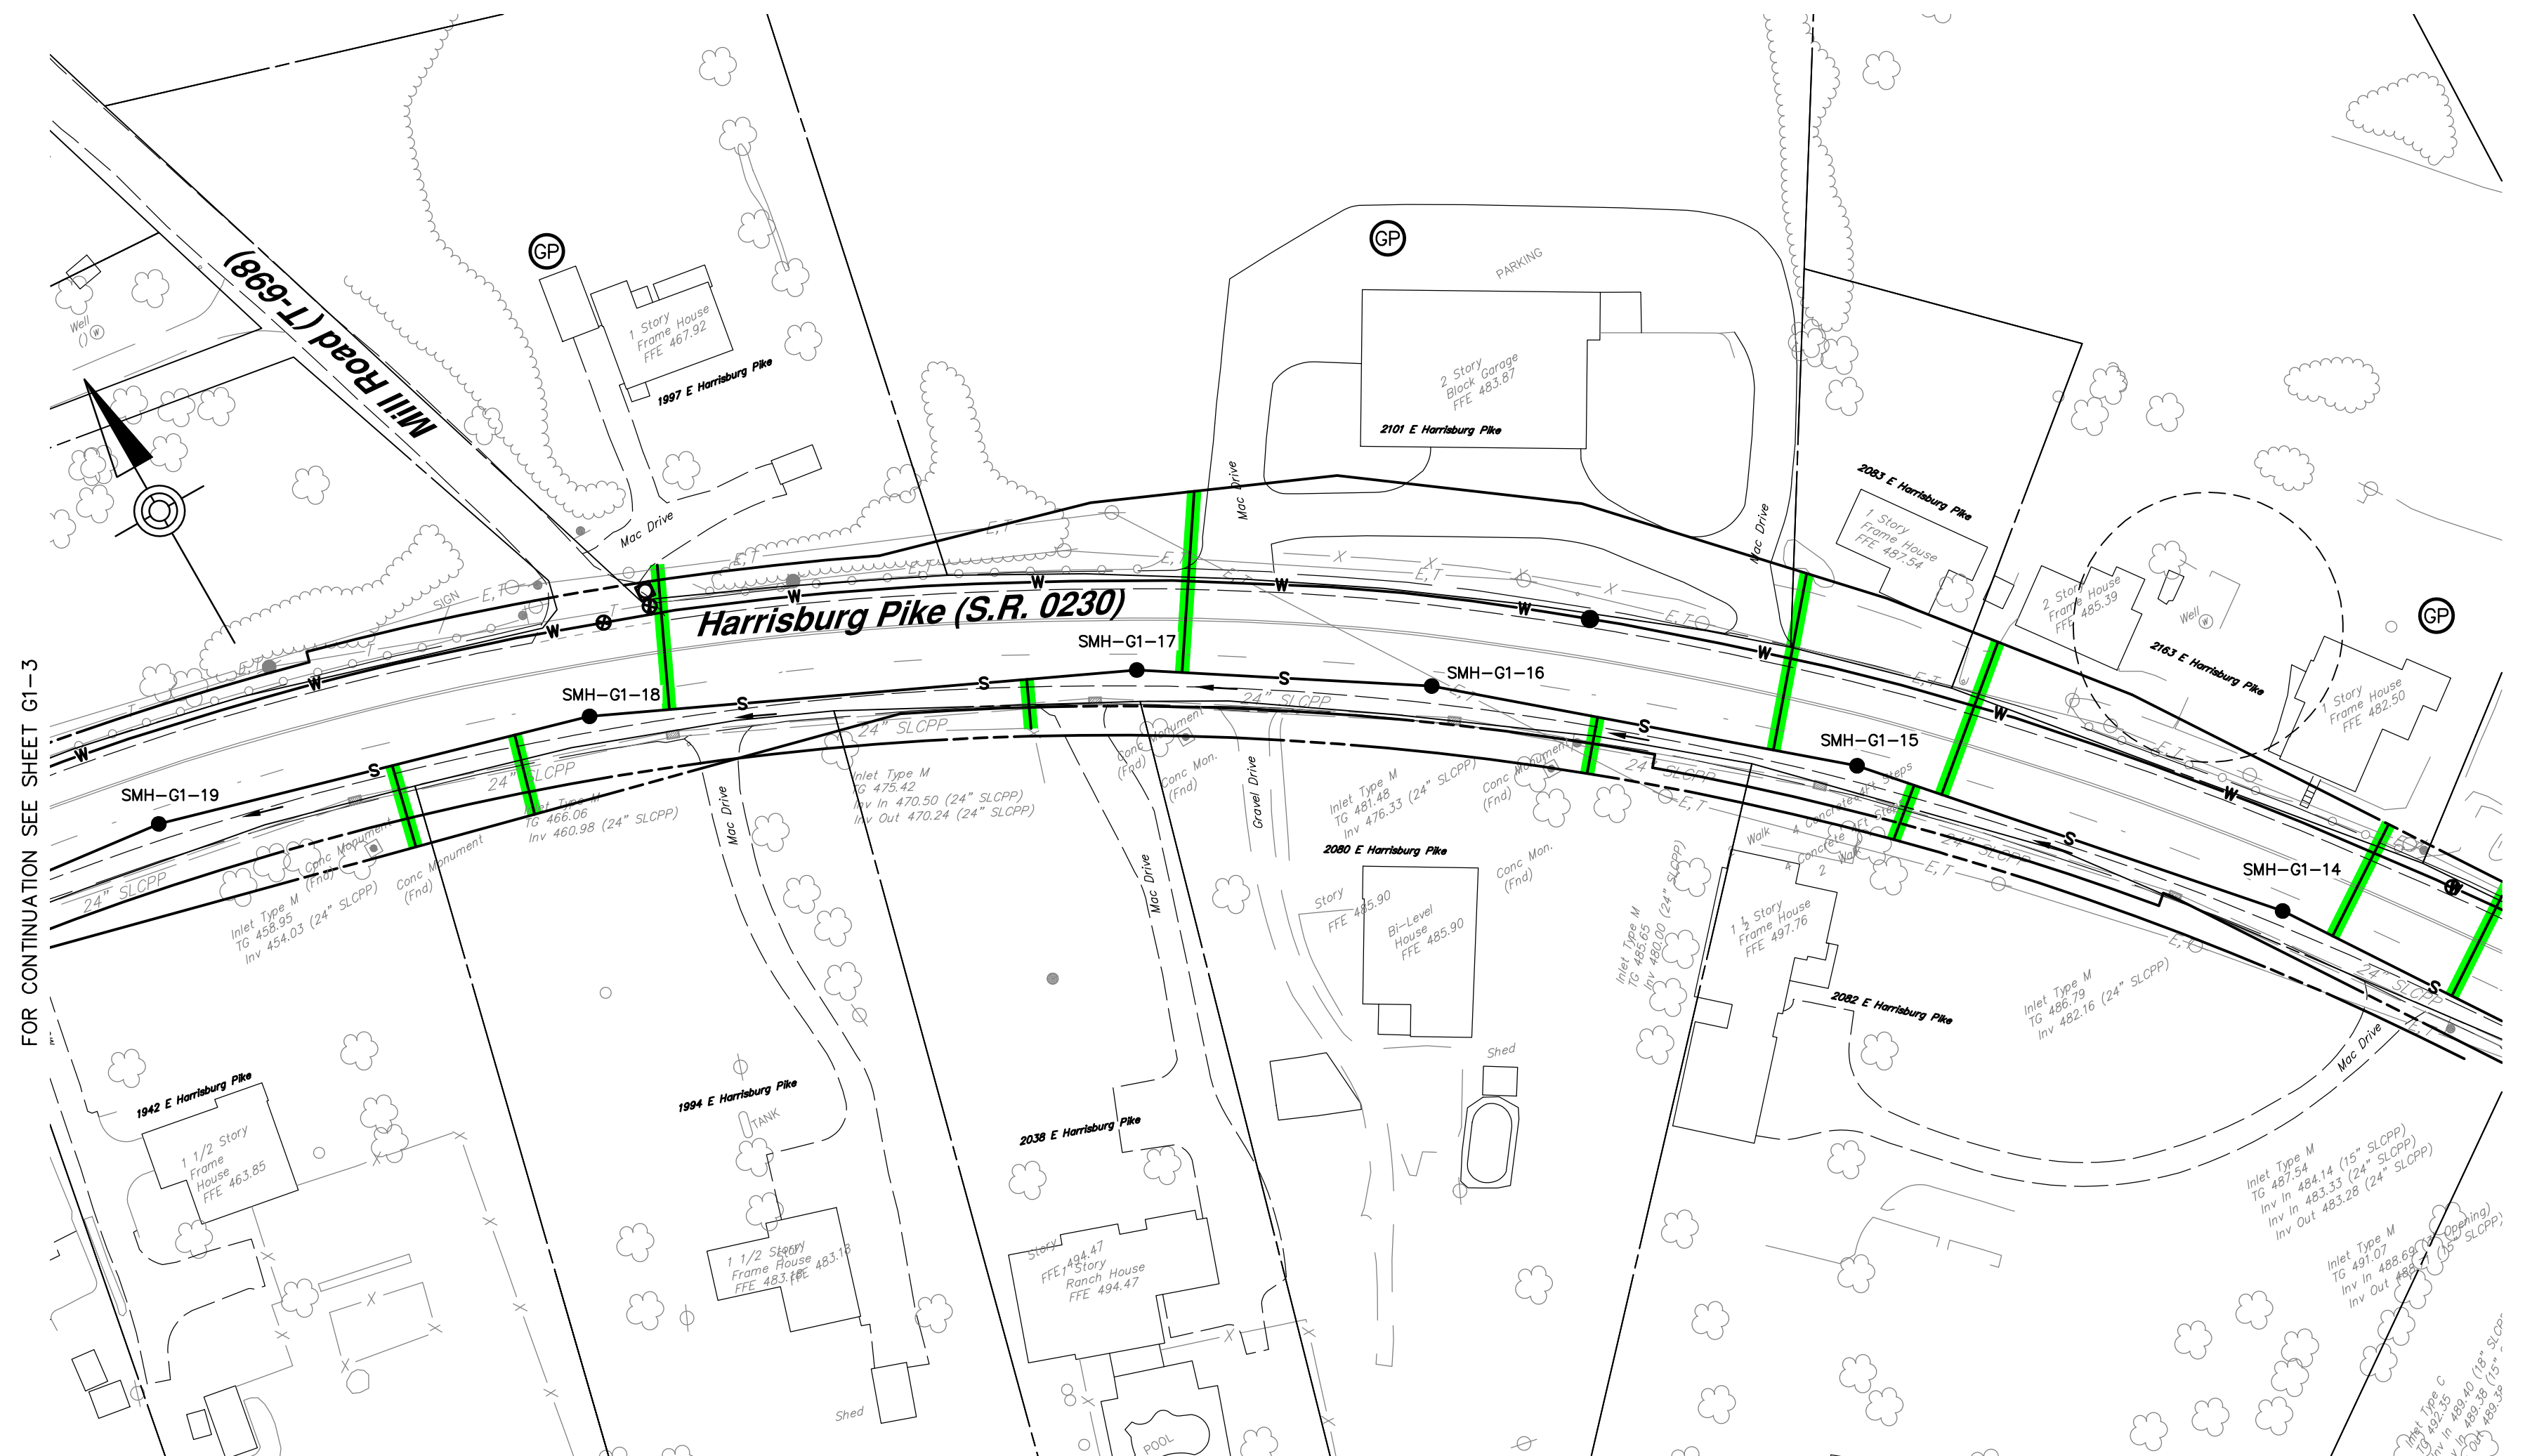


FOR CONTINUATION SEE SHEET G1-3

FOR CONTINUATION SEE SHEET G1-5


**SANITARY SEWER PLAN**  
SCALE: 1" = 50'

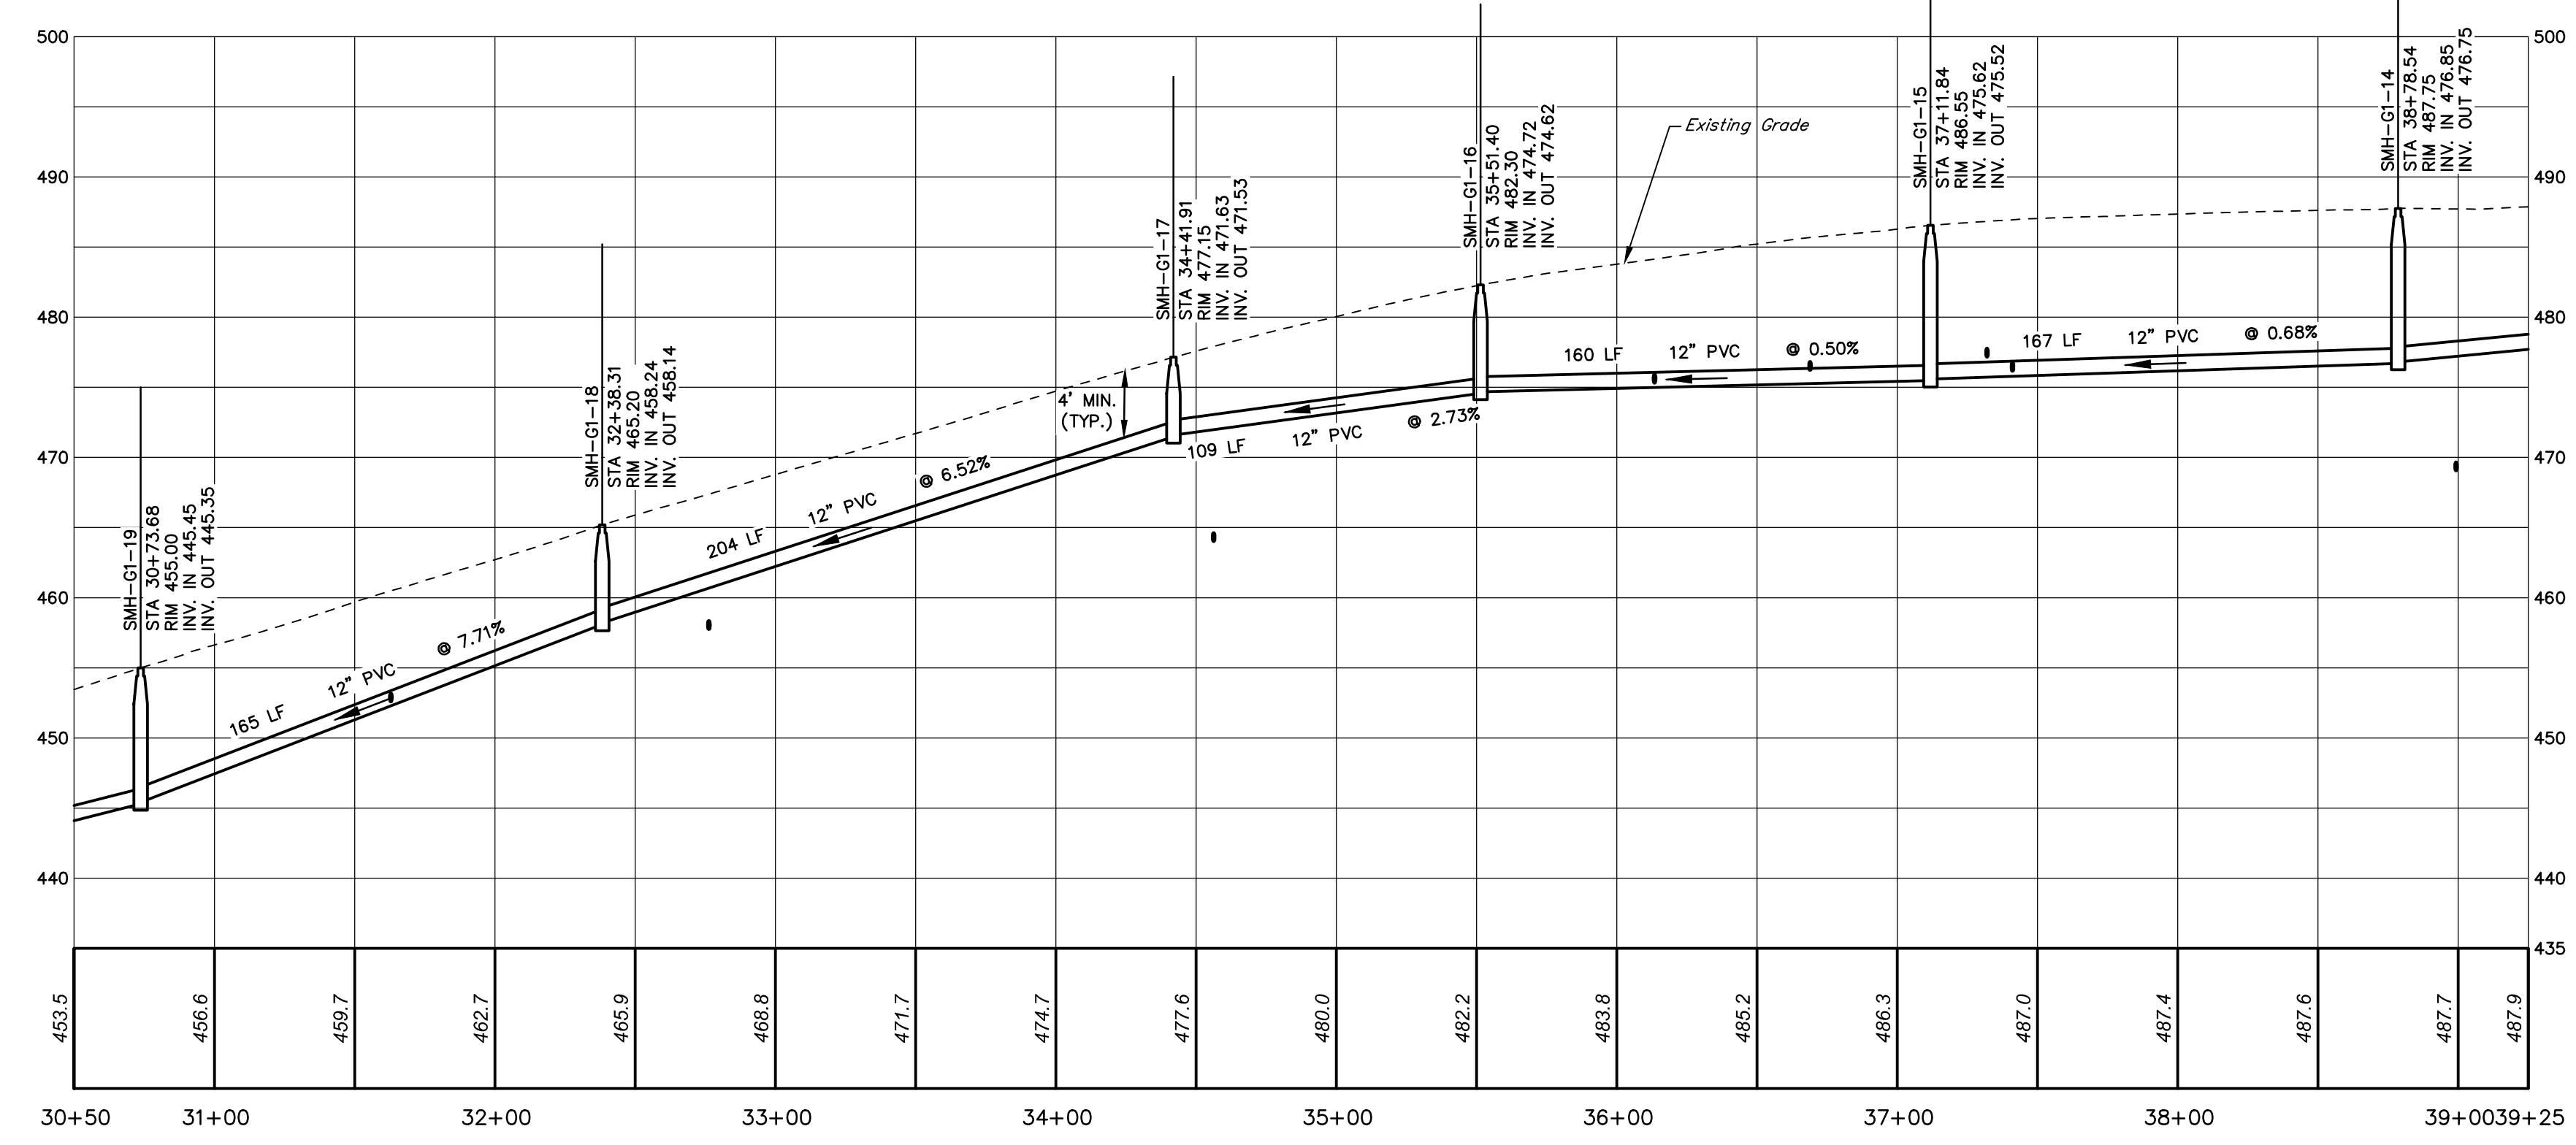

**PROFILE**  
HORIZ. SCALE: 1" = 50'  
VERT. SCALE: 1" = 10'

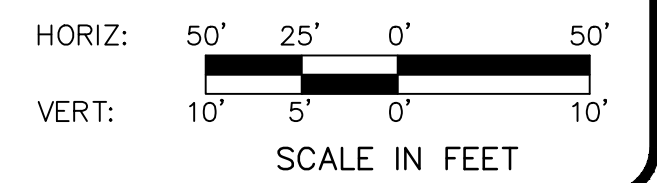

NO.	REVISION	DATE	BY

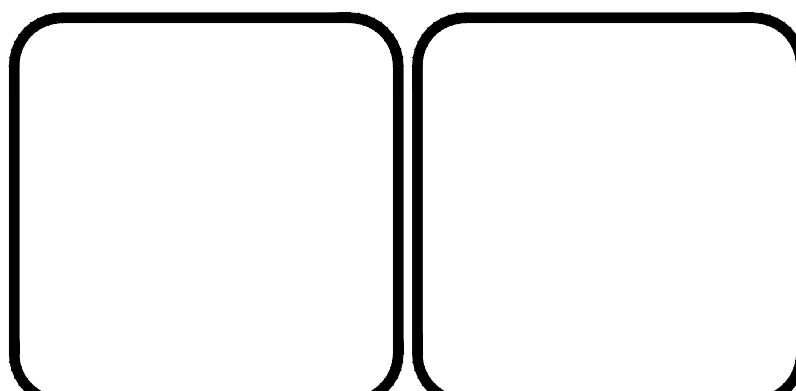

**HRG**  
Herbert, Rowland & Grubic, Inc.  
Engineering & Related Services  
AN EMPLOYEE-OWNED COMPANY


369 East Park Drive  
Harrisburg, PA 17111  
(717) 564-1121  
Fax (717) 564-1158  
hr@hr-g-inc.com  
www.hr-g-inc.com

**CORE5 INDUSTRIAL PARTNERS**  
1250 N. MOUNTAIN ROAD  
HARRISBURG, PA 17112  
(717) 461-7730

**SANITARY SEWER PLAN AND PROFILE**  
LYTLE PUMP STATION  
FOR LONDONDERRY TOWNSHIP SANITARY  
SEWER AND WATER EXTENSION PHASE I  
LONDONDERRY TOWNSHIP DAUPHIN COUNTY PENNSYLVANIA

PROJ. MGR. - JTF
DESIGN - HCK
CADD - KRB
CHECKED - MDC
SCALE - AS NOTED
DATE - SEPT. 2020


DRAWING NO.  
**G1-4**  
SHEET NO.  
**34 OF 125**  
PROJECT 008048.0428

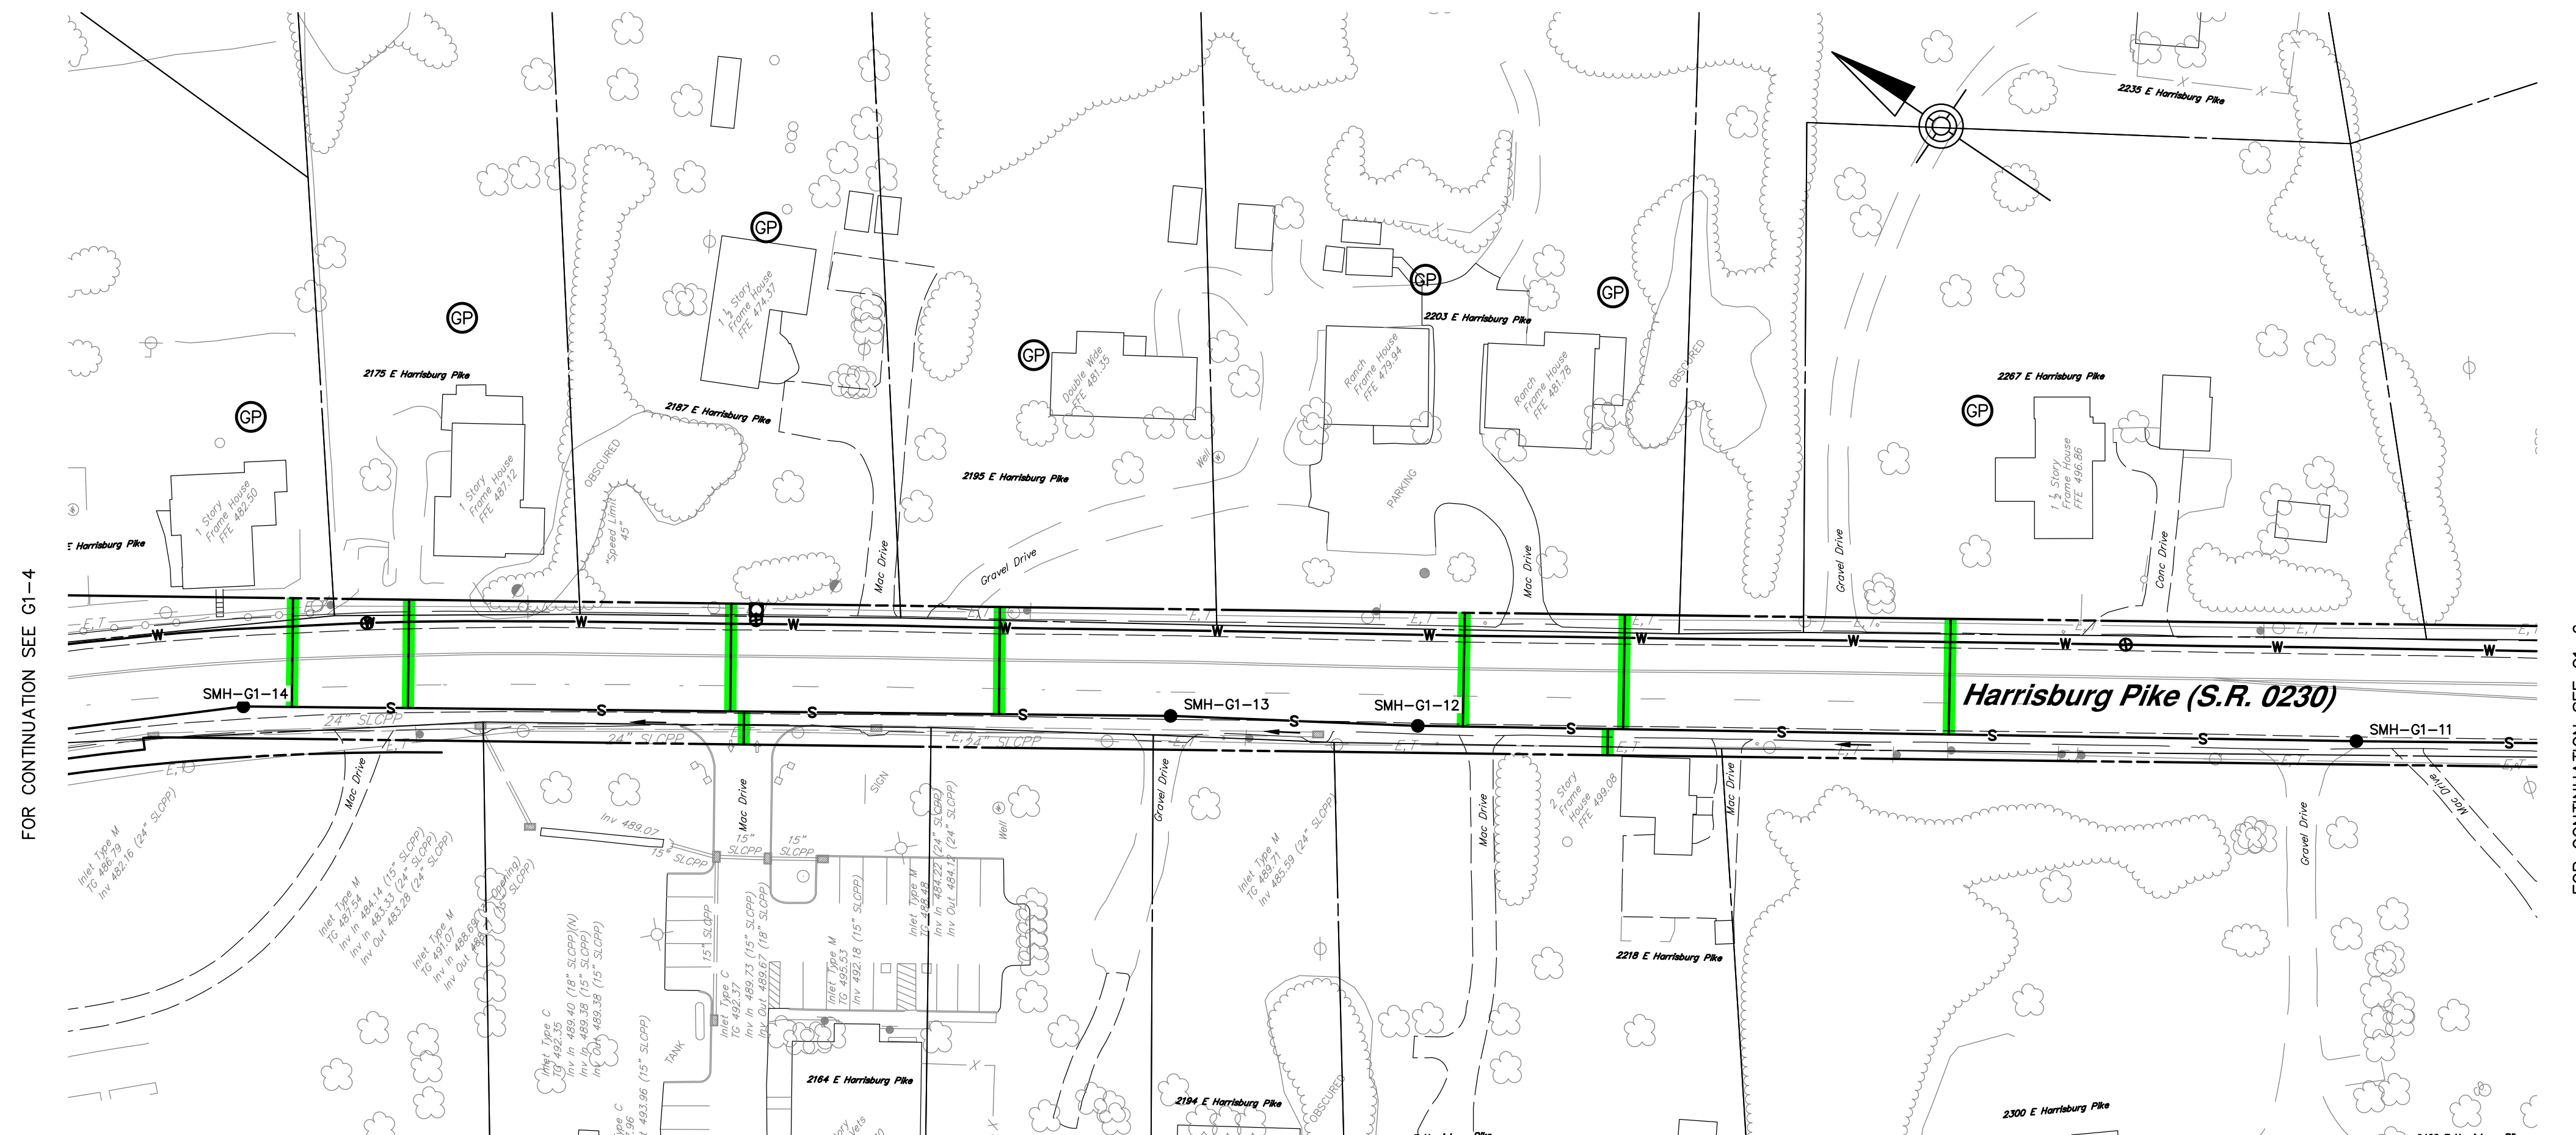


FOR CONTINUATION SEE G1-4

FOR CONTINUATION SEE G1-6


**SANITARY SEWER PLAN**  
SCALE: 1" = 50'

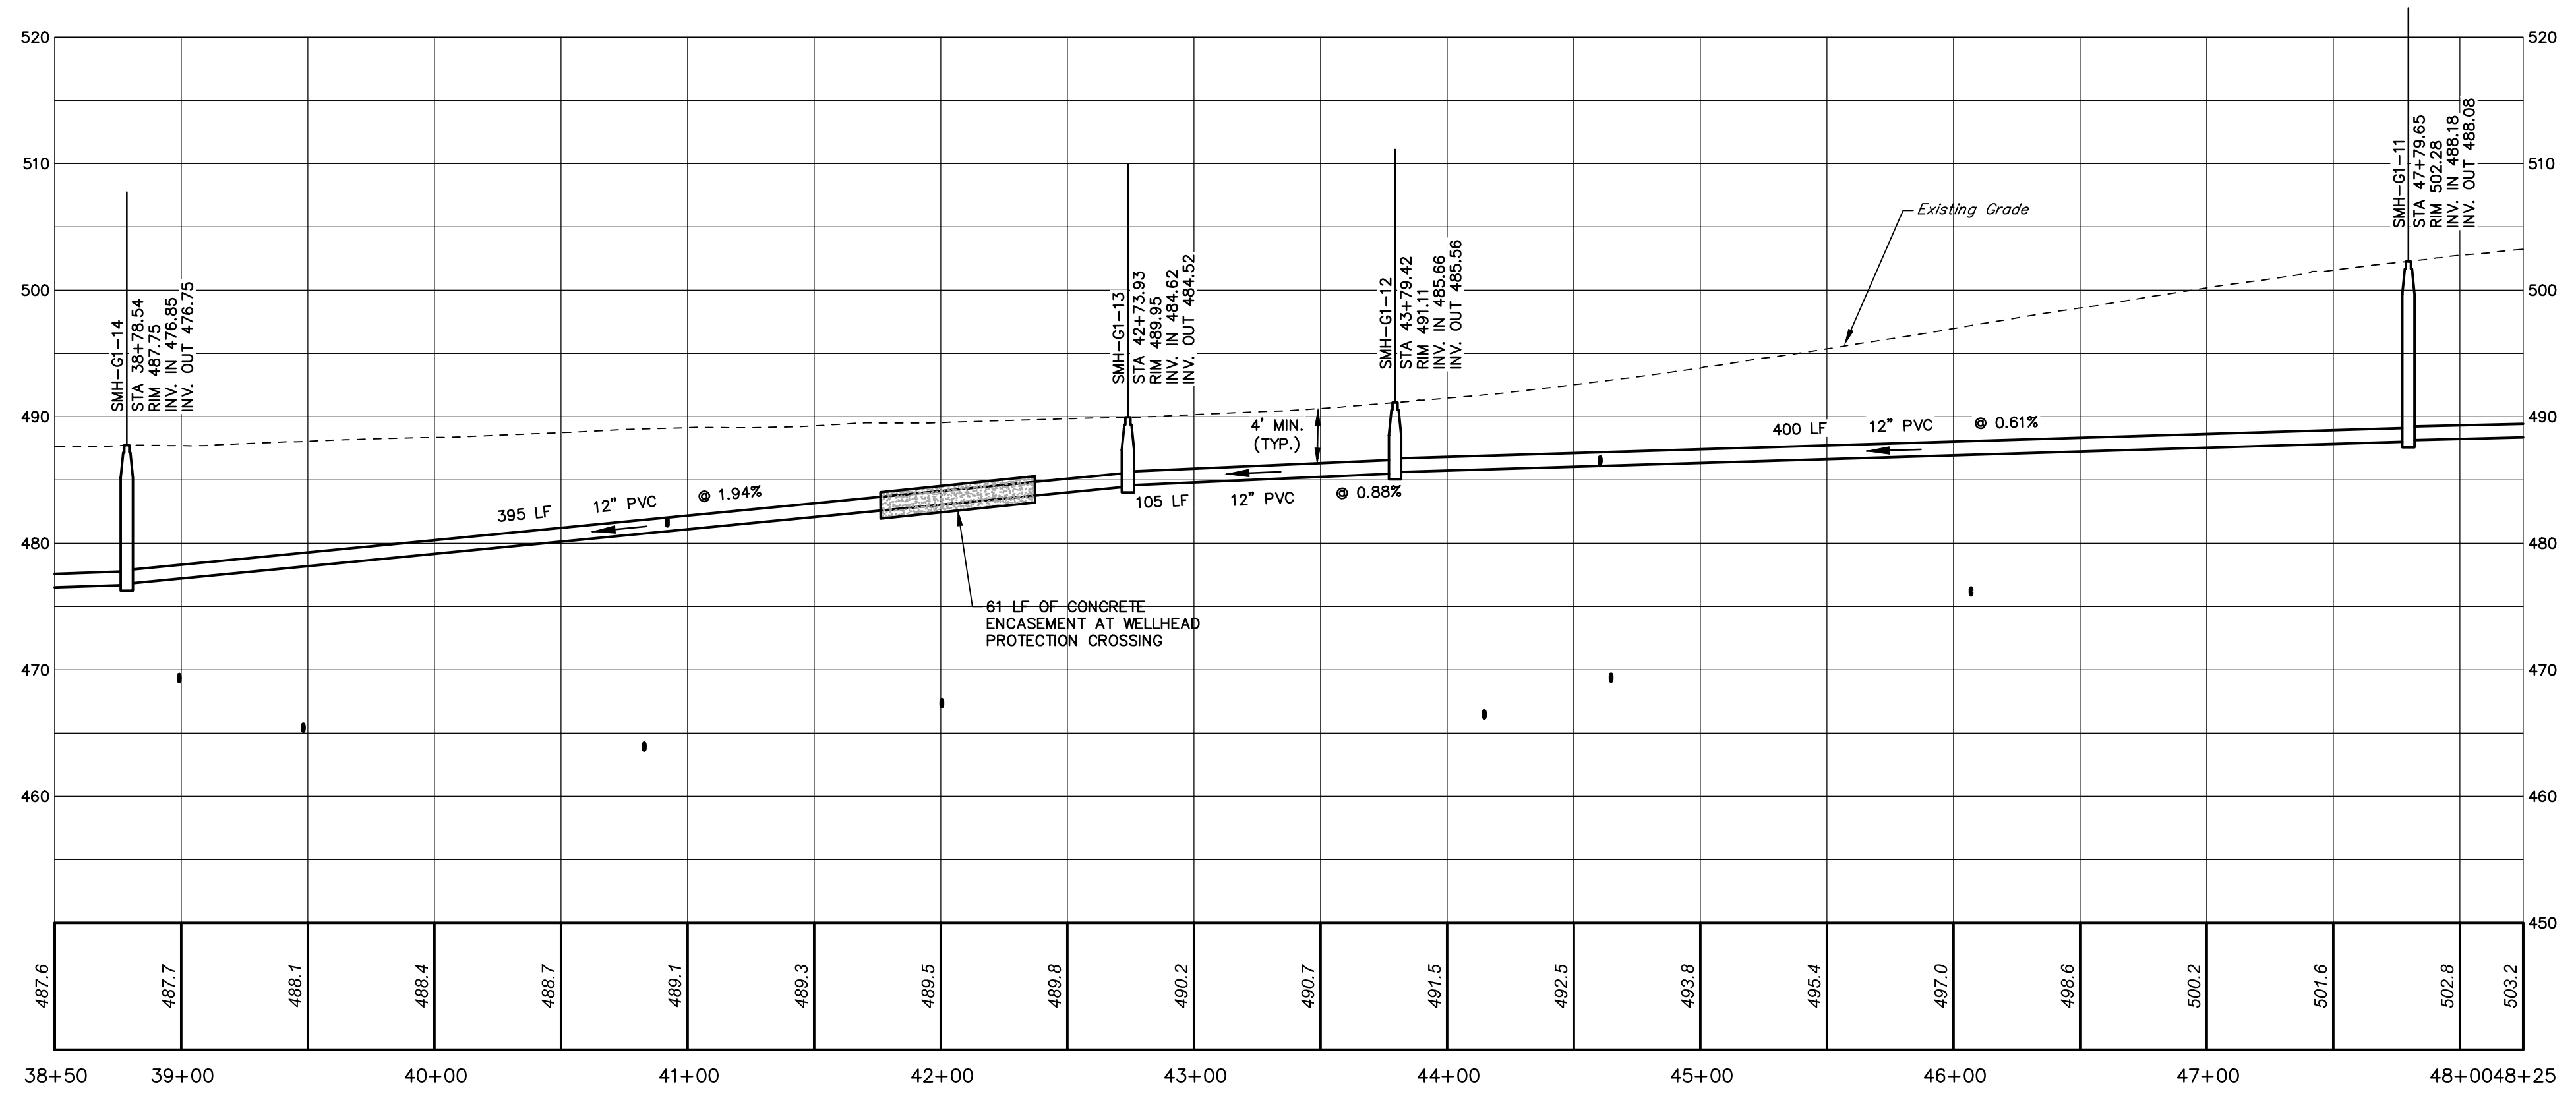

**PROFILE**  
HORIZ. SCALE: 1" = 50'  
VERT. SCALE: 1" = 10'

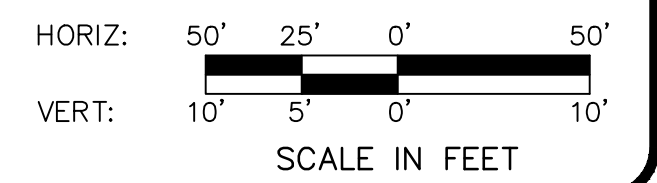

NO.	REVISION	DATE	BY

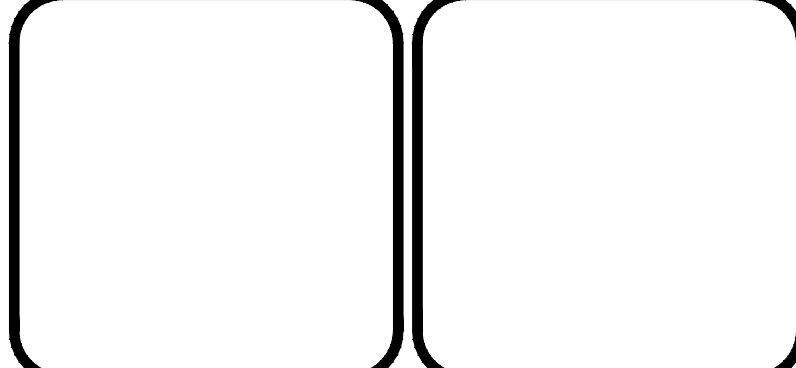

**HRG**  
Herbert, Rowland & Grubic, Inc.  
Engineering & Related Services  
AN EMPLOYEE-OWNED COMPANY


369 East Park Drive  
Harrisburg, PA 17111  
(717) 564-1121  
Fax (717) 564-1158  
hrg@hrg-inc.com  
www.hrg-inc.com

**CORE5 INDUSTRIAL PARTNERS**  
1250 N. MOUNTAIN ROAD  
HARRISBURG, PA 17112  
(717) 461-7730

**SANITARY SEWER PLAN AND PROFILE**  
LYTLE PUMP STATION  
FOR LONDONDERRY TOWNSHIP SANITARY  
SEWER AND WATER EXTENSION PHASE I  
LONDONDERRY TOWNSHIP DAUPHIN COUNTY PENNSYLVANIA

PROJ. MGR. - JTF
DESIGN - HCK
CADD - KRB
CHECKED - MDC
SCALE - AS NOTED
DATE - SEPT. 2020

DRAWING NO.  
**G1-5**  
SHEET NO.  
**35 OF 125**  
PROJECT 008048.0428

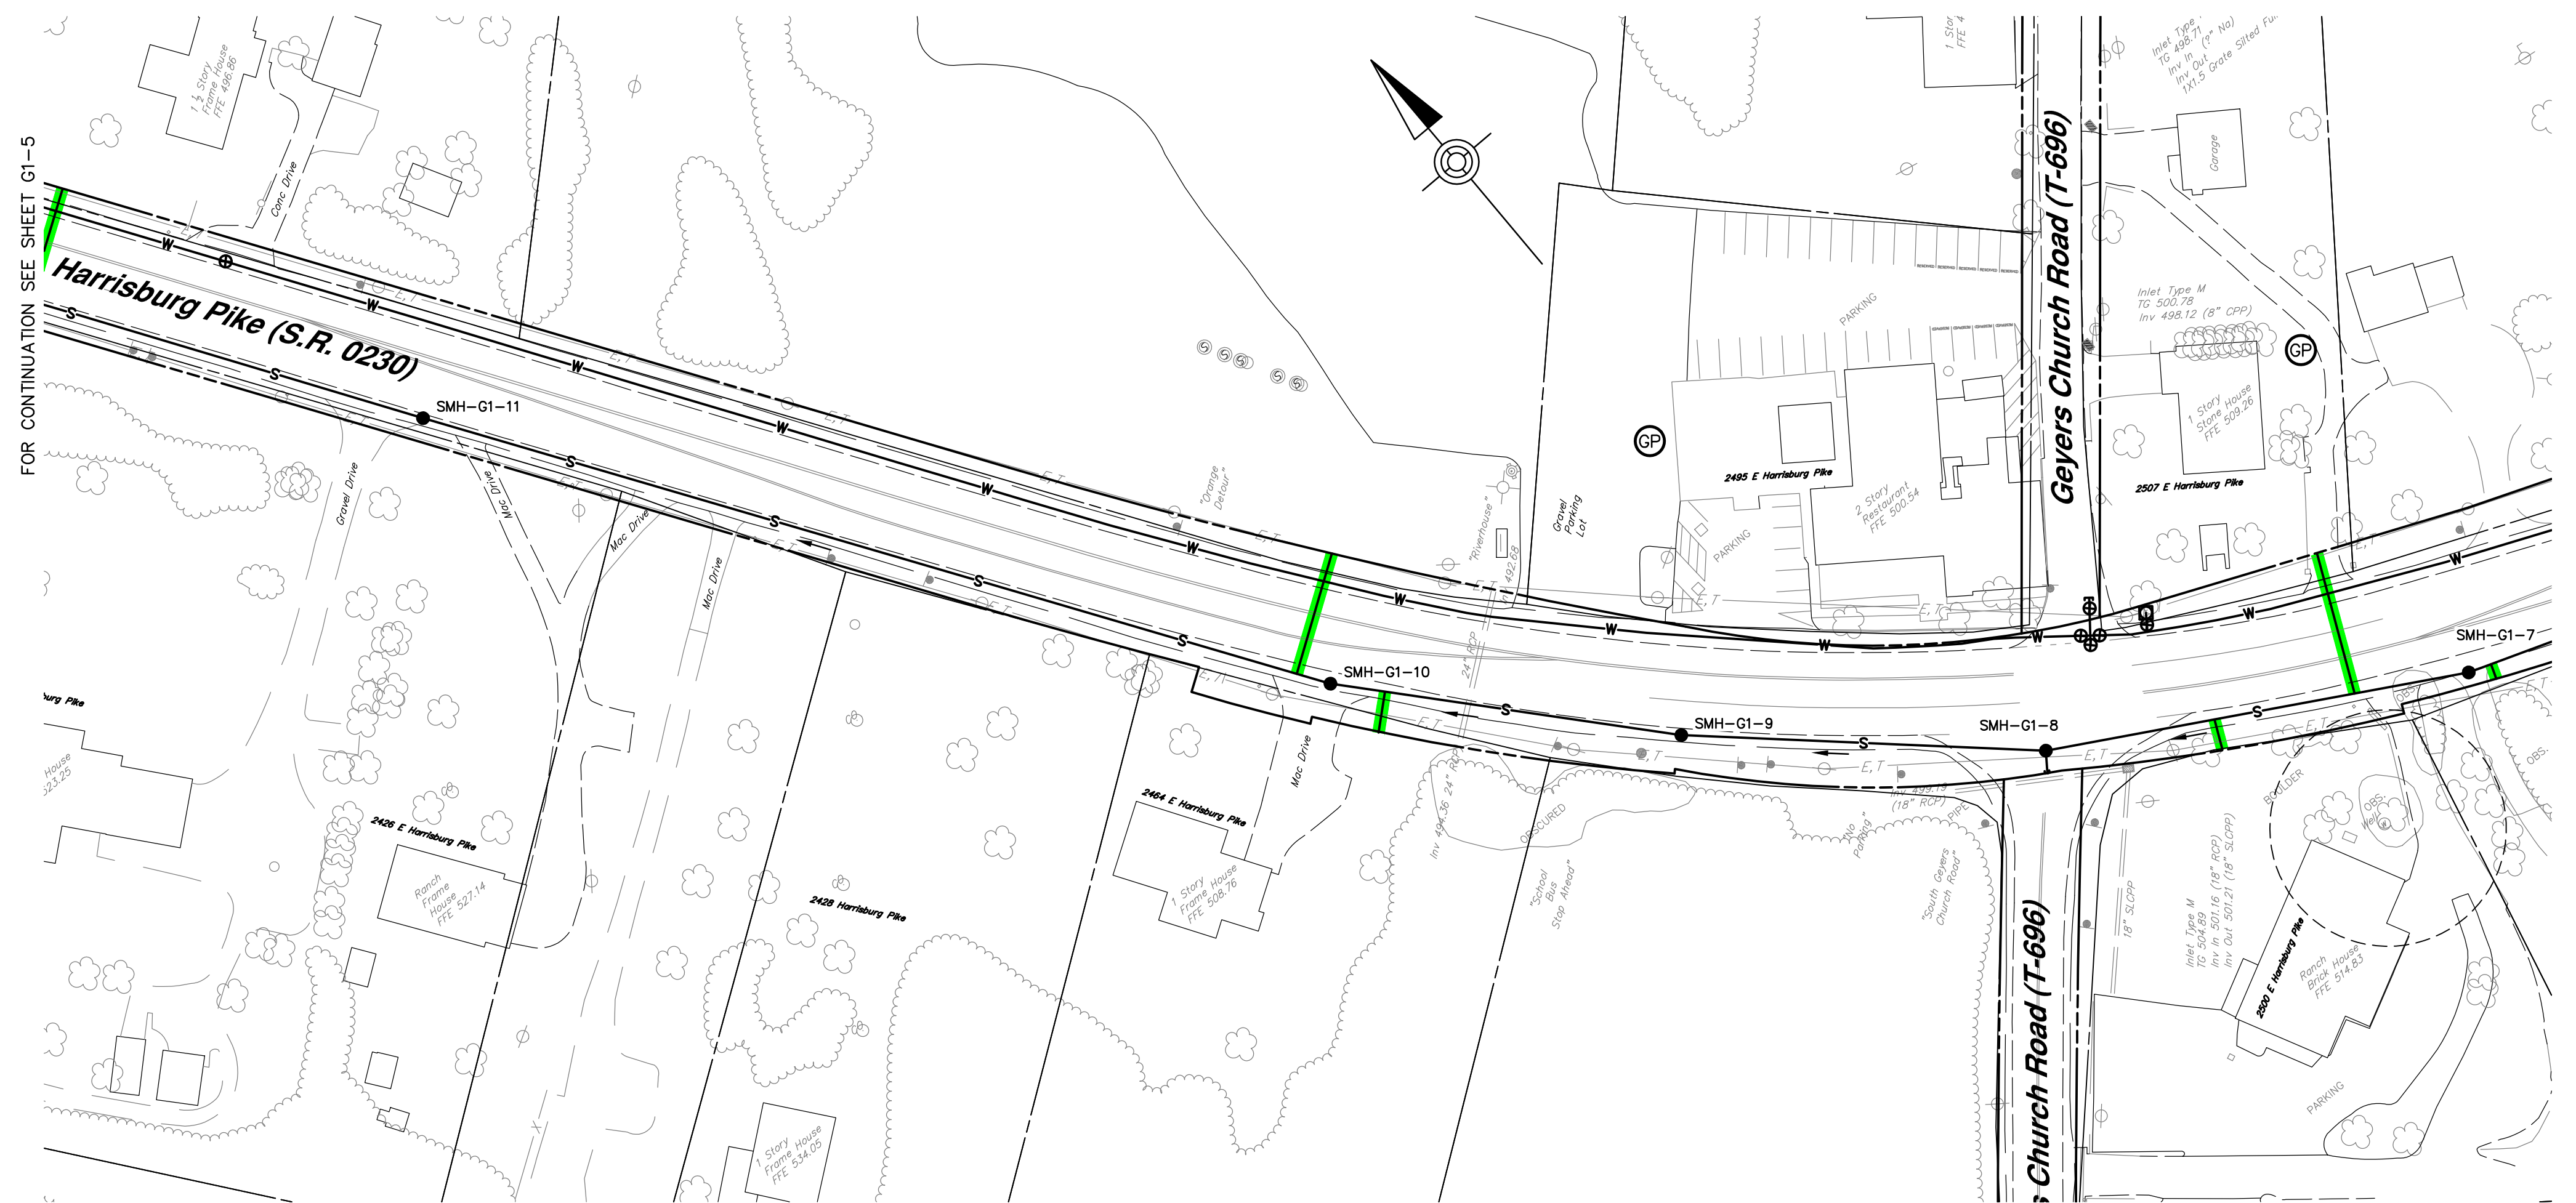


FOR CONTINUATION SEE SHEET G1-5

FOR CONTINUATION SEE SHEET G1-7


**SANITARY SEWER PLAN**

SCALE: 1" = 50'


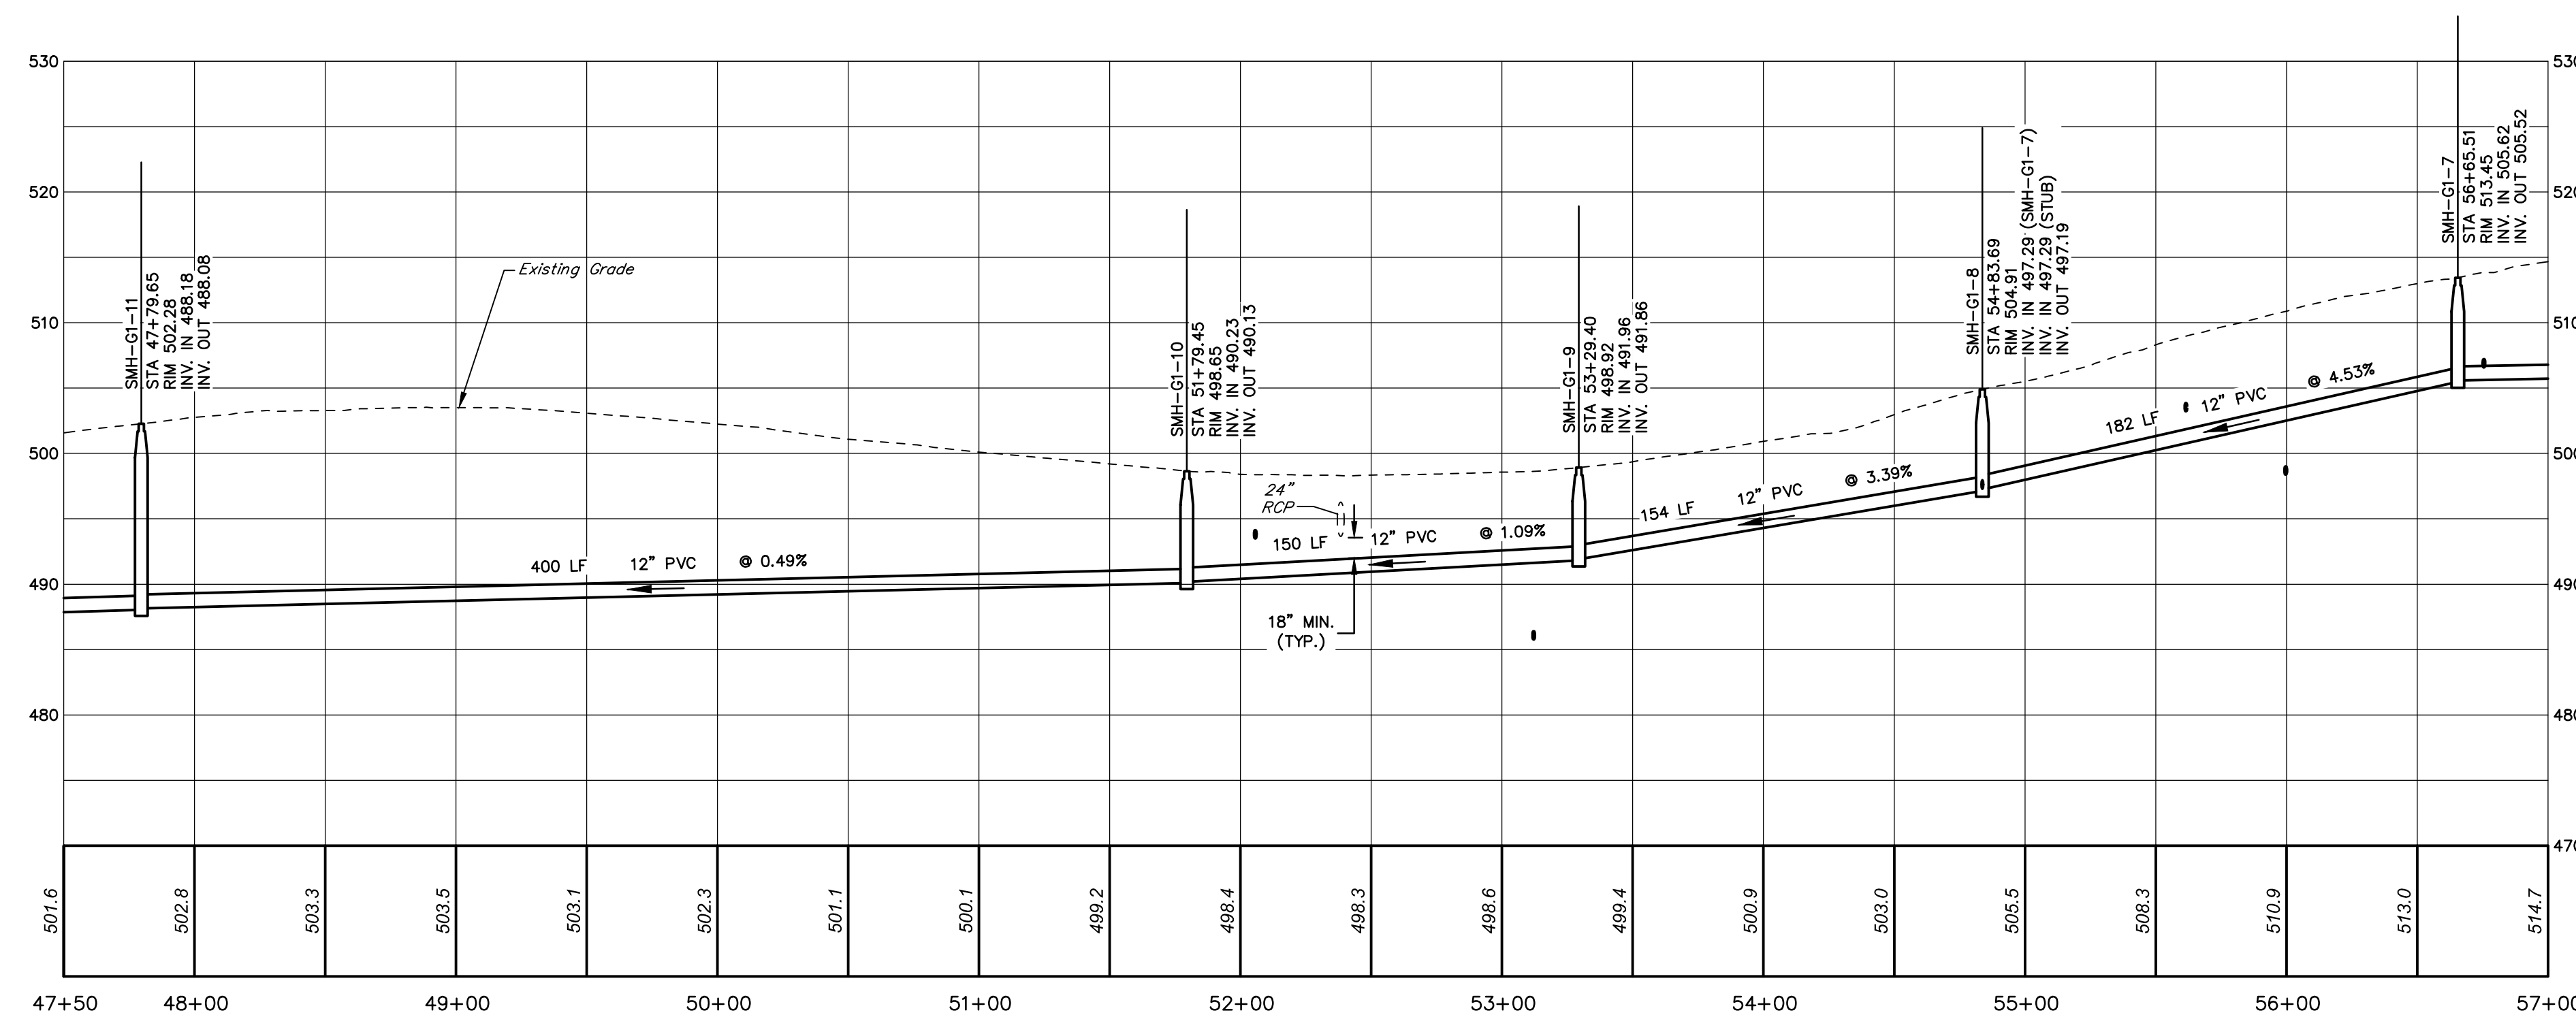


**PROFILE**

HORIZ. SCALE: 1" = 50'  
VERT. SCALE: 1" = 10'

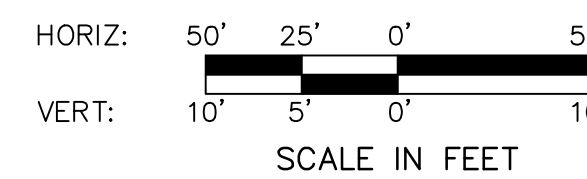

NO.	REVISION	DATE	BY

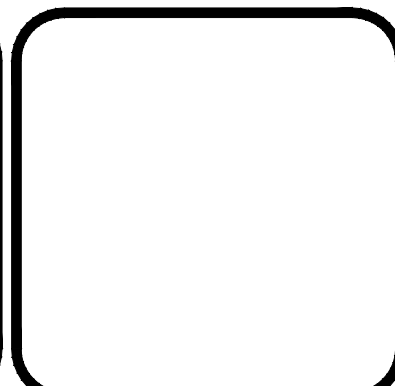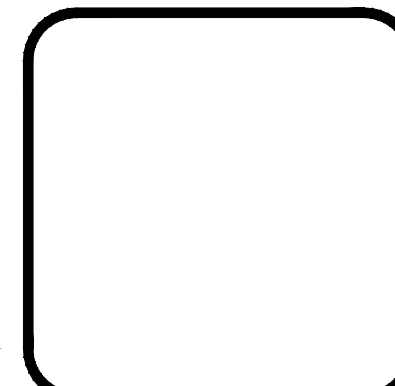

**HRG**  
Herbert, Rowland & Grubic, Inc.  
Engineering & Related Services  
AN EMPLOYEE-OWNED COMPANY

369 East Park Drive  
Harrisburg, PA 17111  
(717) 564-1121  
Fax (717) 564-1158  
hrg@hrg-inc.com  
www.hrg-inc.com

**CORE5 INDUSTRIAL PARTNERS**  
1250 N. MOUNTAIN ROAD  
HARRISBURG, PA 17112  
(717) 461-7730


**SANITARY SEWER PLAN AND PROFILE**  
LYTLE PUMP STATION  
FOR LONDONDERRY TOWNSHIP SANITARY  
SEWER AND WATER EXTENSION PHASE I  
LONDONDERRY TOWNSHIP DAUPHIN COUNTY PENNSYLVANIA

PROJ. MGR. - JTF
DESIGN - HCK
CADD - KRB
CHECKED - MDC
SCALE - AS NOTED
DATE - SEPT. 2020


DRAWING NO.  
**G1-6**  
SHEET NO.  
**36 OF 125**  
PROJECT 008048.0428

FOR CONTINUATION SEE SHEET G1-6

FOR CONTINUATION SEE SHEET G1-8

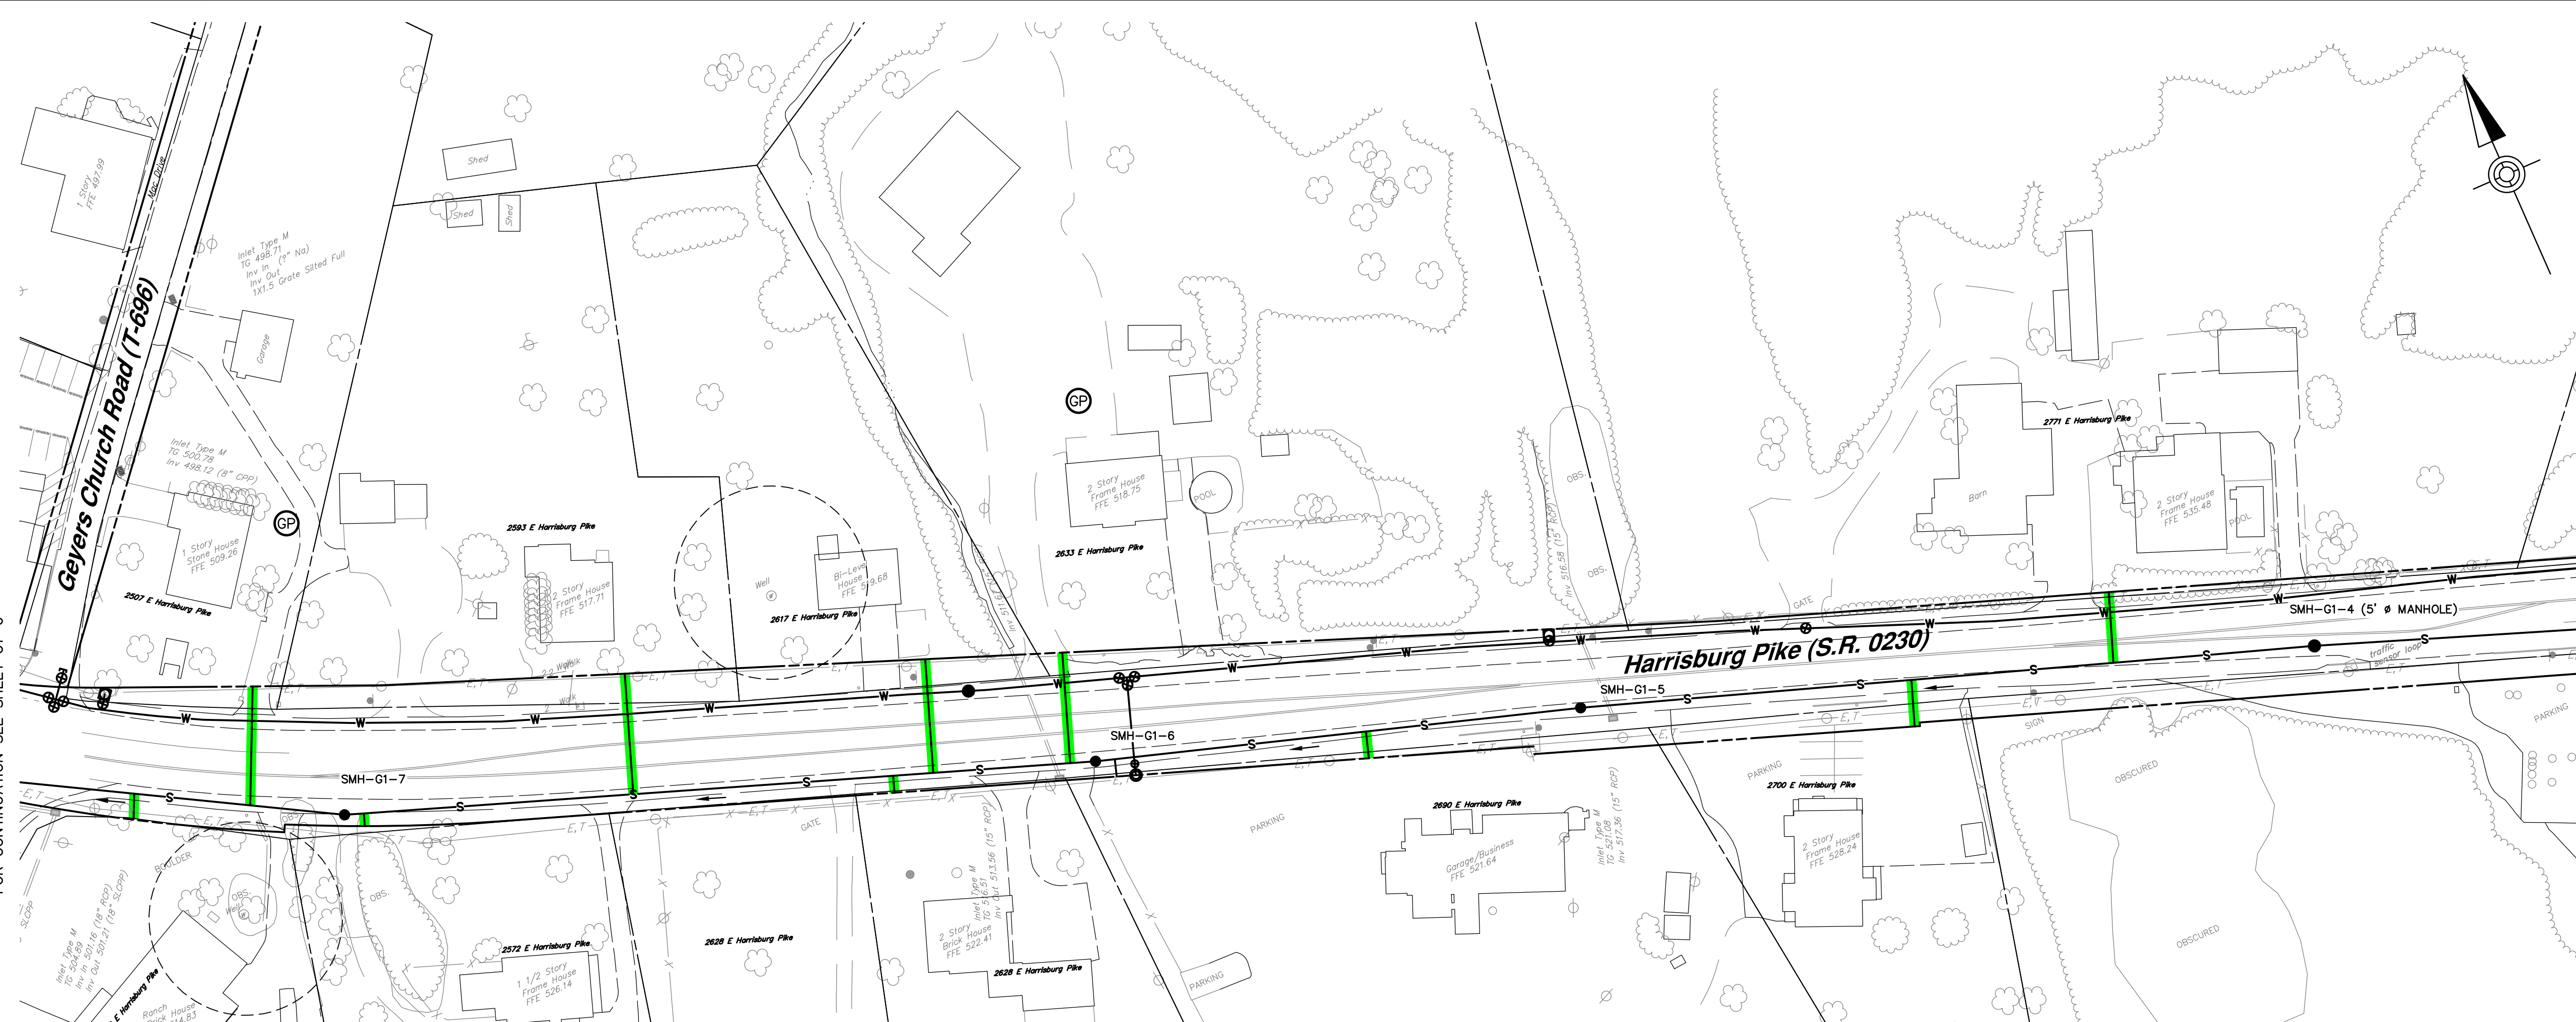


**SANITARY SEWER PLAN**  
SCALE: 1" = 50'

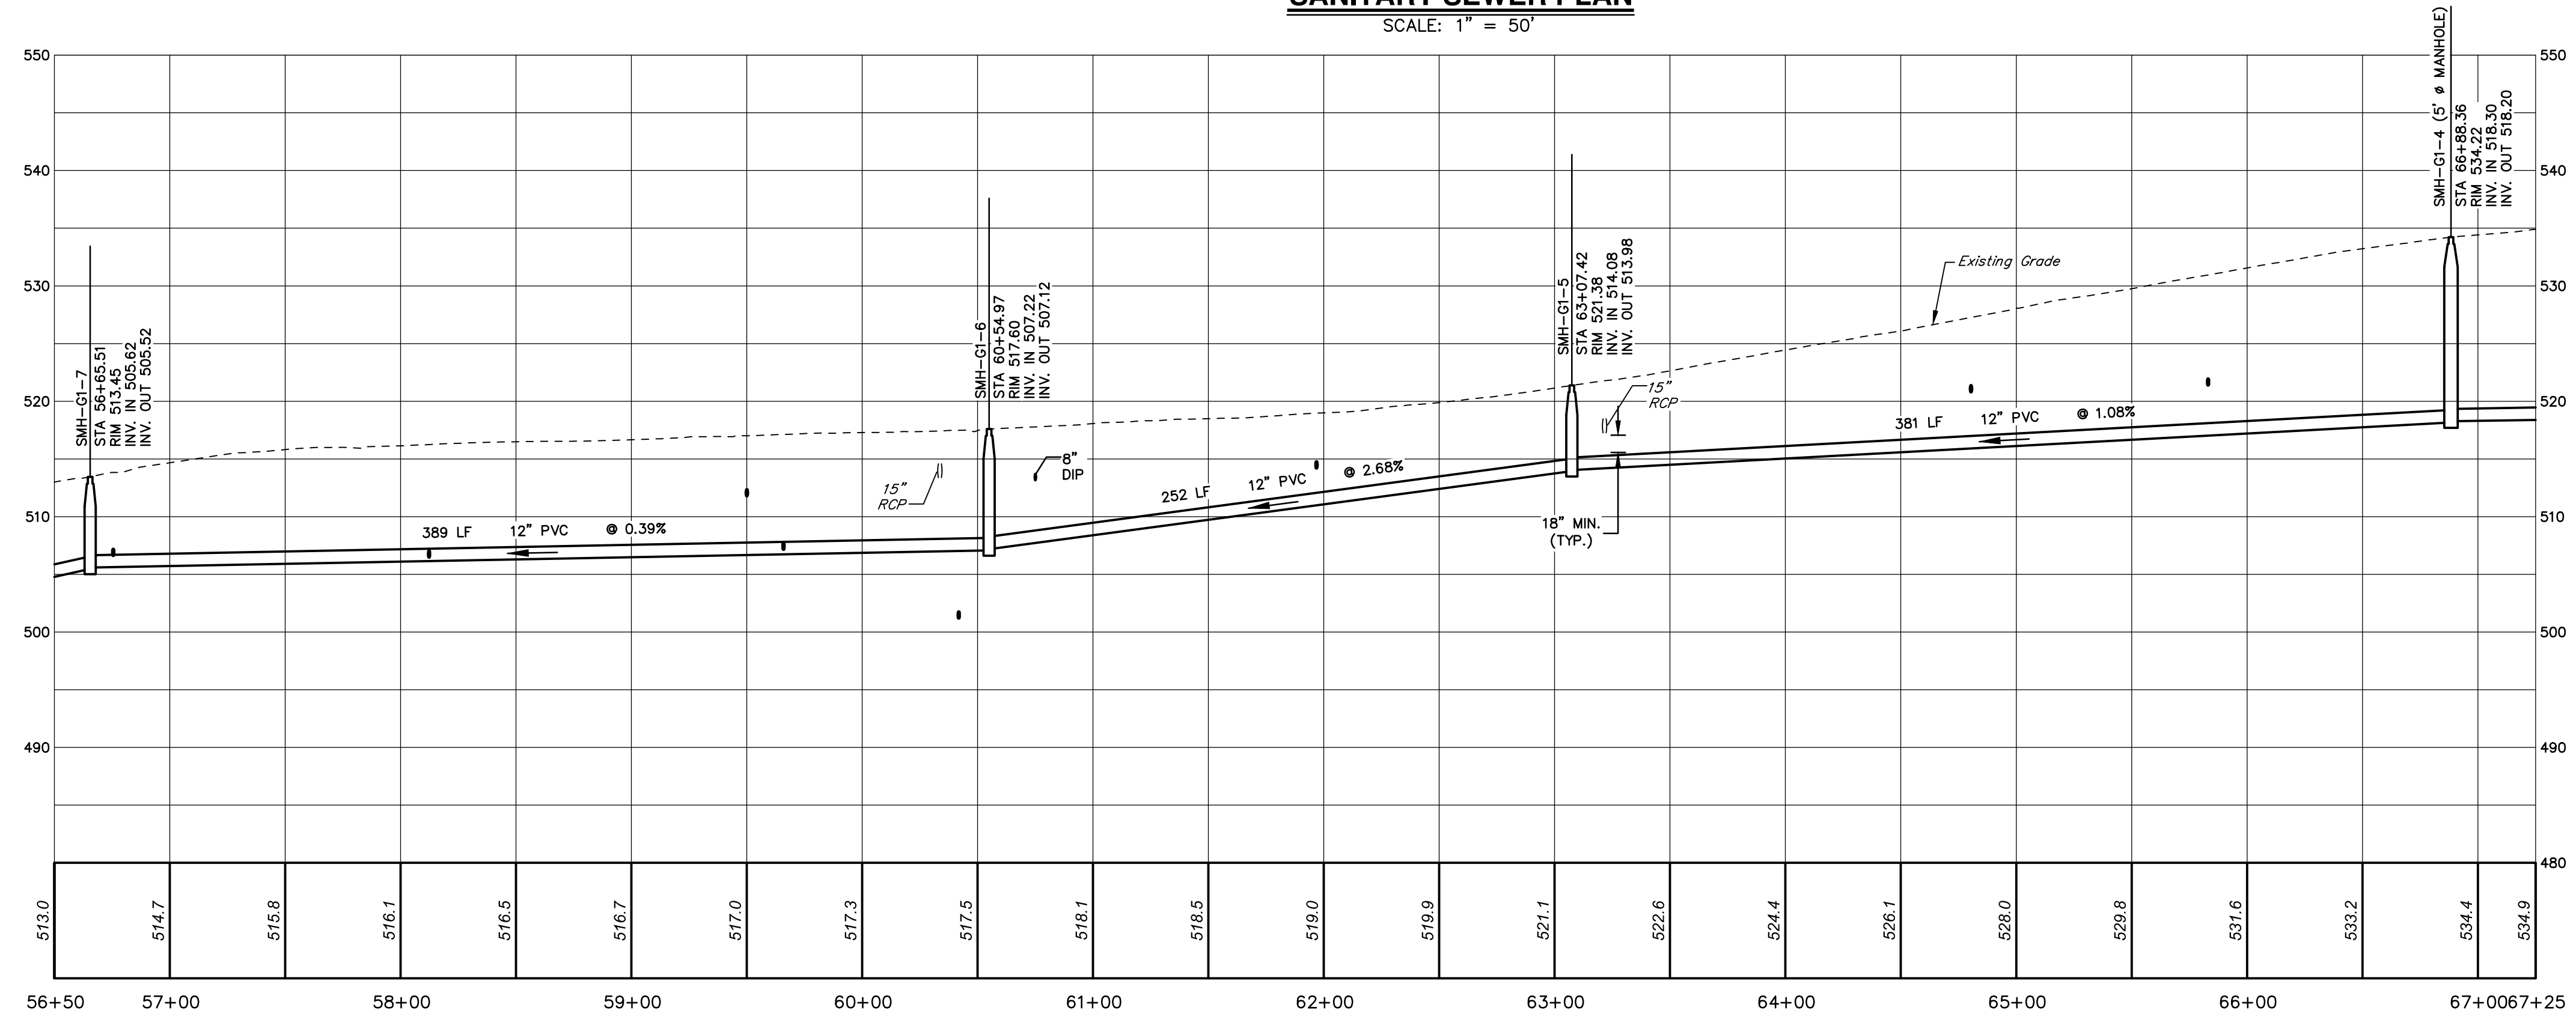


**PROFILE**  
HORIZ. SCALE: 1" = 50'  
VERT. SCALE: 1" = 10'

**NOTES:**  
1. MAINTAIN SIGNAL EQUIPMENT OR REPLACE IN KIND AS NECESSARY TO RESTORE EXISTING CONDITION.

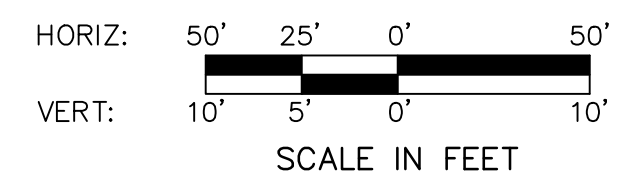

NO.	REVISION	DATE	BY

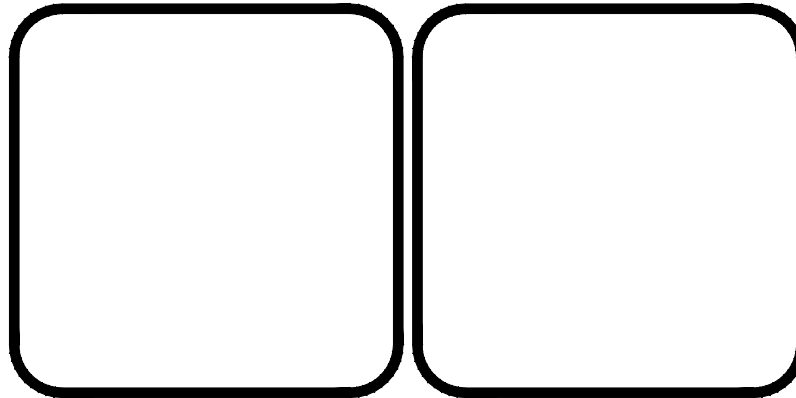

**HRG**  
Herbert, Rowland & Grubic, Inc.  
Engineering & Related Services  
AN EMPLOYEE-OWNED COMPANY

369 East Park Drive  
Harrisburg, PA 17111  
(717) 564-1121  
Fax (717) 564-1158  
hrg@hrg-inc.com  
www.hrg-inc.com

**CORE5 INDUSTRIAL PARTNERS**  
1250 N. MOUNTAIN ROAD  
HARRISBURG, PA 17112  
(717) 461-7730

**SANITARY SEWER PLAN AND PROFILE**  
LYTLE PUMP STATION  
FOR LONDONDERRY TOWNSHIP SANITARY  
SEWER AND WATER EXTENSION PHASE I  
LONDONDERRY TOWNSHIP DAUPHIN COUNTY PENNSYLVANIA


PROJ. MGR. - JTF
DESIGN - HCK
CADD - KRB
CHECKED - MDC
SCALE - AS NOTED
DATE - SEPT. 2020

DRAWING NO.  
**G1-7**  
SHEET NO.  
**37 OF 125**  
PROJECT 008048.0428




FOR CONTINUATION SEE SHEET G1-7

FOR CONTINUATION SEE SHEET FM1-7

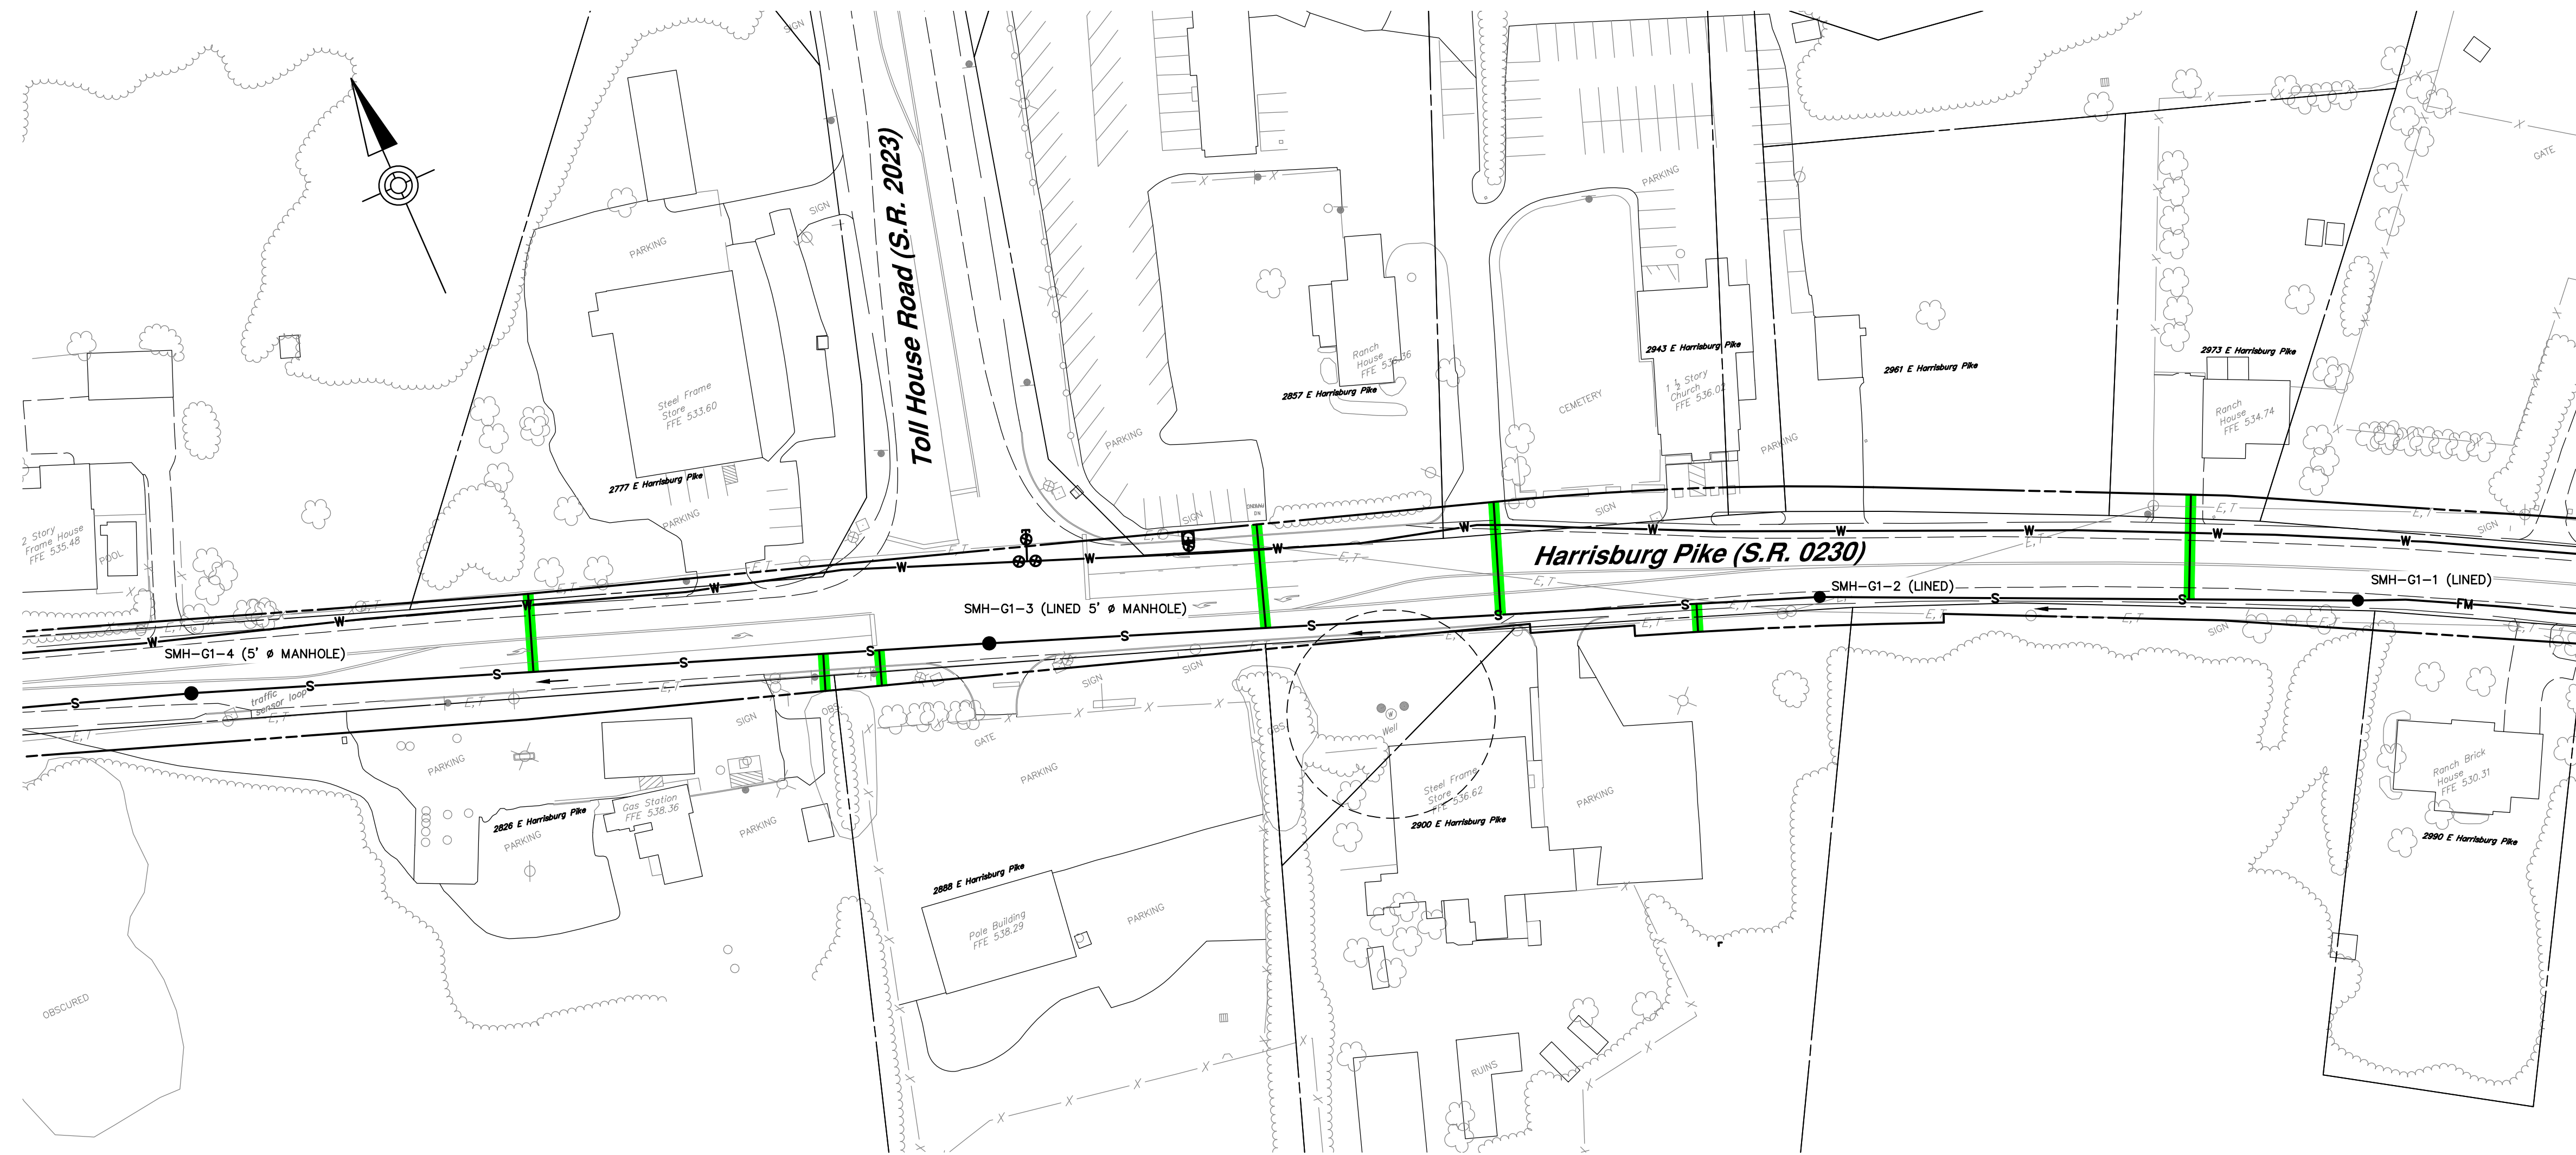


**SANITARY SEWER PLAN**  
SCALE: 1" = 50'


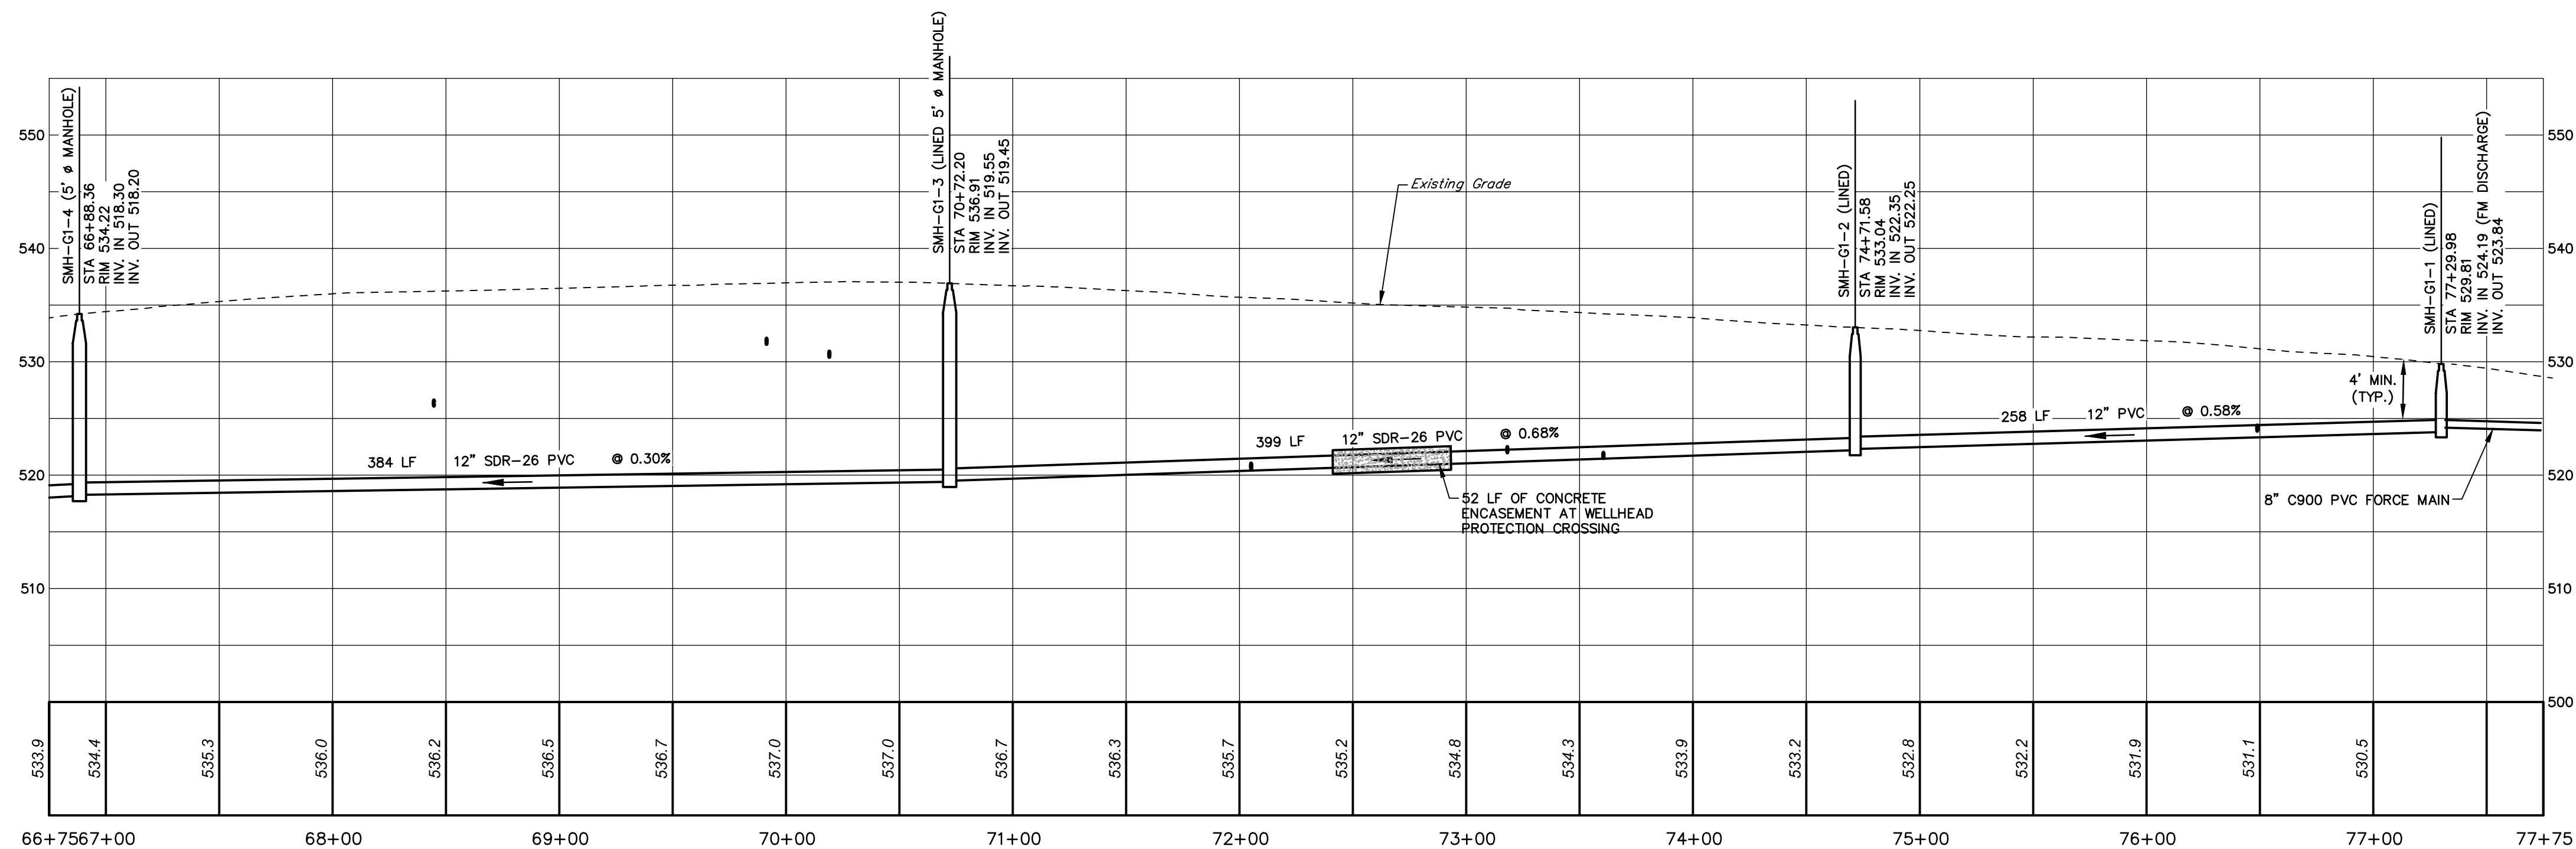


**PROFILE**  
HORIZ. SCALE: 1" = 50'  
VERT. SCALE: 1" = 10'

- NOTES:**
1. MAINTAIN SIGNAL EQUIPMENT OR REPLACE IN KIND AS NECESSARY TO RESTORE EXISTING CONDITION.

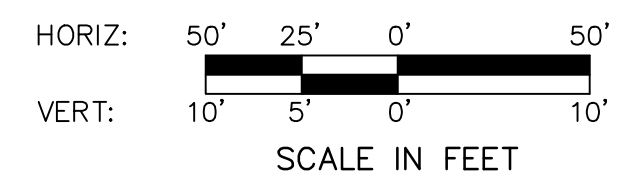

NO.	REVISION	DATE	BY

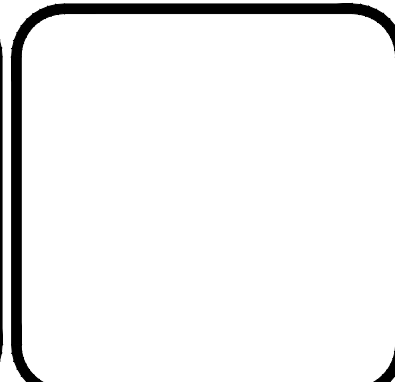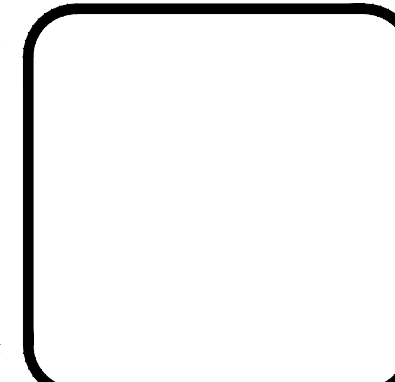

**HRG**  
Herbert, Rowland & Grubic, Inc.  
Engineering & Related Services  
AN EMPLOYEE-OWNED COMPANY

369 East Park Drive  
Harrisburg, PA 17111  
(717) 564-1121  
Fax (717) 564-1158  
hr@hr-g-inc.com  
www.hr-g-inc.com

**CORE5 INDUSTRIAL PARTNERS**  
1250 N. MOUNTAIN ROAD  
HARRISBURG, PA 17112  
(717) 461-7730

**SANITARY SEWER PLAN AND PROFILE**  
**LYTLE PUMP STATION**  
**FOR LONDONDERRY TOWNSHIP SANITARY**  
**SEWER AND WATER EXTENSION PHASE I**

LONDONDERRY TOWNSHIP    DAUPHIN COUNTY    PENNSYLVANIA


PROJ. MGR. - JTF
DESIGN - HCK
CADD - KRB
CHECKED - MDC
SCALE - AS NOTED
DATE - SEPT. 2020

DRAWING NO.  
**G1-8**

SHEET NO.  
**38 OF 125**

PROJECT 008048.0428

FOR CONTINUATION SEE SHEET G2-1.1

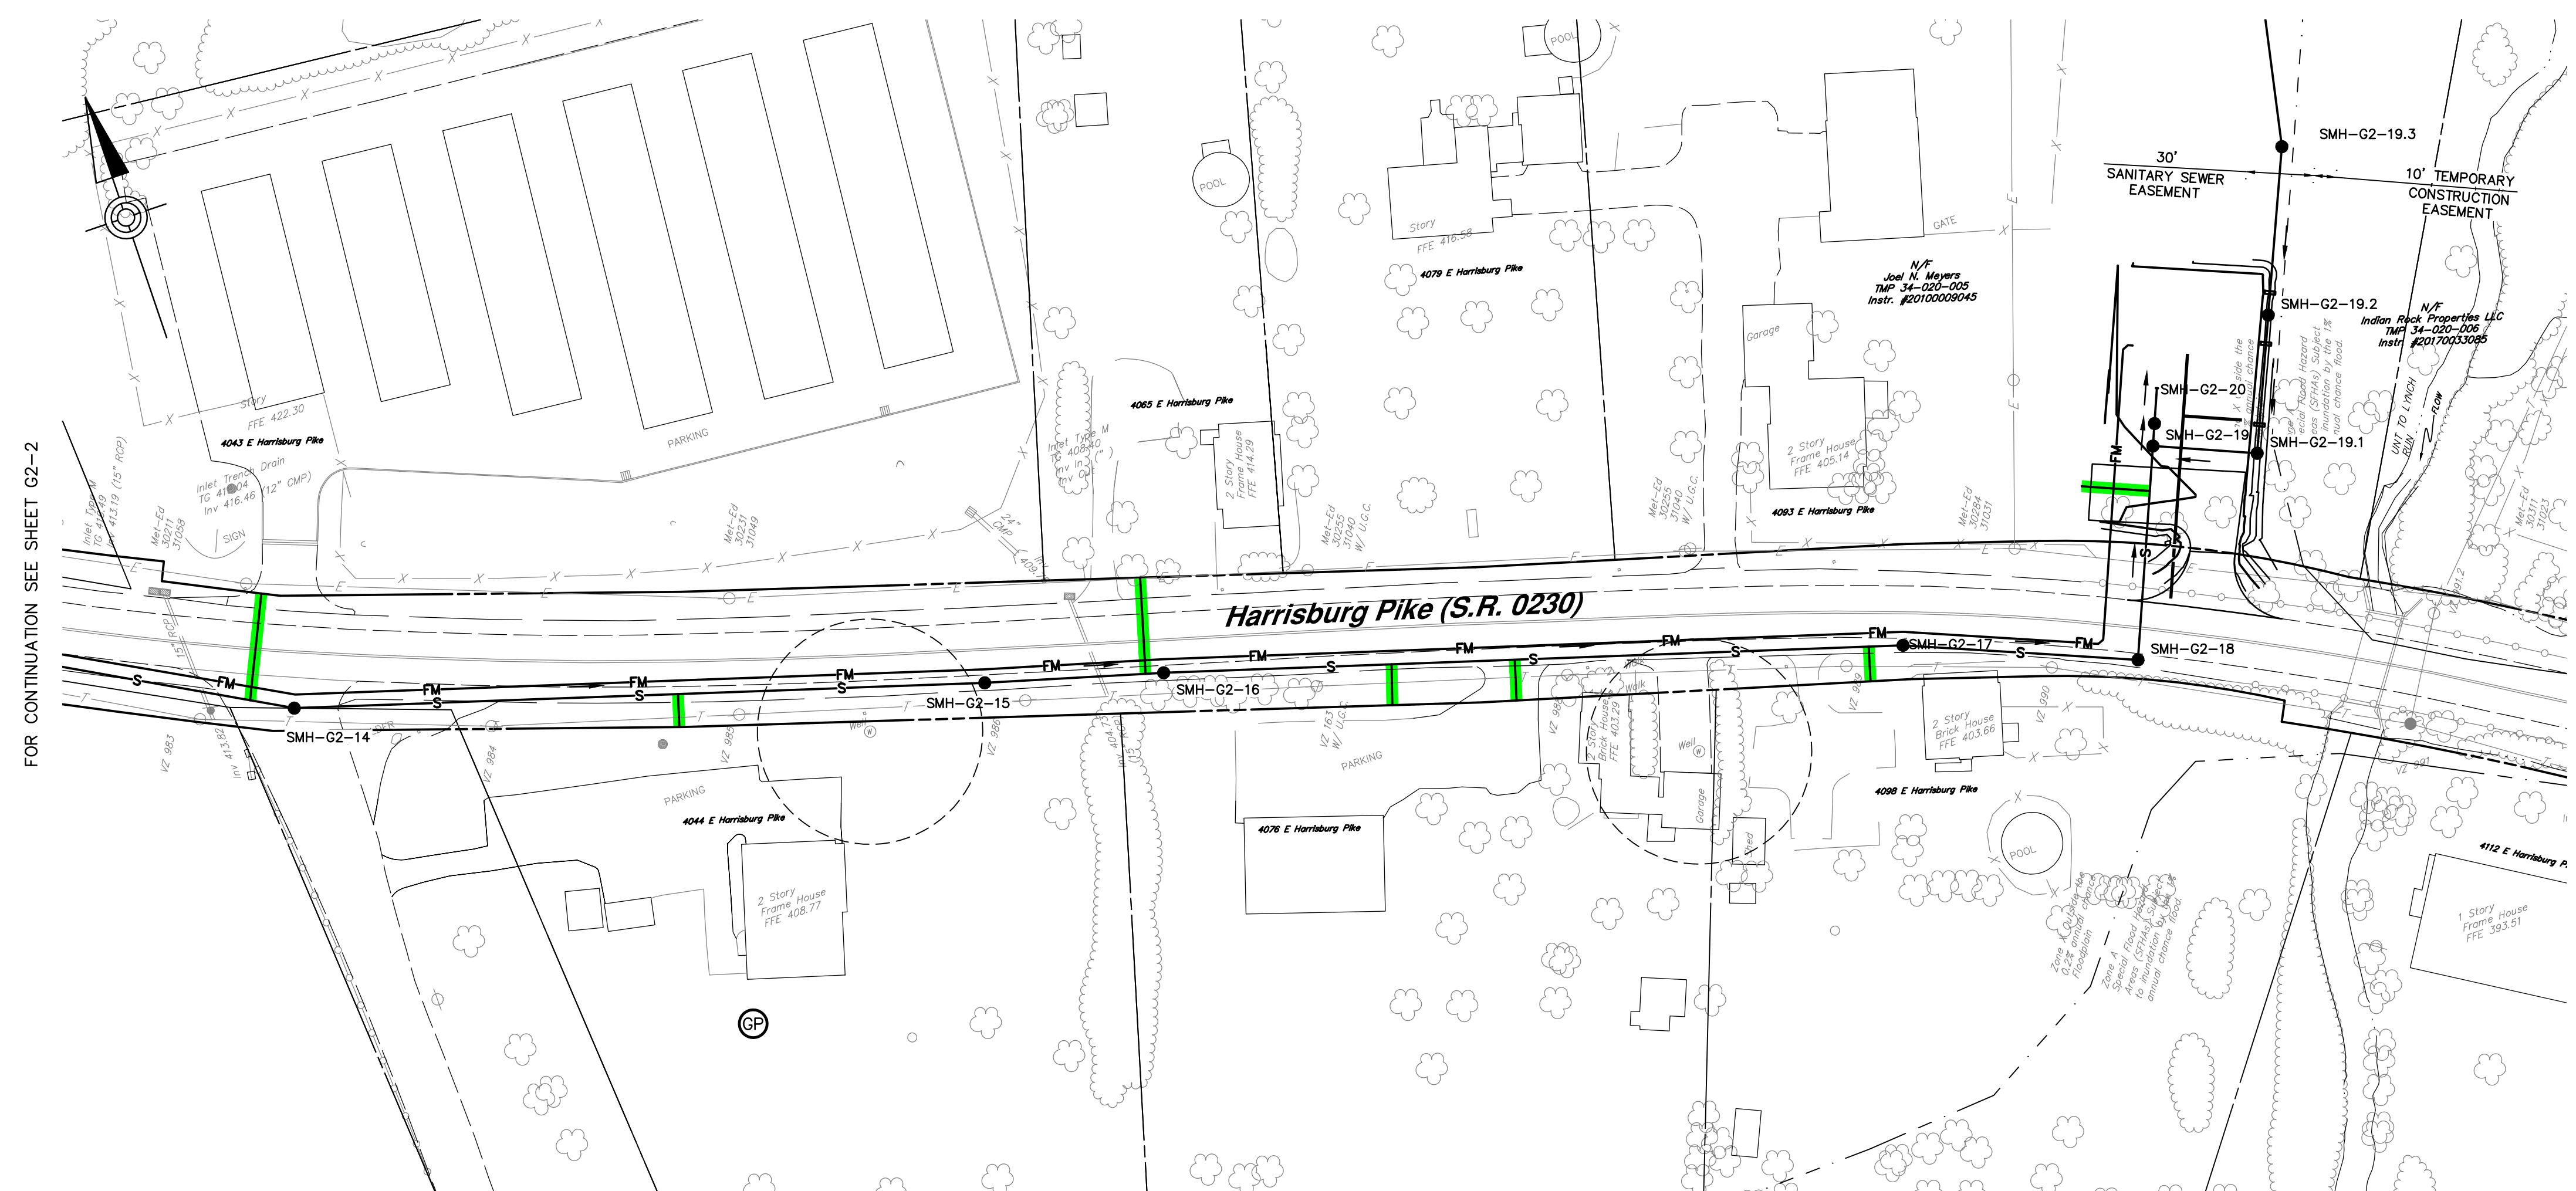


FOR CONTINUATION SEE SHEET G2-2

FOR CONTINUATION SEE SHEET G3-1

**SANITARY SEWER PLAN**


SCALE: 1" = 50'

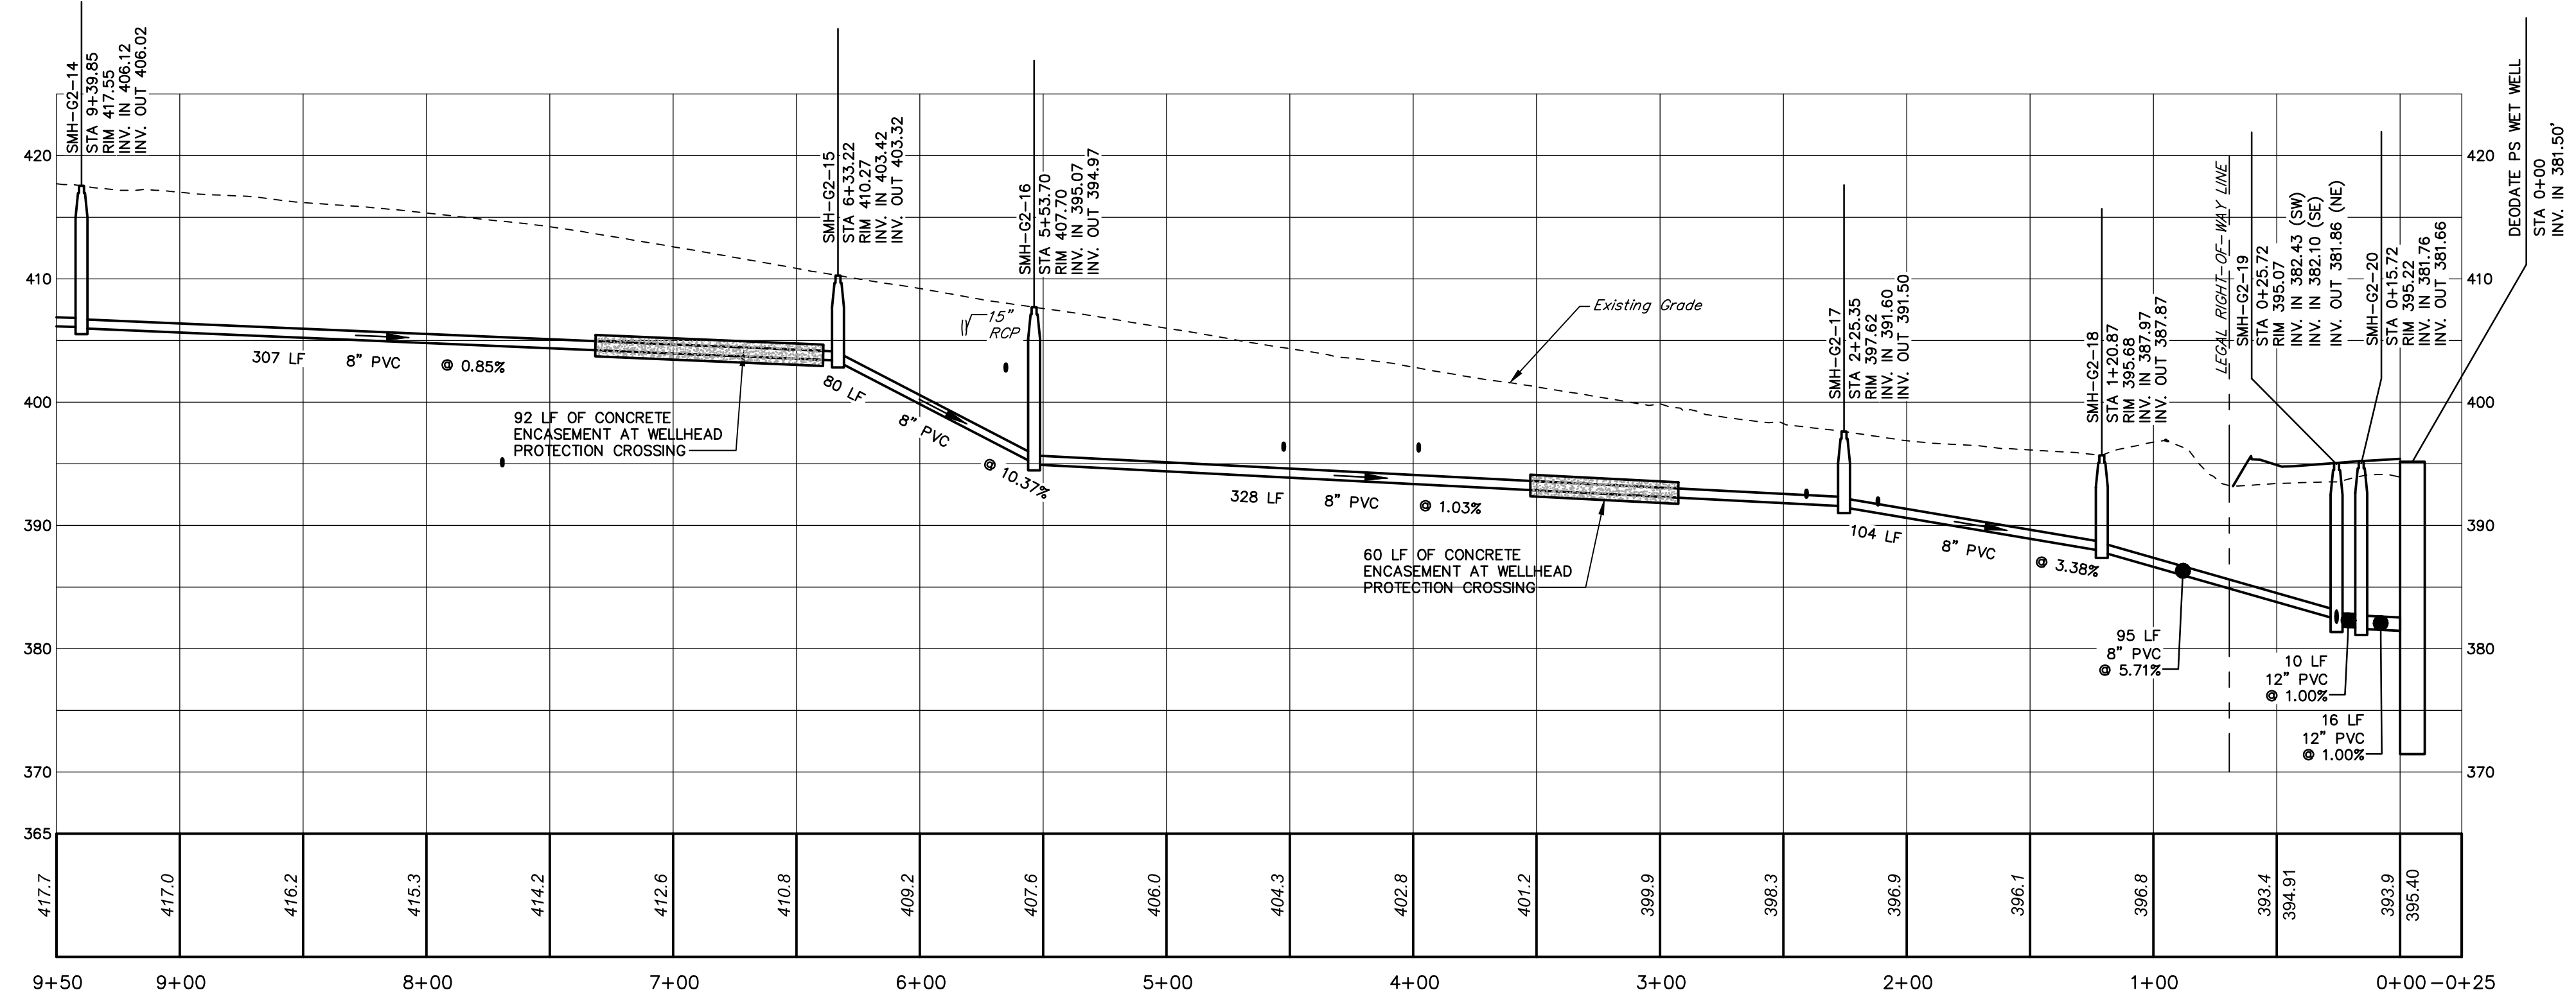

**PROFILE**  
 HORIZ. SCALE: 1" = 50'  
 VERT. SCALE: 1" = 10'

HORIZ: 50' 25' 0' 50'  
 VERT: 10' 5' 0' 10'  
 SCALE IN FEET

NO.	REVISION	DATE	BY

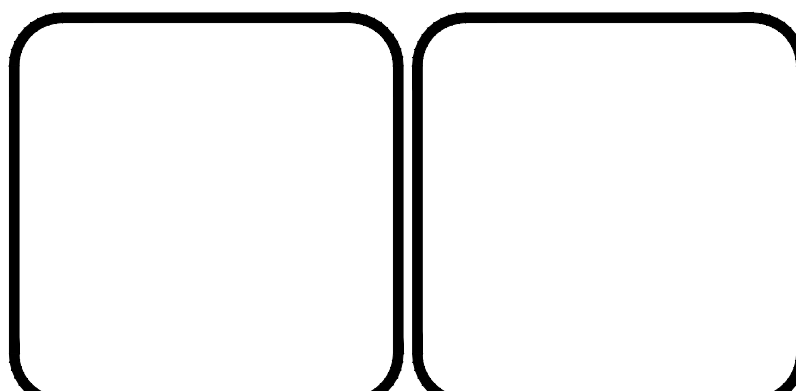

**HRG**  
 Herbert, Rowland & Grubic, Inc.  
 Engineering & Related Services  
 AN EMPLOYEE-OWNED COMPANY

369 East Park Drive  
 Harrisburg, PA 17111  
 (717) 564-1121  
 Fax (717) 564-1158  
 hrg@hrg-inc.com  
 www.hrg-inc.com

**CORE5 INDUSTRIAL PARTNERS**  
 1250 N. MOUNTAIN ROAD  
 HARRISBURG, PA 17112  
 (717) 461-7730

**SANITARY SEWER PLAN AND PROFILE**  
**DEODATE PUMP STATION**  
**FOR LONDONDERRY TOWNSHIP SANITARY**  
**SEWER AND WATER EXTENSION PHASE I**



LONDONDERRY TOWNSHIP    DAUPHIN COUNTY    PENNSYLVANIA

PROJ. MGR. - JTF
DESIGN - HCK
CADD - KRB
CHECKED - MDC
SCALE - AS NOTED
DATE - SEPT. 2020


DRAWING NO.  
**G2-1**

SHEET NO.  
**39 OF 125**


PROJECT 008048.0428

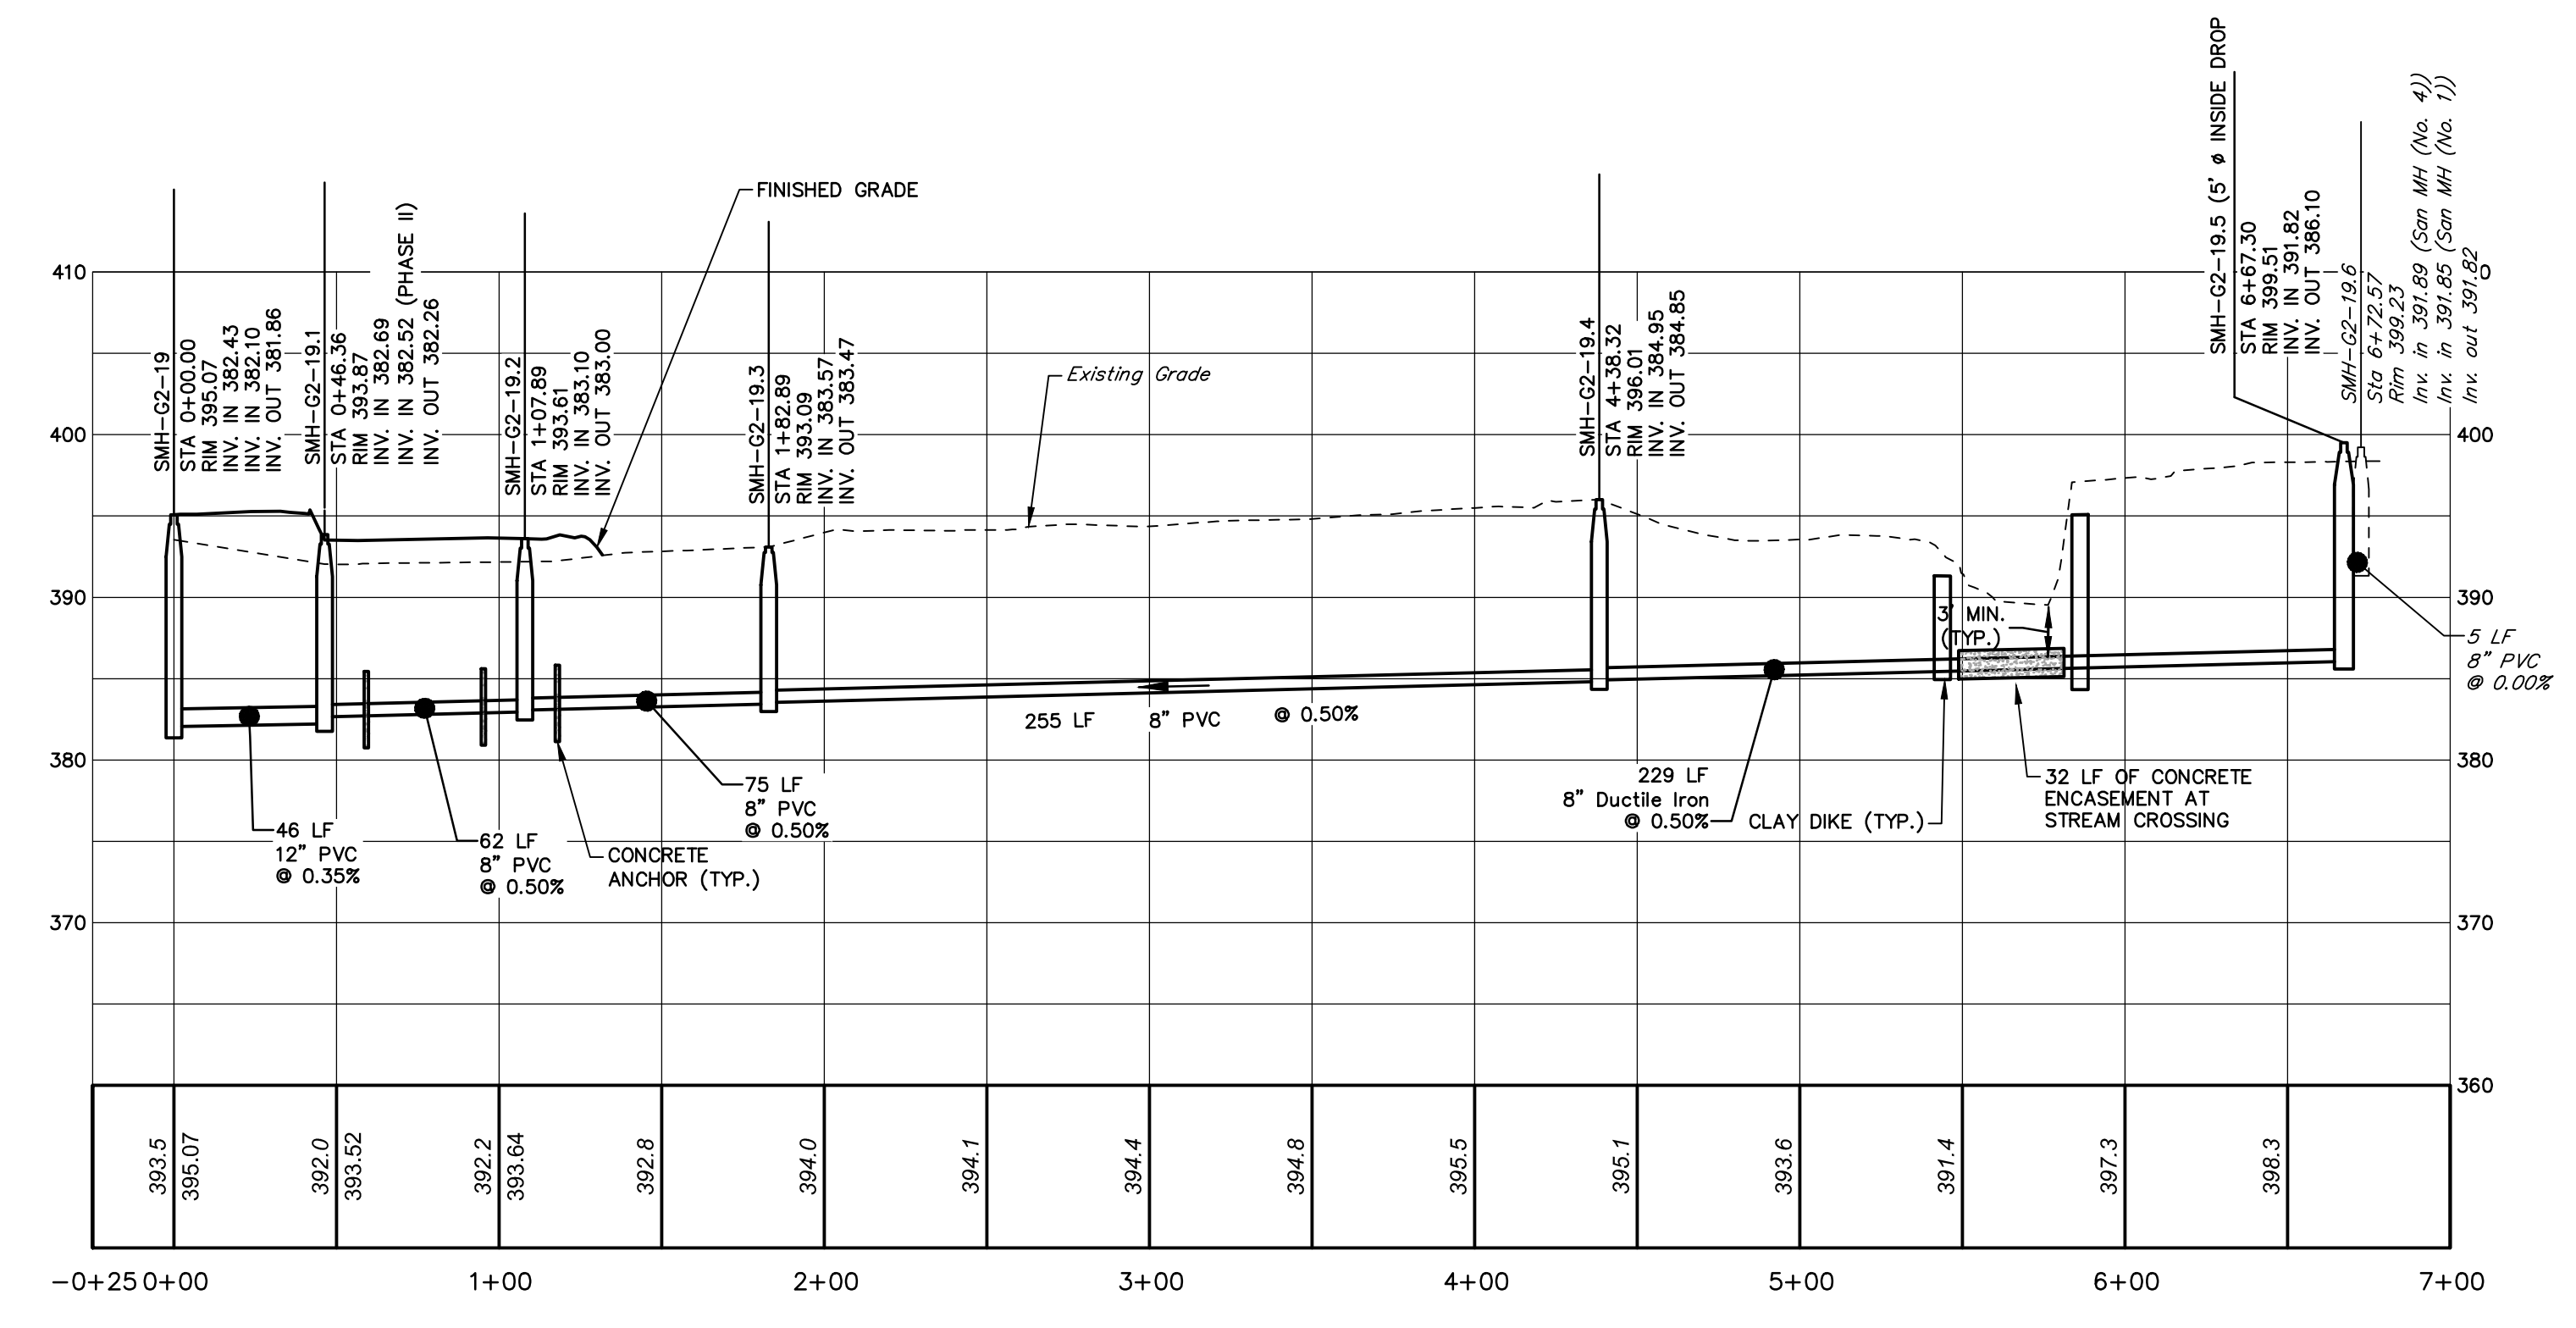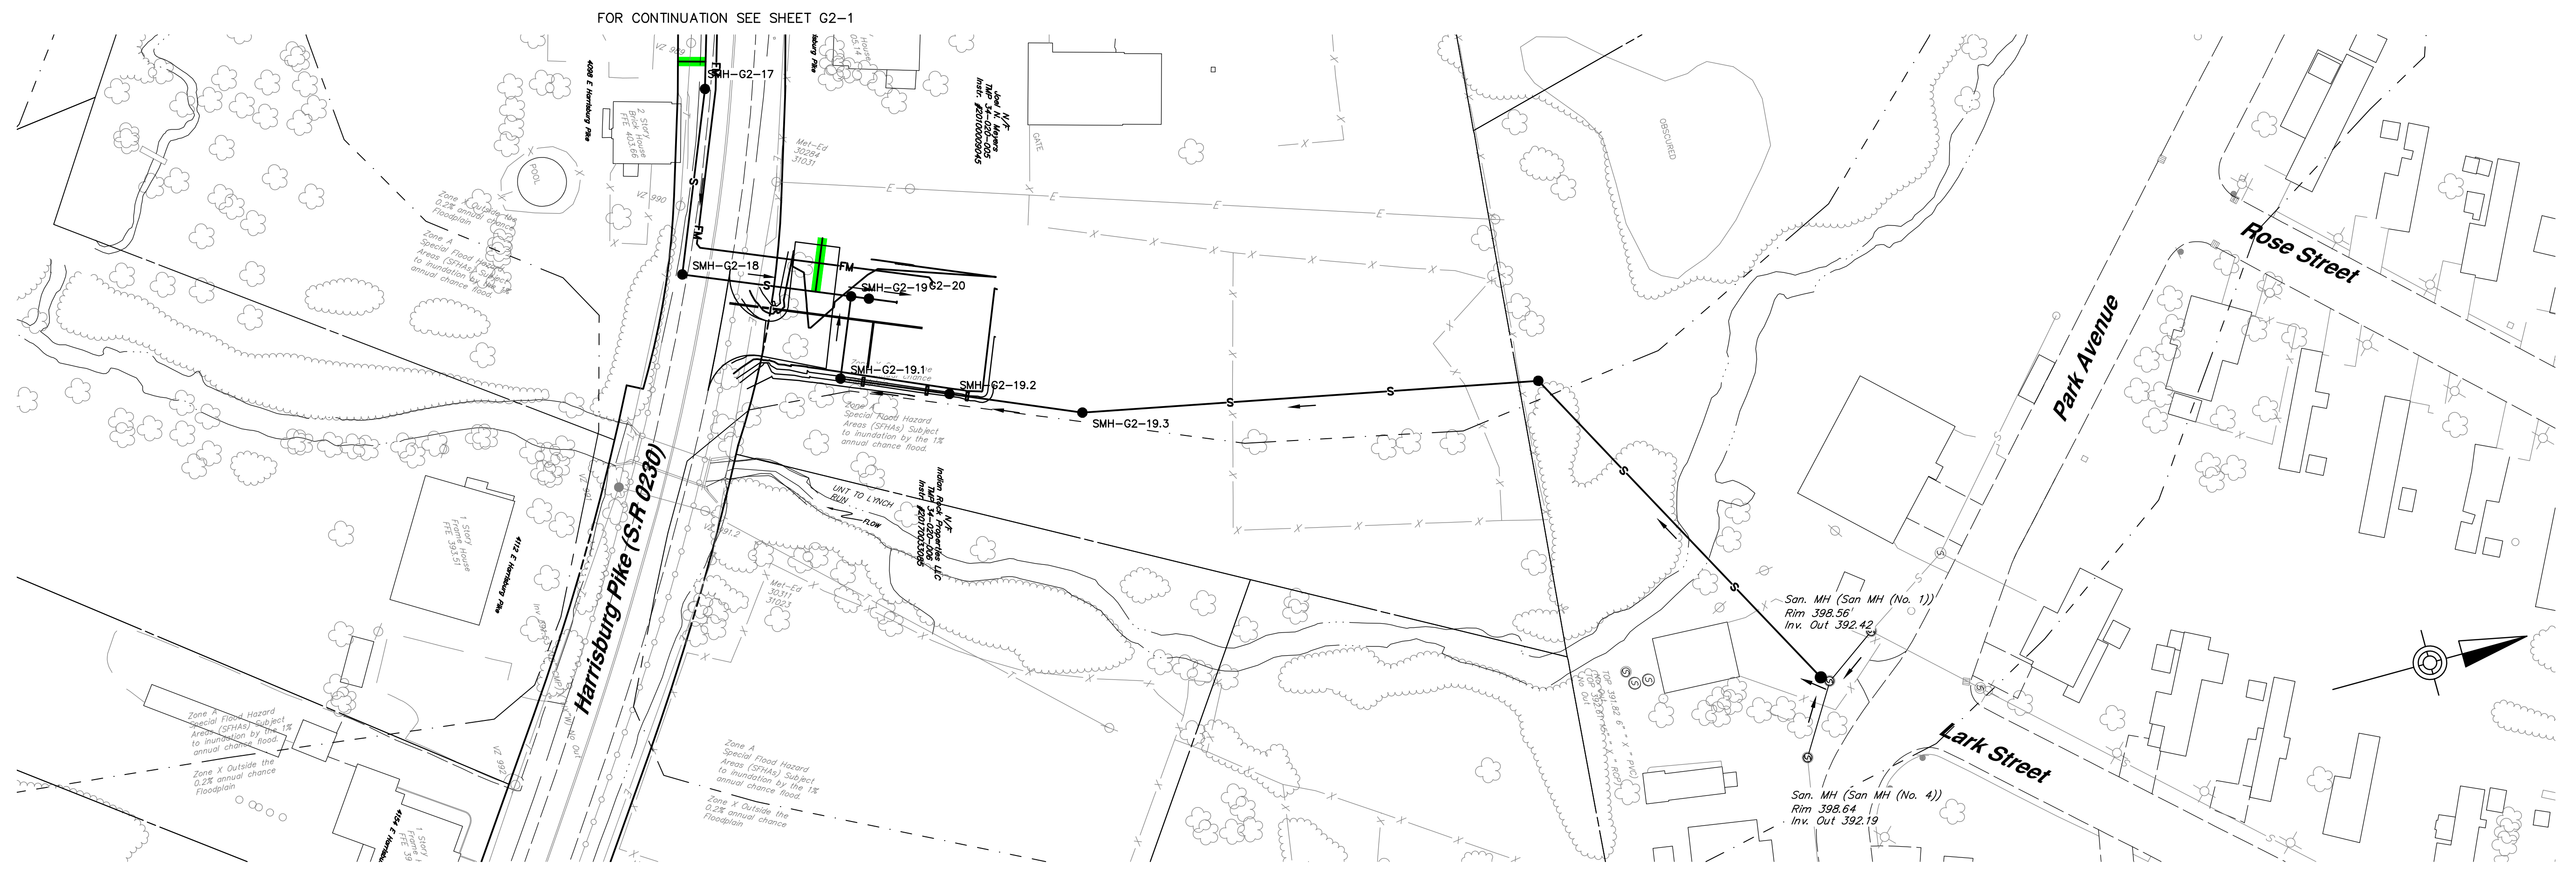

**PROFILE**  
HORIZ. SCALE: 1" = 50'  
VERT. SCALE: 1" = 10'

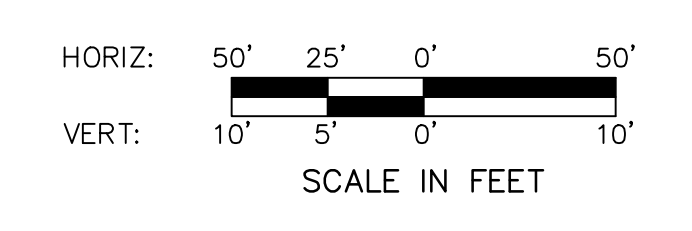

NO.	REVISION	DATE	BY

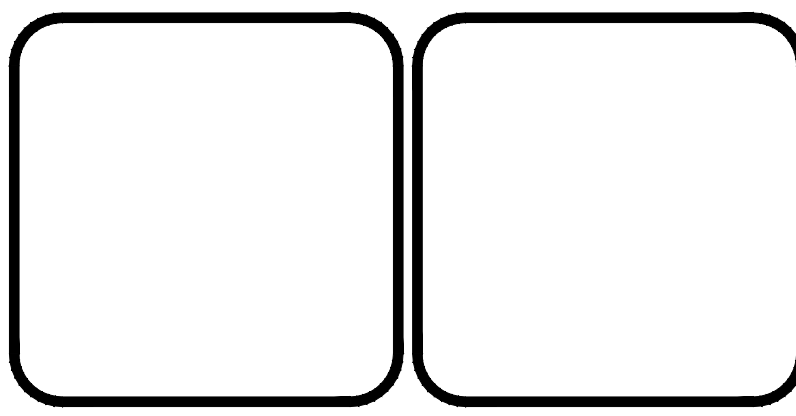

**HRG**  
Herbert, Rowland & Grubic, Inc.  
Engineering & Related Services  
AN EMPLOYEE-OWNED COMPANY

369 East Park Drive  
Harrisburg, PA 17111  
(717) 564-1121  
Fax (717) 564-1158  
hr@hr-g-inc.com  
www.hr-g-inc.com

**CORE5 INDUSTRIAL PARTNERS**  
1250 N. MOUNTAIN ROAD  
HARRISBURG, PA 17112  
(717) 461-7730


**SANITARY SEWER PLAN AND PROFILE**  
**DEODATE PUMP STATION**  
**FOR LONDONDERRY TOWNSHIP SANITARY**  
**SEWER AND WATER EXTENSION PHASE I**

LONDONDERRY TOWNSHIP    DAUPHIN COUNTY    PENNSYLVANIA

PROJ. MGR. - JTF
DESIGN - HCK
CADD - KRB
CHECKED - MDC
SCALE - AS NOTED
DATE - SEPT. 2020

DRAWING NO.  
**G2-1.1**  
SHEET NO.  
**40 OF 125**  
PROJECT 008048.0428


File name: P:\008048\008048\_0428\2020\10\14\10:45:11\HRG\G2-1.1.dwg    User: JTF    Date: 2021-11-16 10:45:11

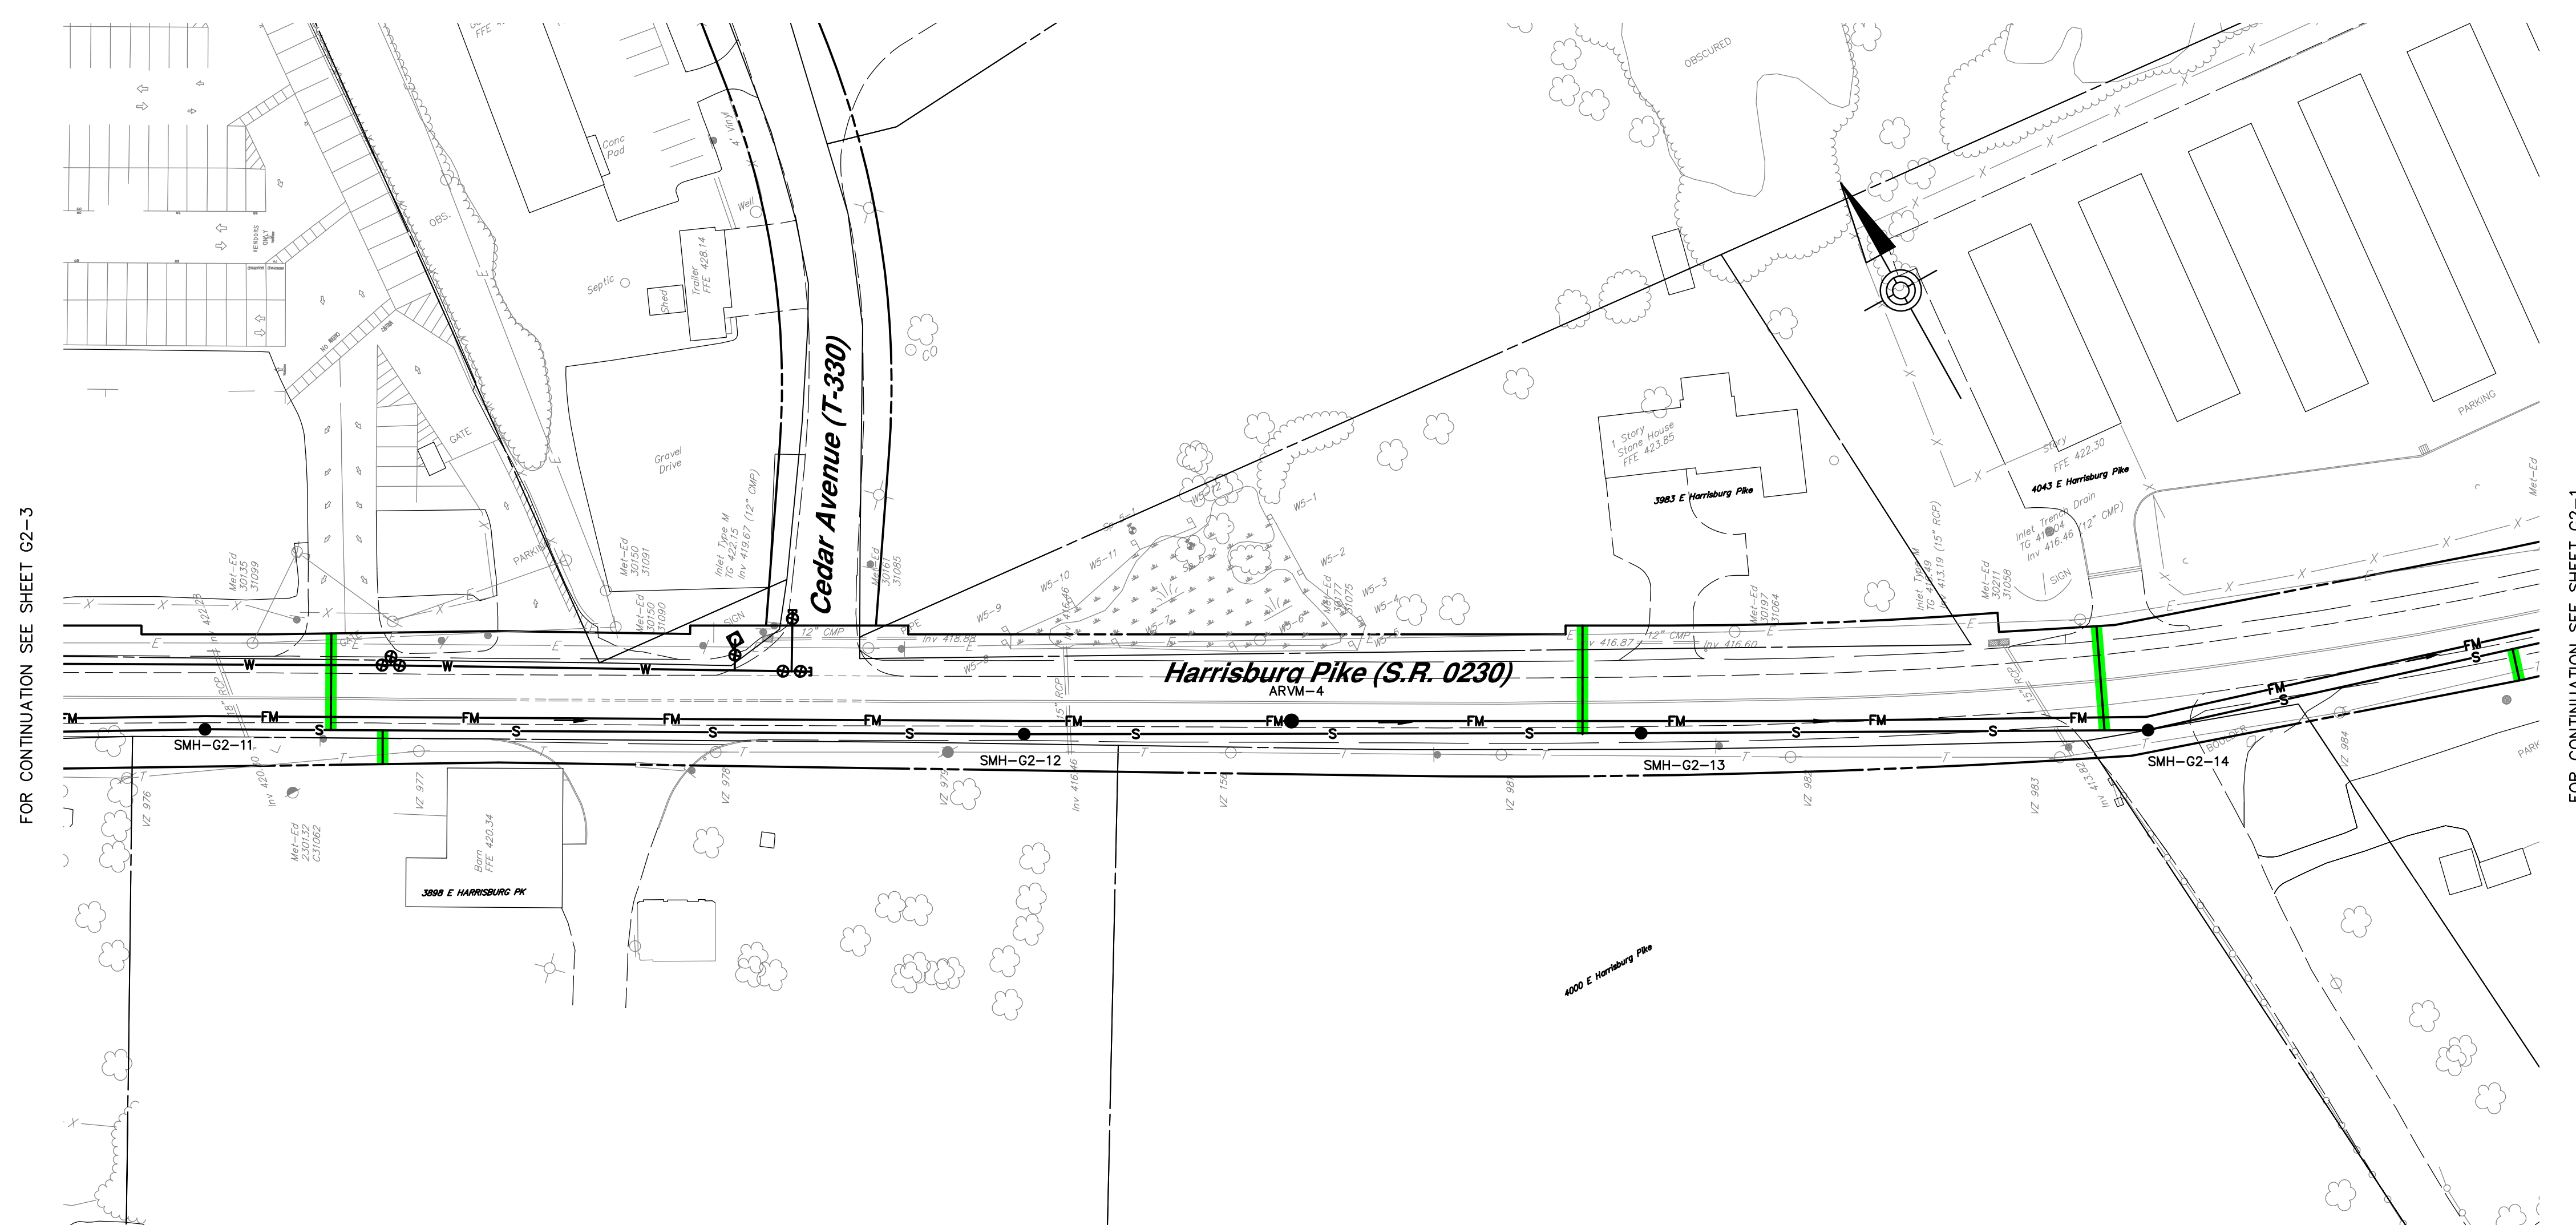


FOR CONTINUATION SEE SHEET G2-3

FOR CONTINUATION SEE SHEET G2-1



**SANITARY SEWER PLAN**  
SCALE: 1" = 50'

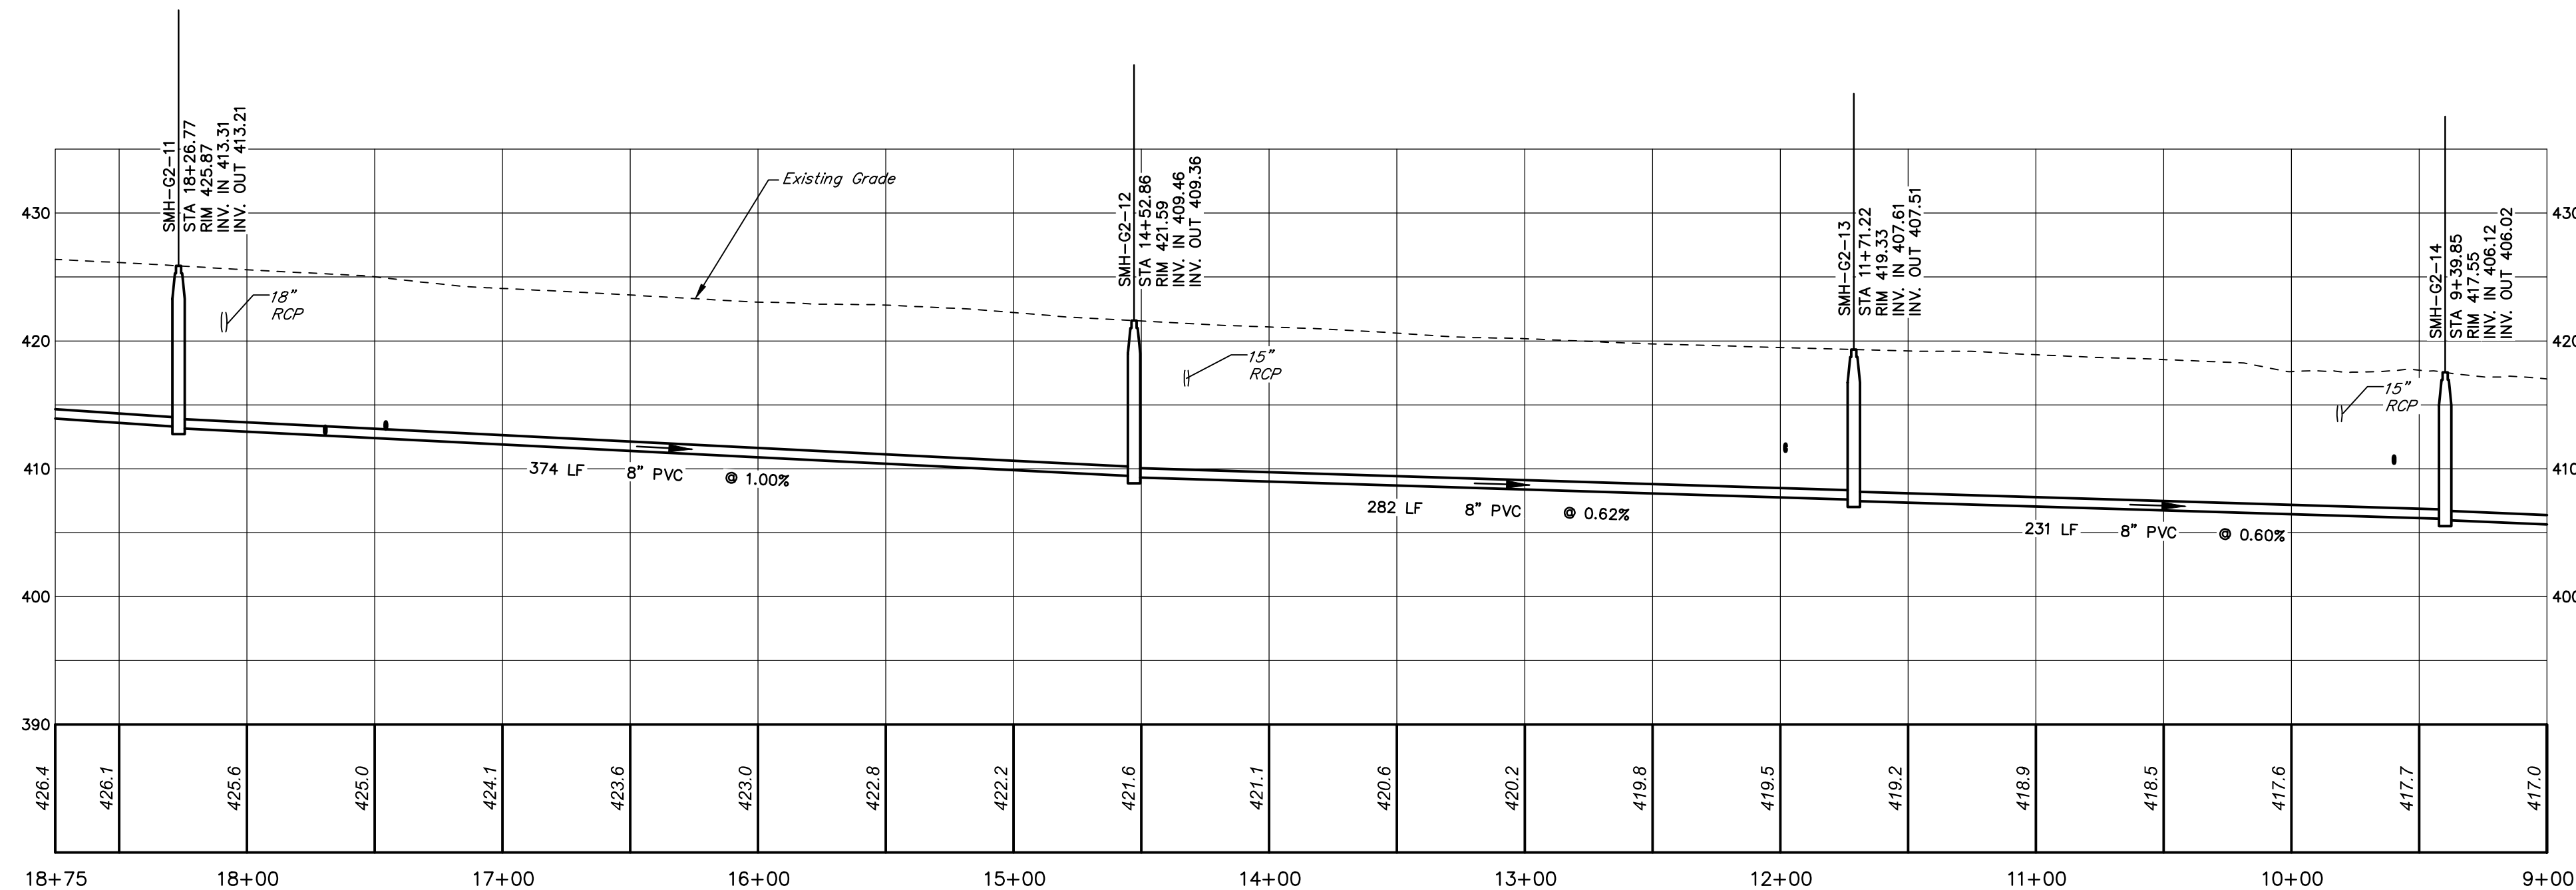

**PROFILE**  
HORIZ. SCALE: 1" = 50'  
VERT. SCALE: 1" = 10'

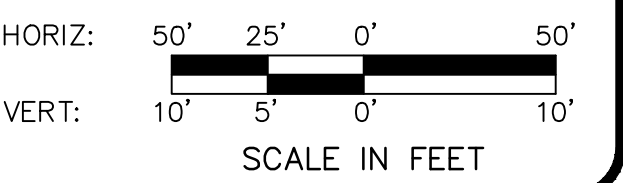

NO.	REVISION	DATE	BY

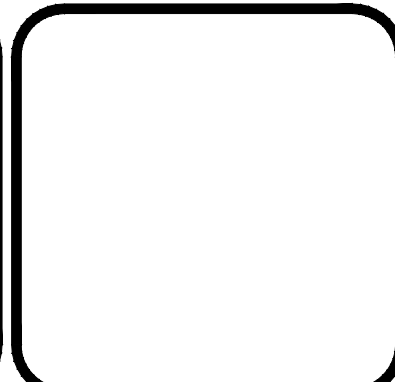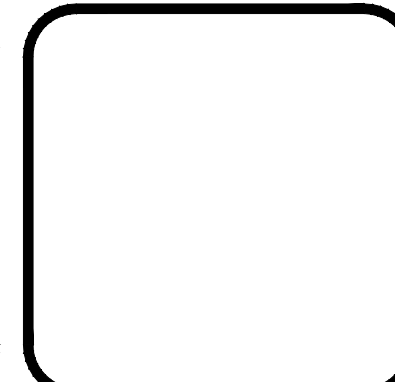

**HRG**  
Herbert, Rowland & Grubic, Inc.  
Engineering & Related Services  
AN EMPLOYEE-OWNED COMPANY

369 East Park Drive  
Harrisburg, PA 17111  
(717) 564-1121  
Fax (717) 564-1158  
hr@hr-g-inc.com  
www.hr-g-inc.com

**CORE5 INDUSTRIAL PARTNERS**  
1250 N. MOUNTAIN ROAD  
HARRISBURG, PA 17112  
  
(717) 461-7730

**SANITARY SEWER PLAN AND PROFILE**  
**DEODATE PUMP STATION**  
**FOR LONDONDERRY TOWNSHIP SANITARY**  
**SEWER AND WATER EXTENSION PHASE I**


LONDONDERRY TOWNSHIP    DAUPHIN COUNTY    PENNSYLVANIA

PROJ. MGR. - JTF
DESIGN - HCK
CADD - KRB
CHECKED - MDC
SCALE - AS NOTED
DATE - SEPT. 2020

DRAWING NO.  
**G2-2**

SHEET NO.  
**41 OF 125**


PROJECT 008048.0428

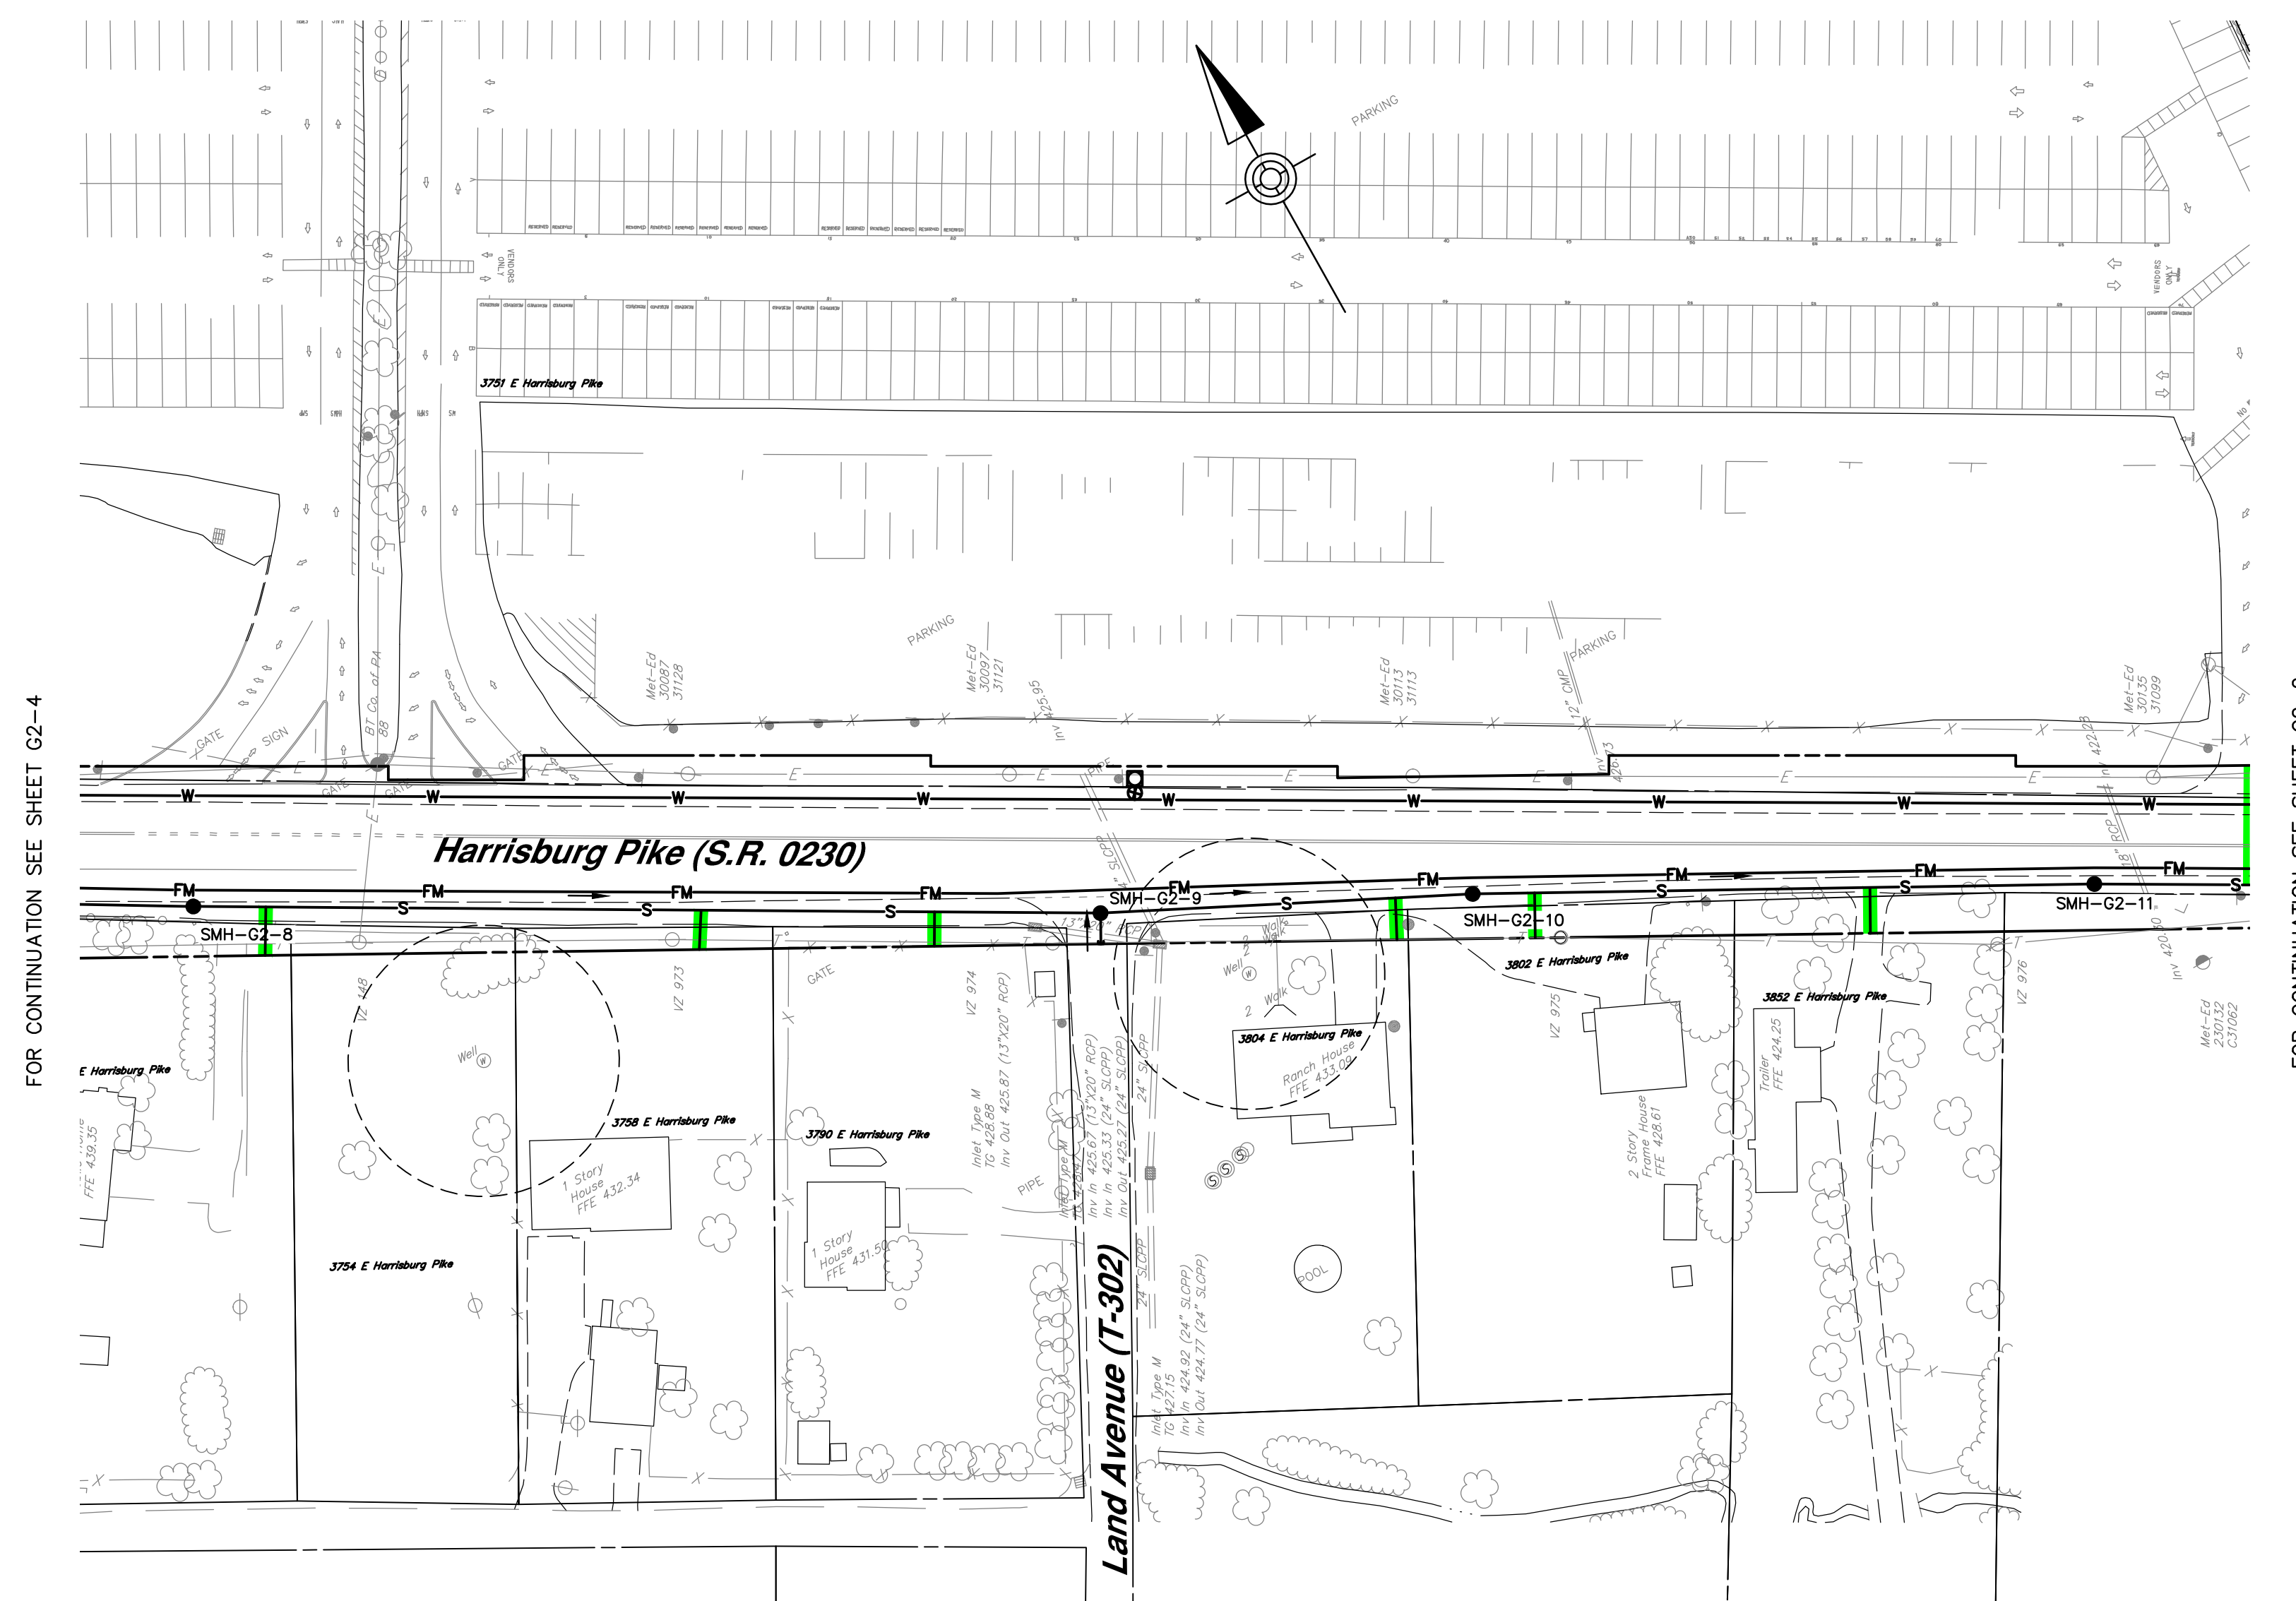


FOR CONTINUATION SEE SHEET G2-4

FOR CONTINUATION SEE SHEET G2-2


**SANITARY SEWER PLAN**  
SCALE: 1" = 50'

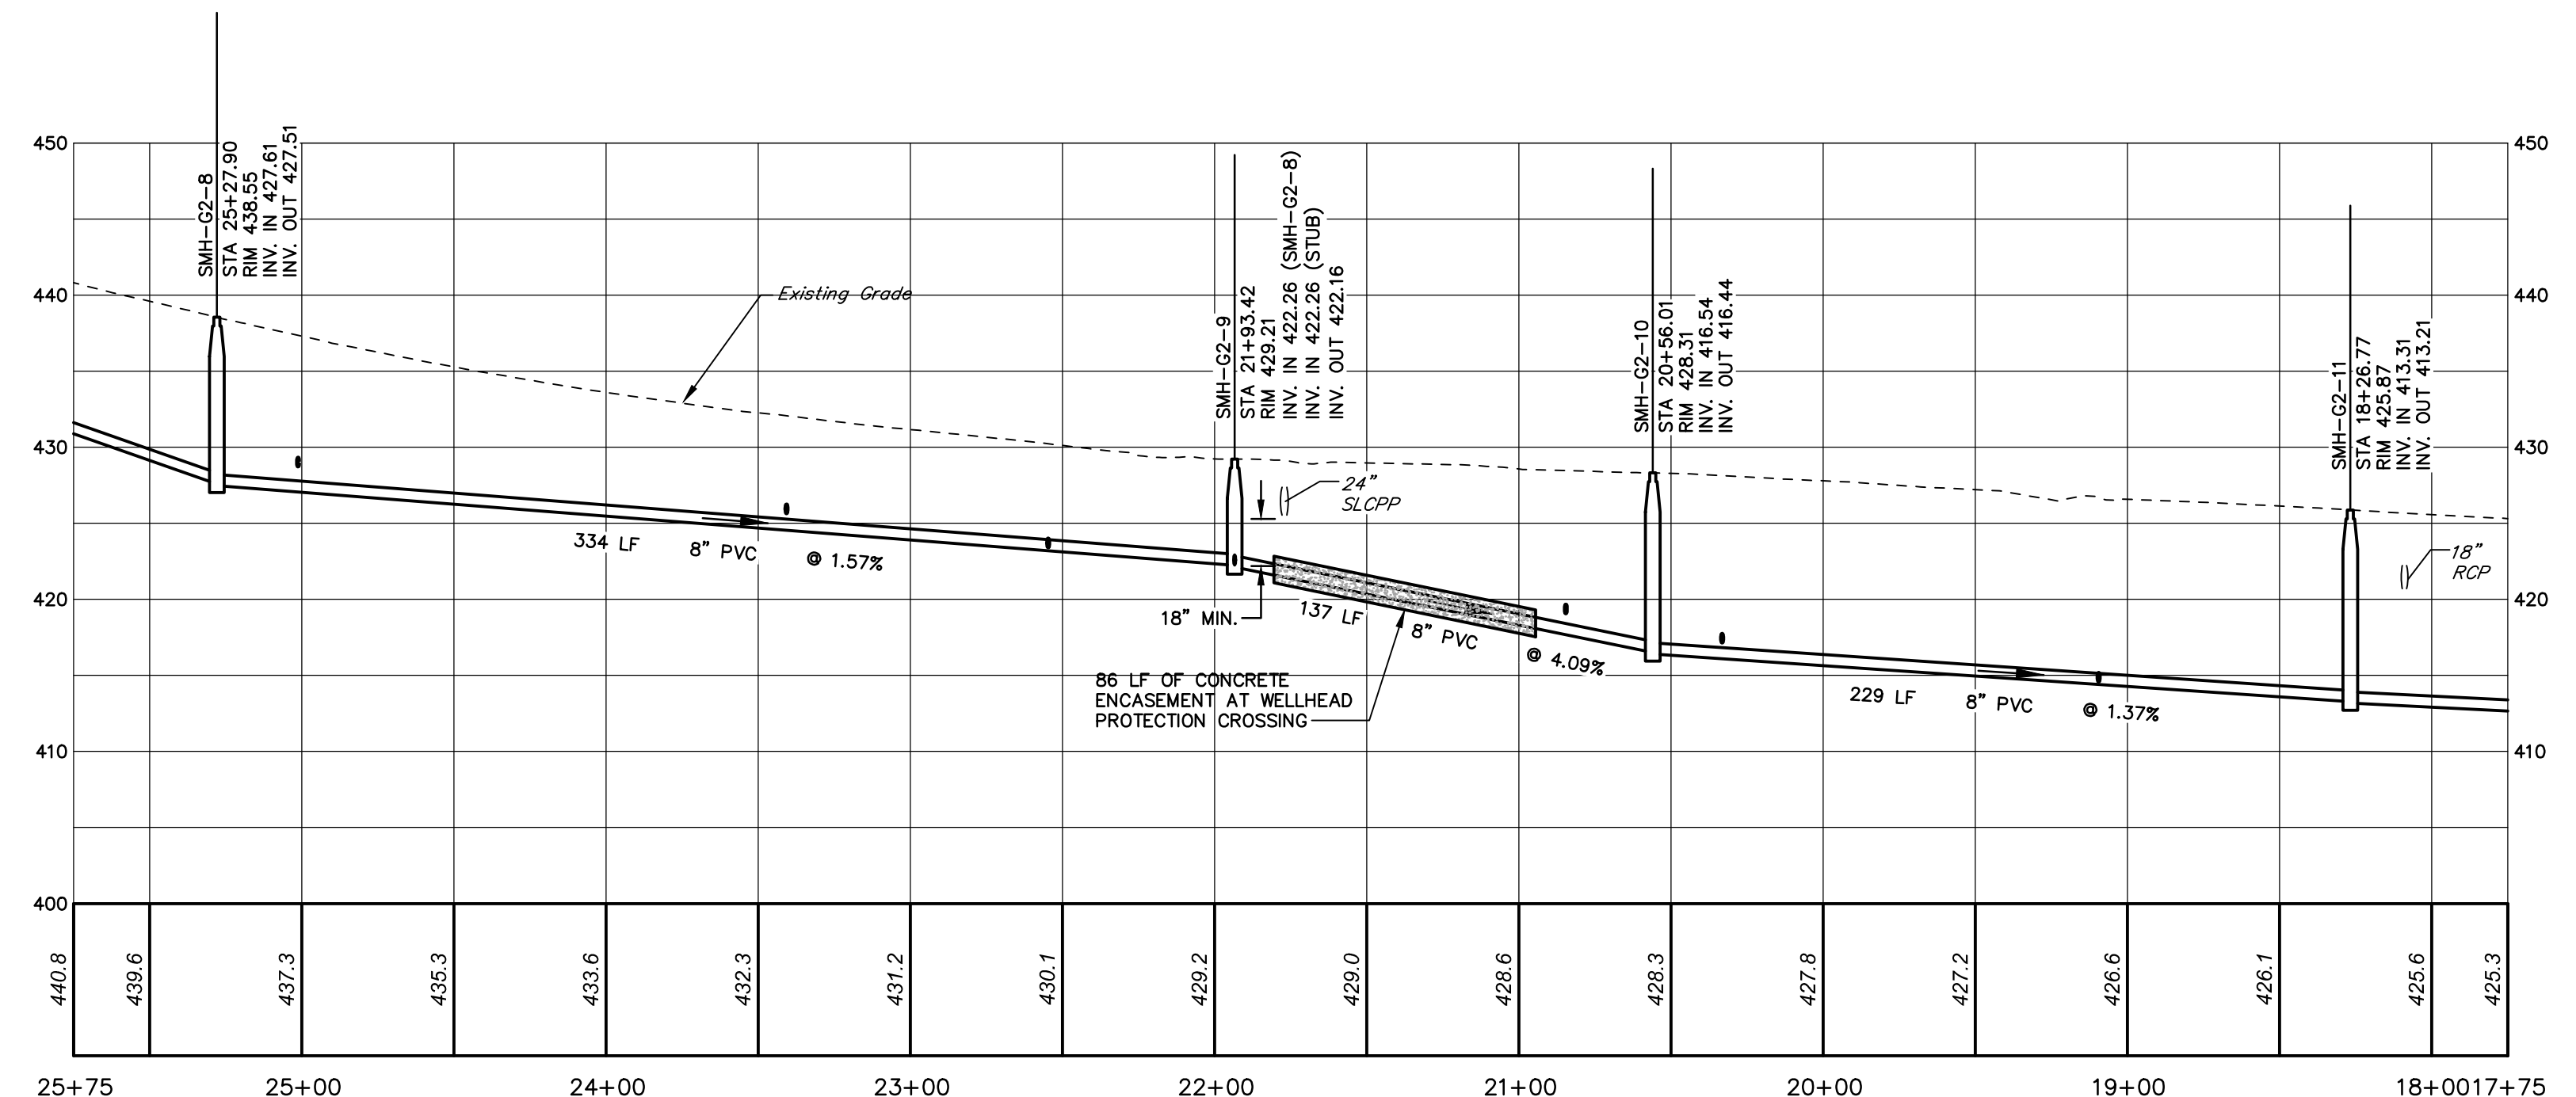

**PROFILE**  
HORIZ. SCALE: 1" = 50'  
VERT. SCALE: 1" = 10'

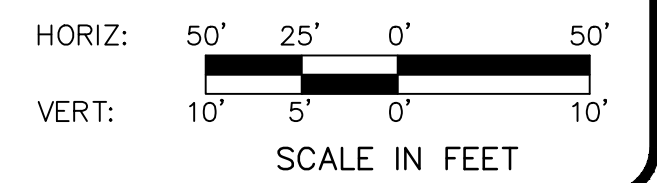

NO.	REVISION	DATE	BY

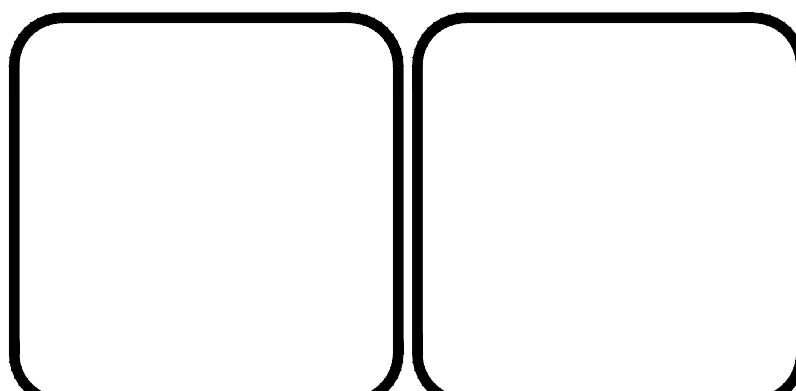

**HRG**  
Herbert, Rowland & Grubic, Inc.  
Engineering & Related Services  
AN EMPLOYEE-OWNED COMPANY

369 East Park Drive  
Harrisburg, PA 17111  
(717) 564-1121  
Fax (717) 564-1158  
hrg@hrg-inc.com  
www.hrg-inc.com

**CORE5 INDUSTRIAL PARTNERS**  
1250 N. MOUNTAIN ROAD  
HARRISBURG, PA 17112  
(717) 461-7730

**SANITARY SEWER PLAN AND PROFILE**  
**DEODATE PUMP STATION**  
**FOR LONDONDERRY TOWNSHIP SANITARY**  
**SEWER AND WATER EXTENSION PHASE I**

LONDONDERRY TOWNSHIP    DAUPHIN COUNTY    PENNSYLVANIA


PROJ. MGR. - JTF
DESIGN - HCK
CADD - KRB
CHECKED - MDC
SCALE - AS NOTED
DATE - SEPT. 2020

DRAWING NO.  
**G2-3**

SHEET NO.  
**42 OF 125**


PROJECT 008048.0428

FOR CONTINUATION SEE SHEET G2-5

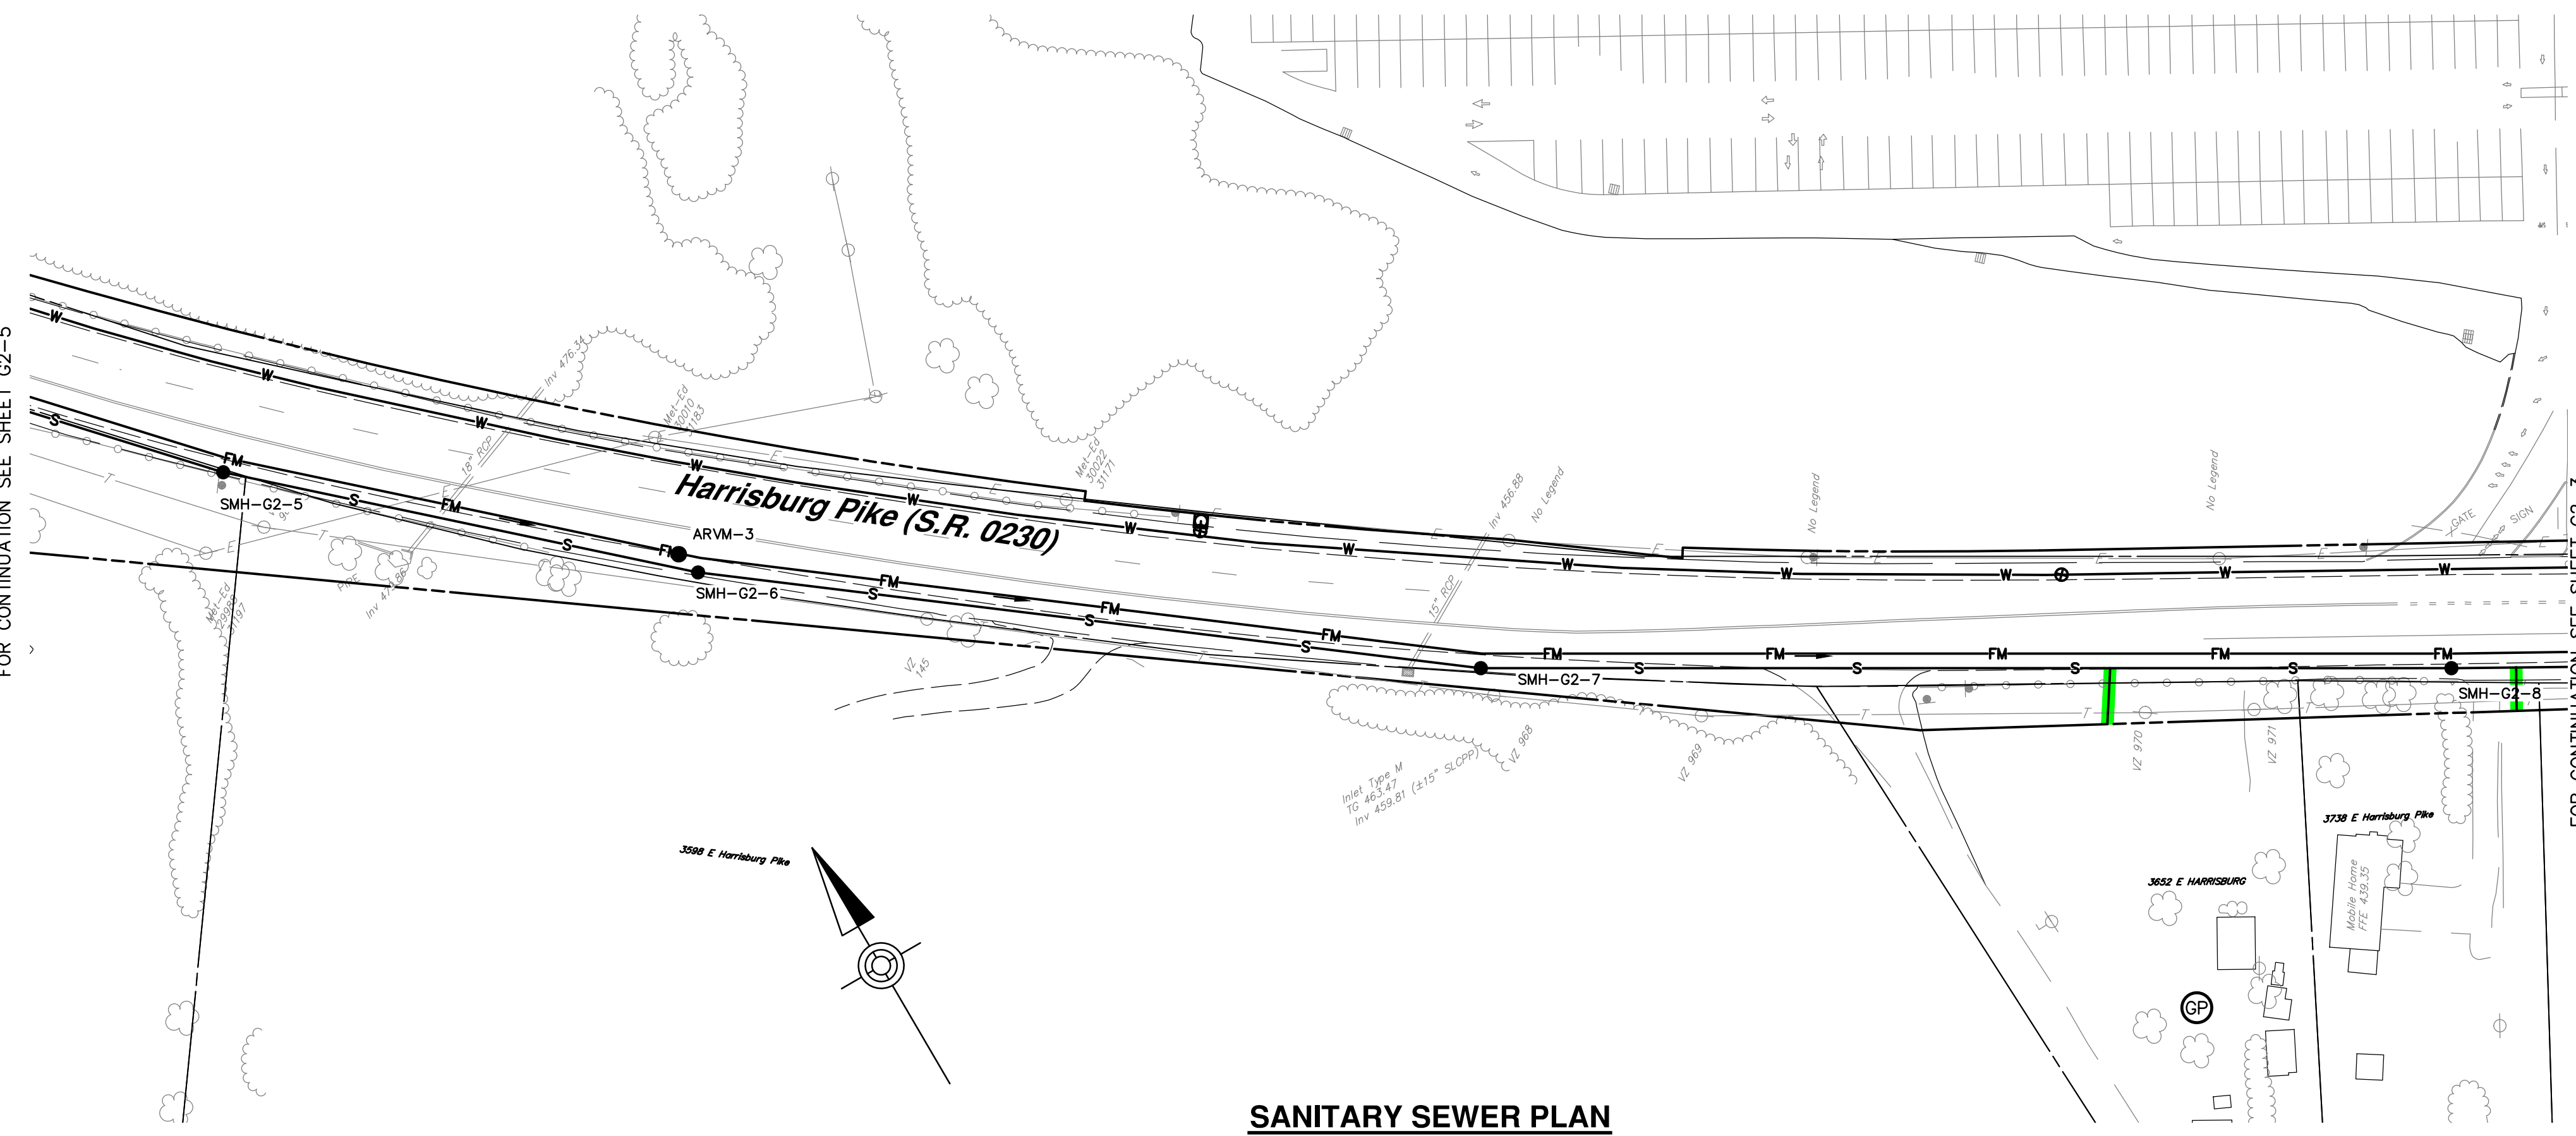


FOR CONTINUATION SEE SHEET G2-3


**SANITARY SEWER PLAN**  
SCALE: 1" = 50'

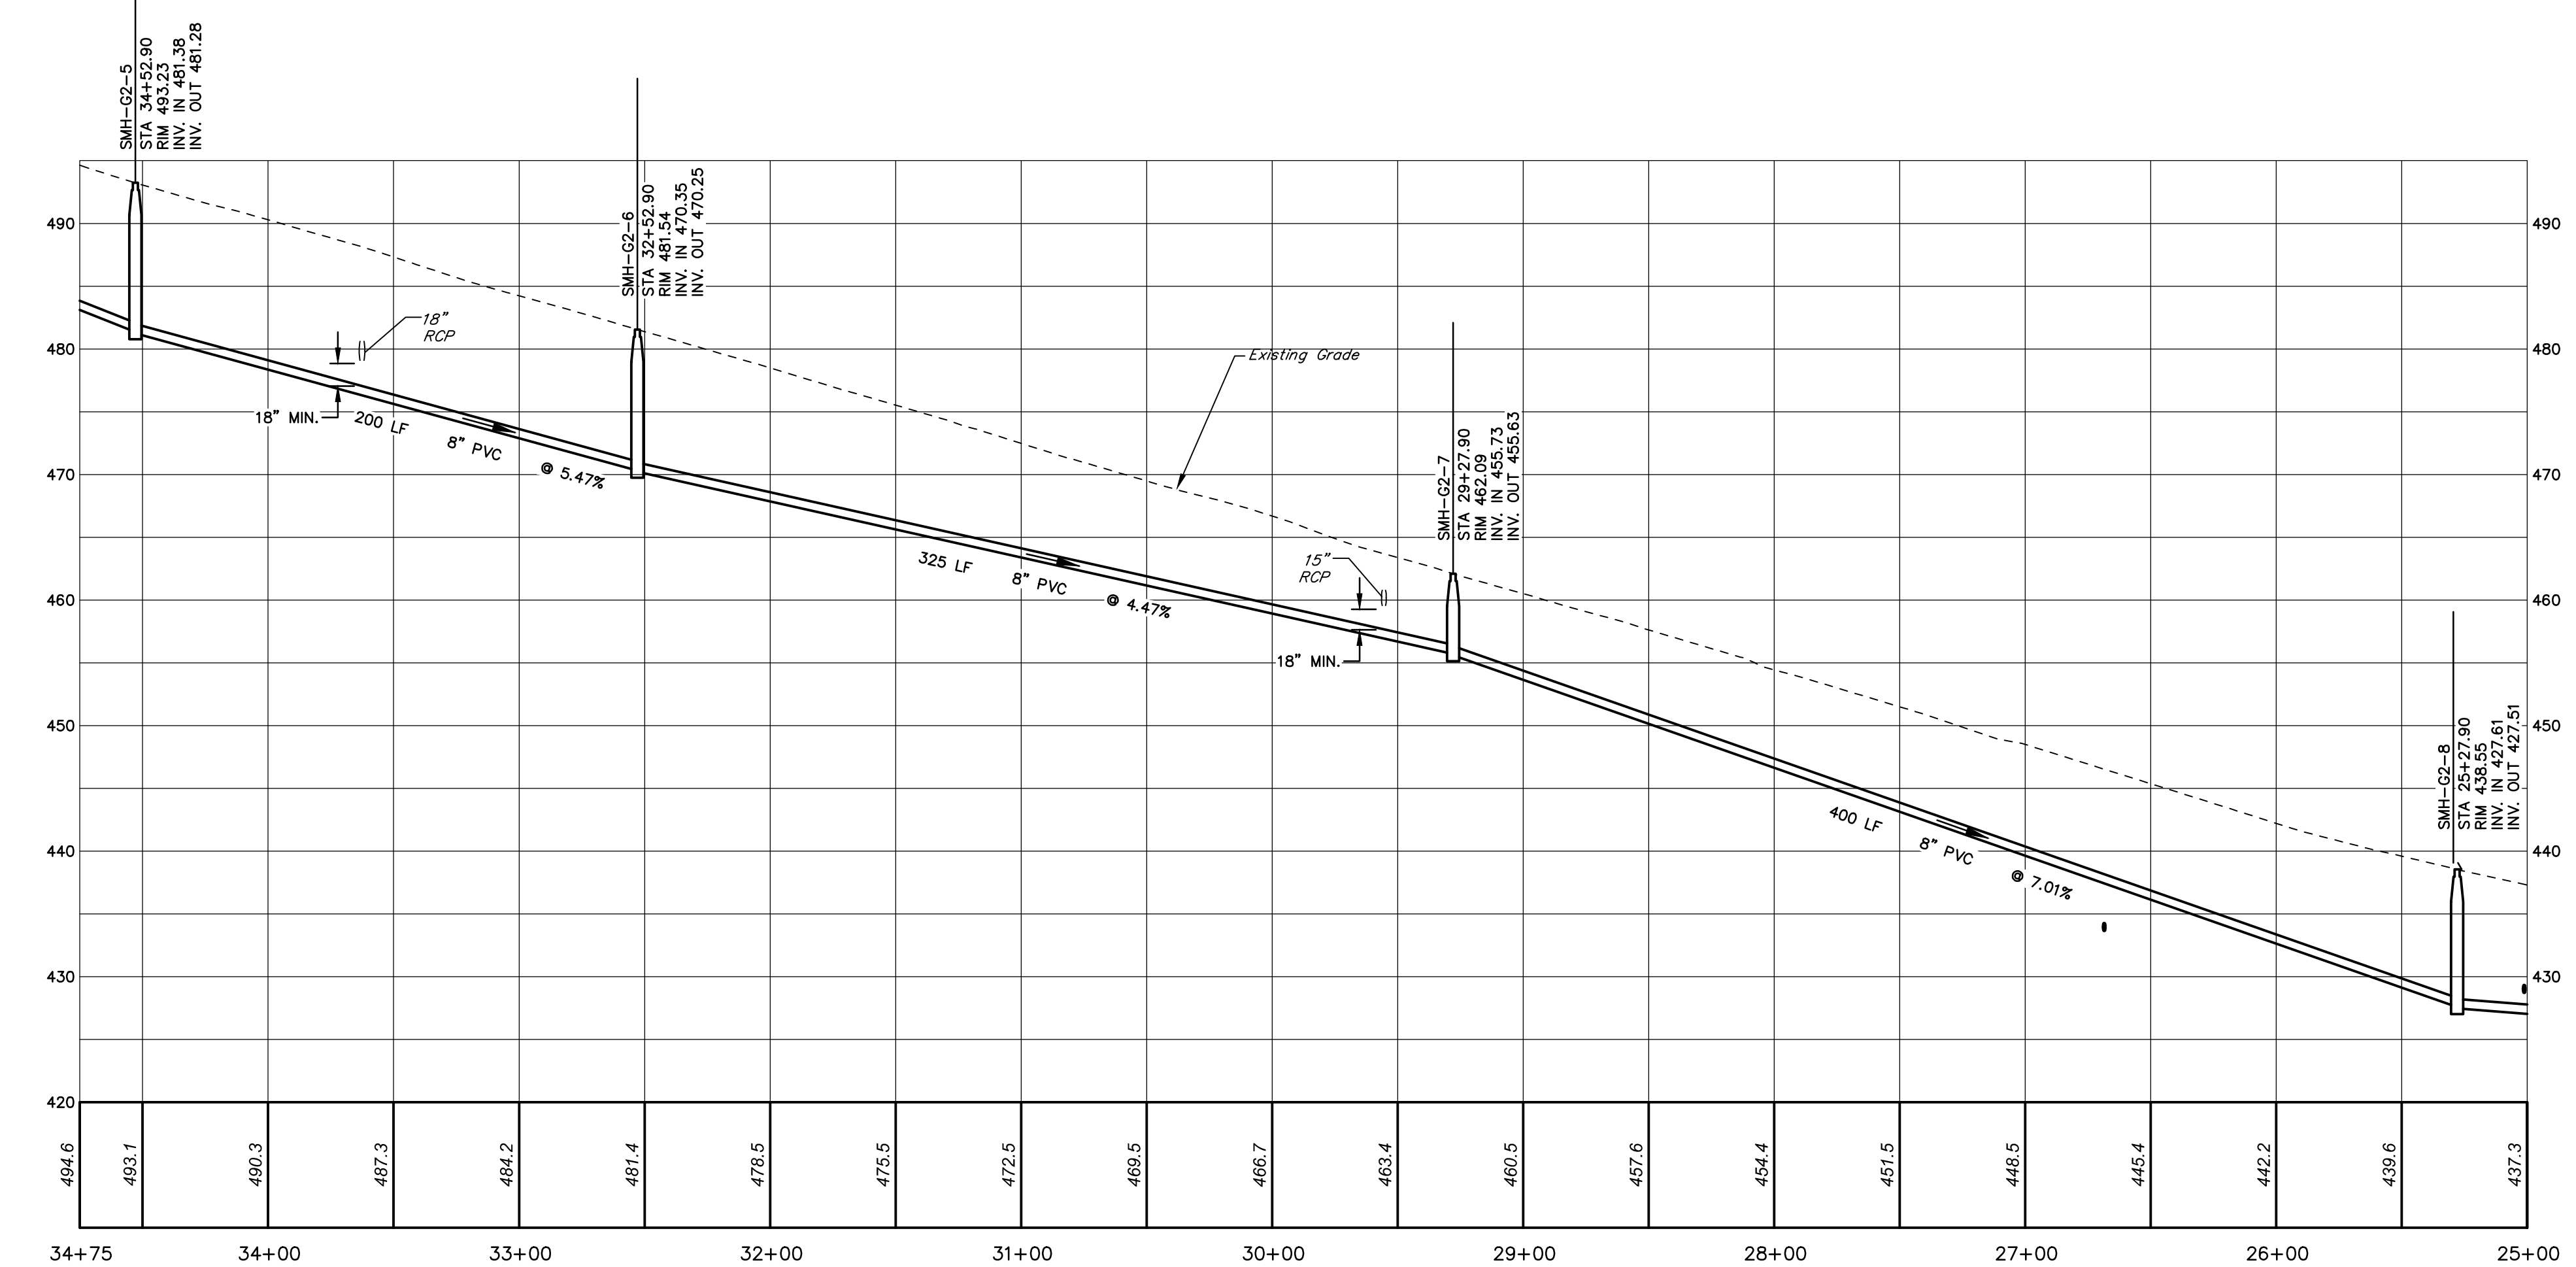

**PROFILE**  
HORIZ. SCALE: 1" = 50'  
VERT. SCALE: 1" = 10'

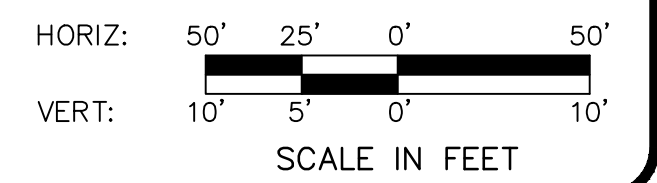

NO.	REVISION	DATE	BY

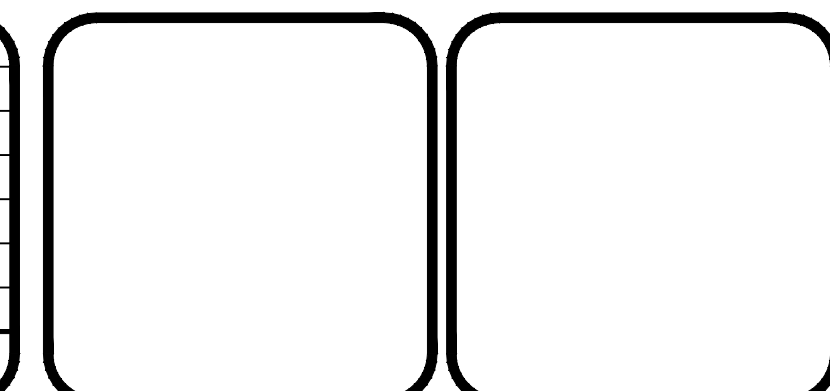

**HRG**  
Herbert, Rowland & Grubic, Inc.  
Engineering & Related Services  
AN EMPLOYEE-OWNED COMPANY

369 East Park Drive  
Harrisburg, PA 17111  
(717) 564-1121  
Fax (717) 564-1158  
hrg@hrg-inc.com  
www.hrg-inc.com

**CORE5 INDUSTRIAL PARTNERS**  
1250 N. MOUNTAIN ROAD  
HARRISBURG, PA 17112  
(717) 461-7730

**SANITARY SEWER PLAN AND PROFILE**  
**DEODATE PUMP STATION**  
**FOR LONDONDERRY TOWNSHIP SANITARY**  
**SEWER AND WATER EXTENSION PHASE I**


LONDONDERRY TOWNSHIP    DAUPHIN COUNTY    PENNSYLVANIA

PROJ. MGR. - JTF
DESIGN - HCK
CADD - KRB
CHECKED - MDC
SCALE - AS NOTED
DATE - SEPT. 2020


DRAWING NO.  
**G2-4**

SHEET NO.  
**43 OF 125**


PROJECT 008048.0428

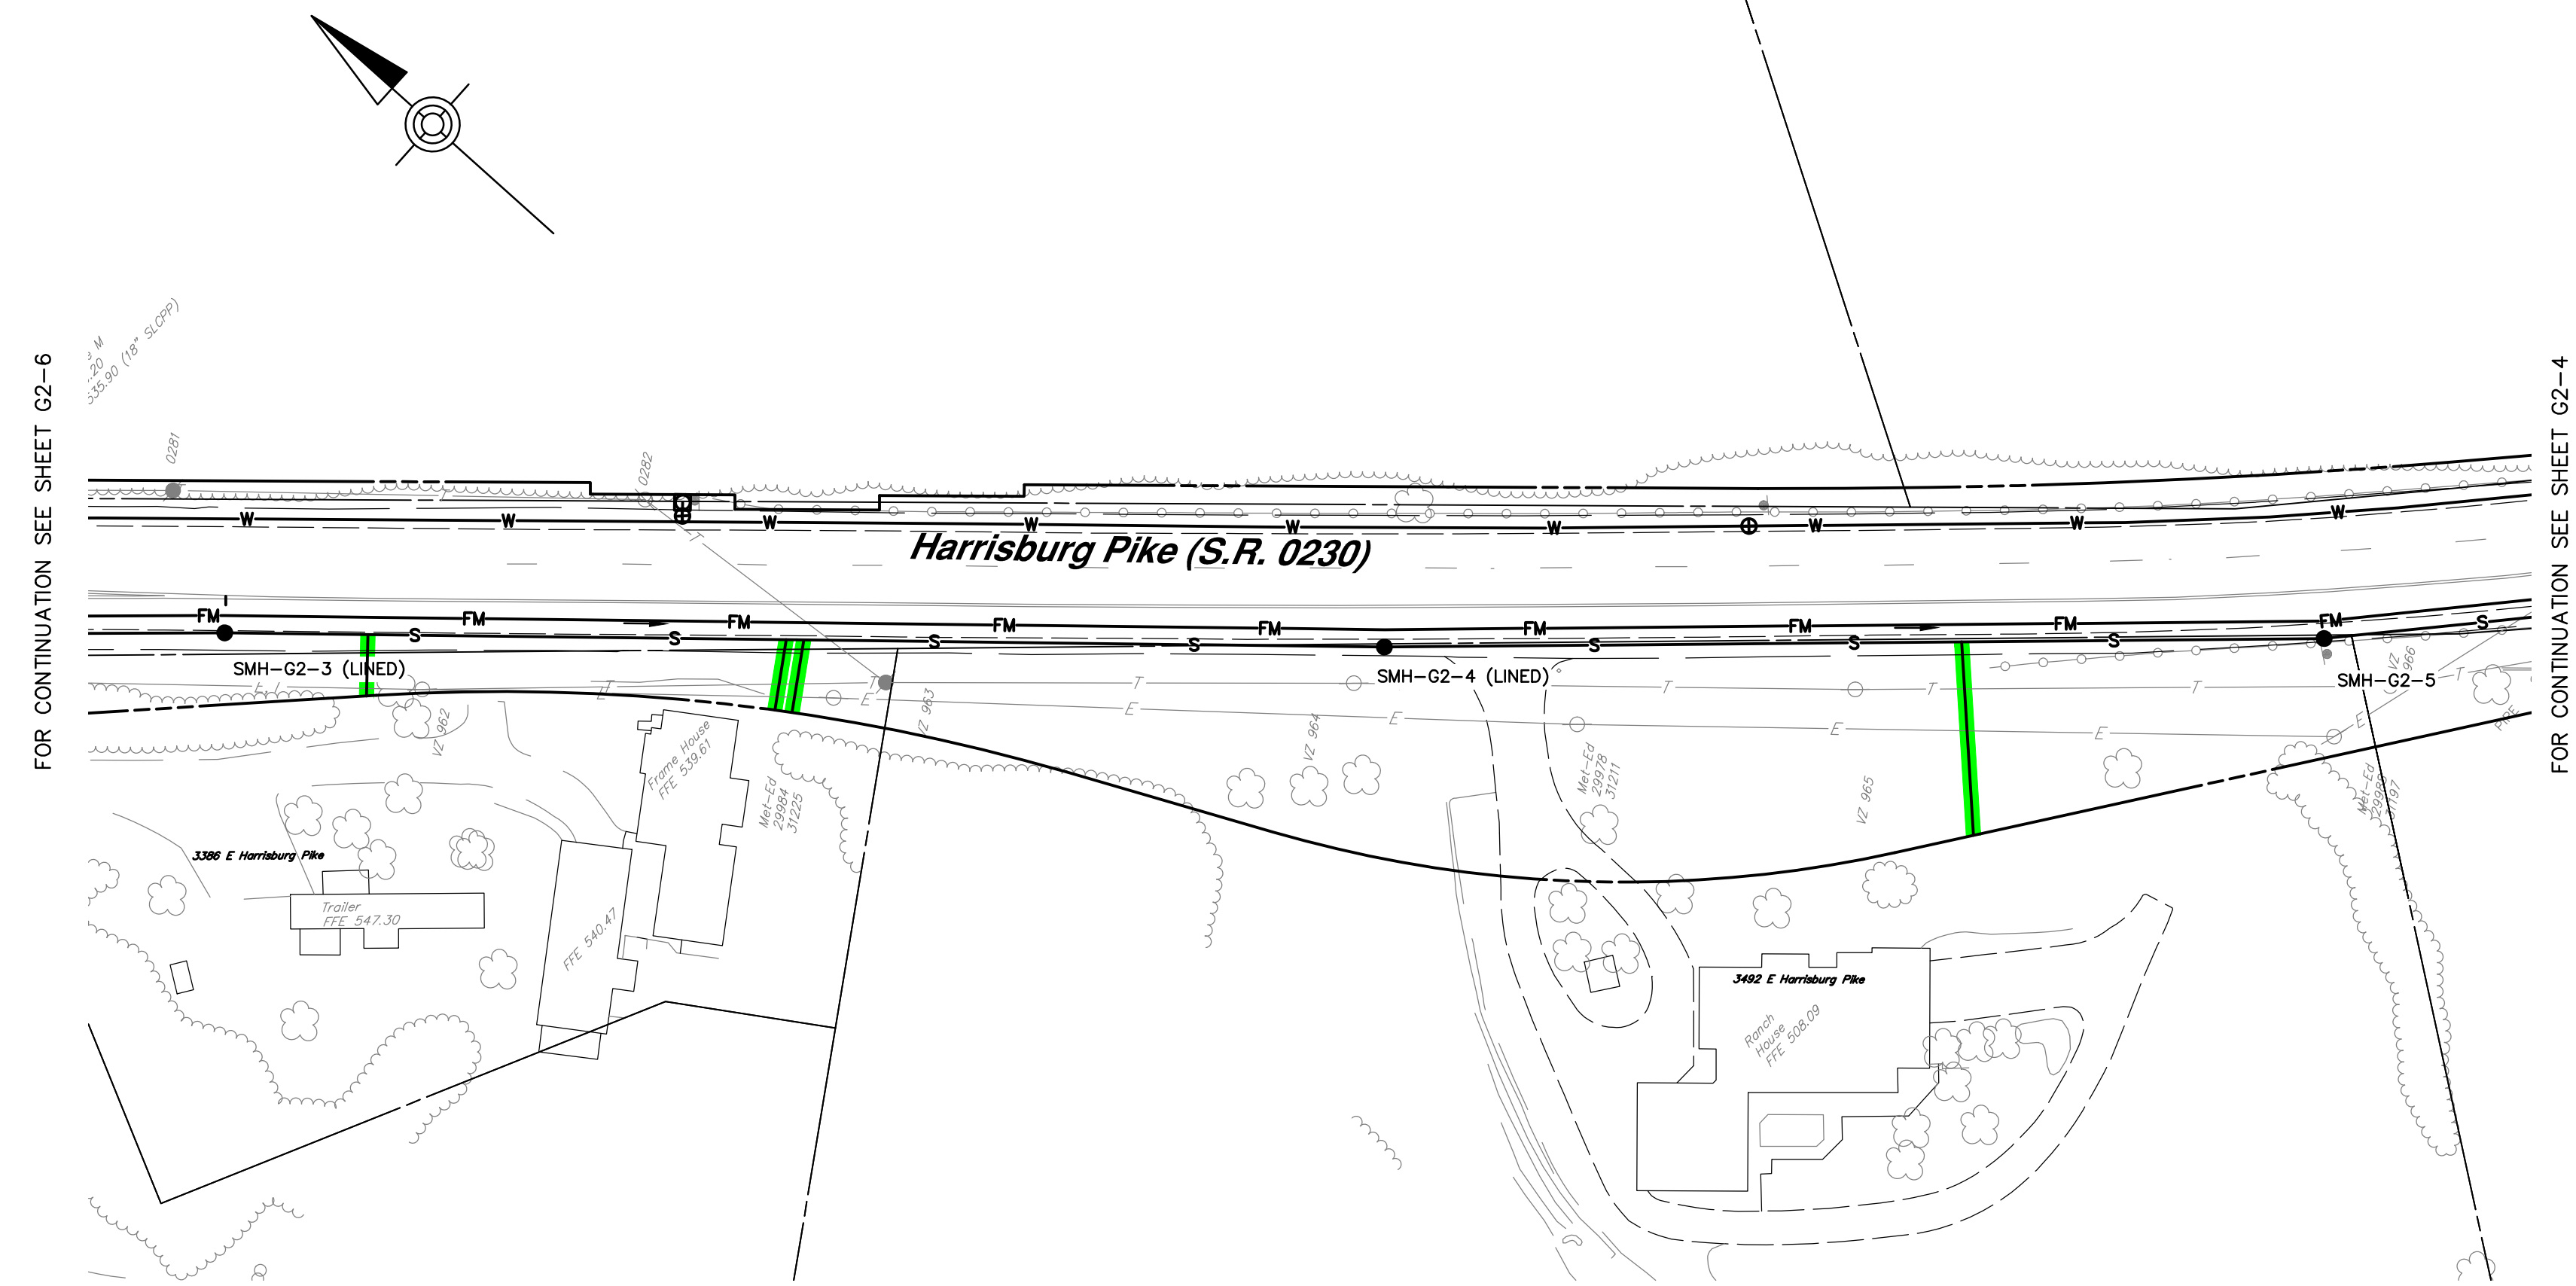


**SANITARY SEWER PLAN**  
SCALE: 1" = 50'

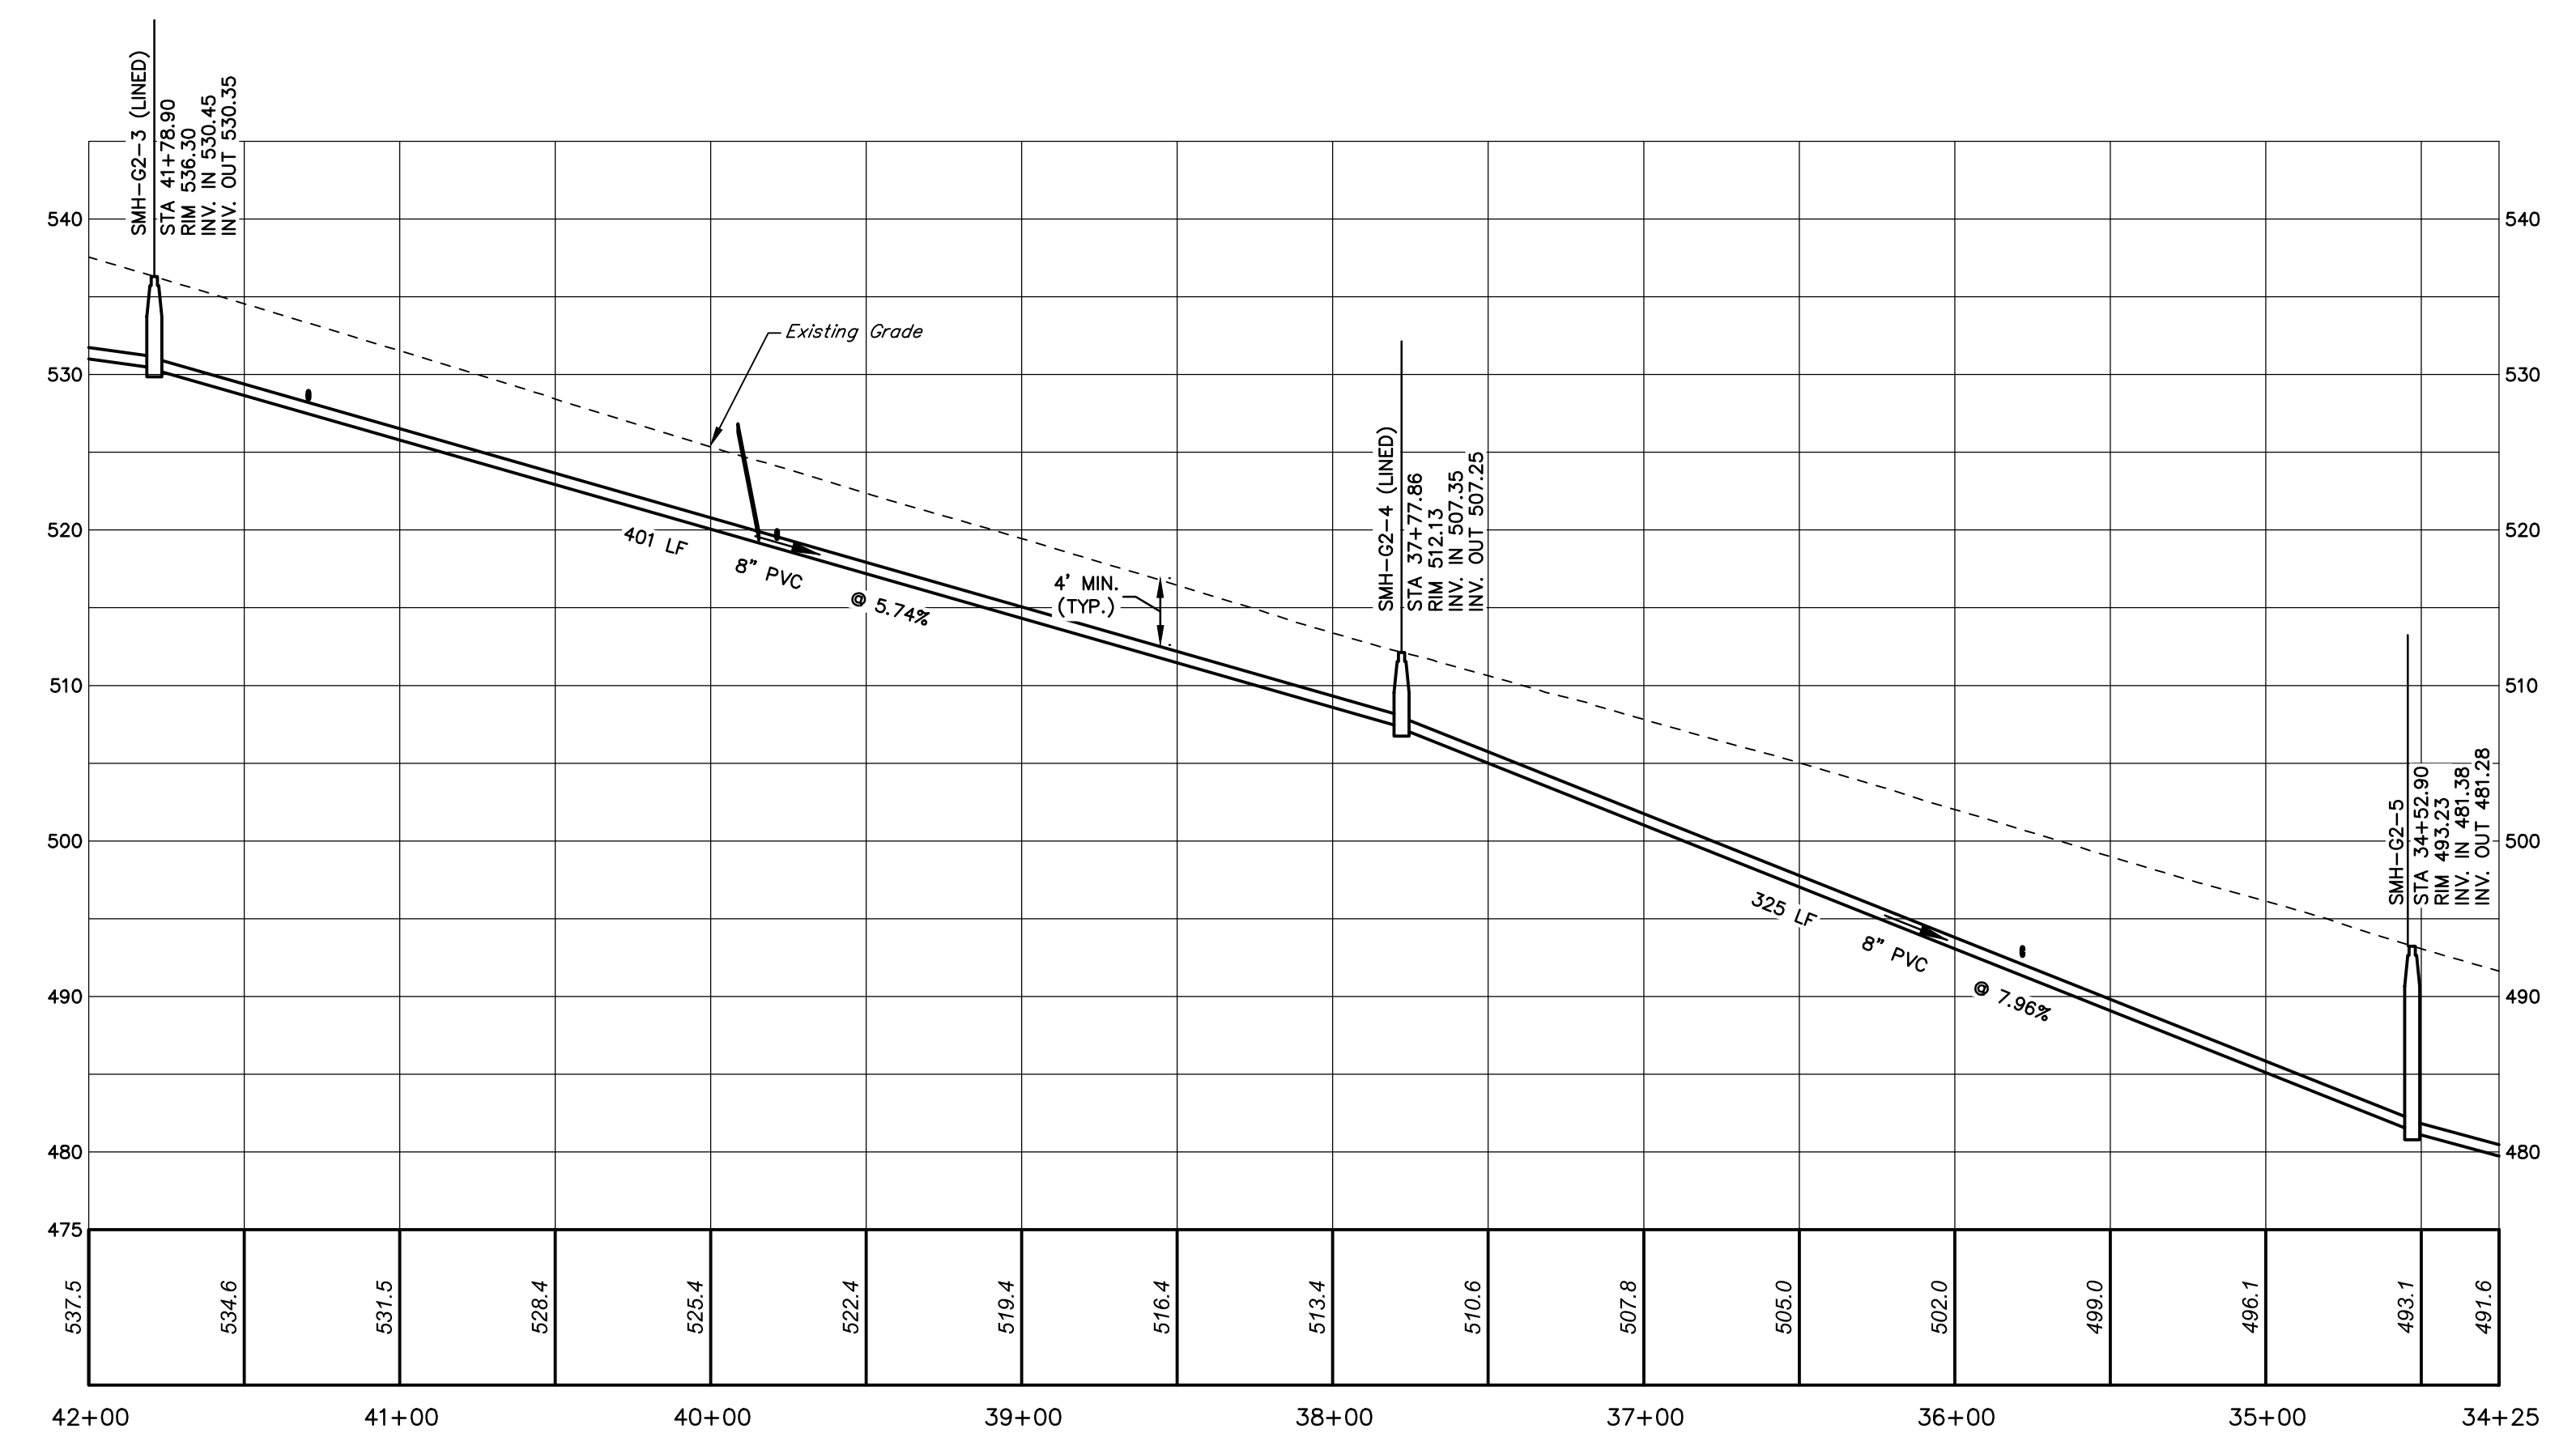

**PROFILE**  
HORIZ. SCALE: 1" = 50'  
VERT. SCALE: 1" = 10'

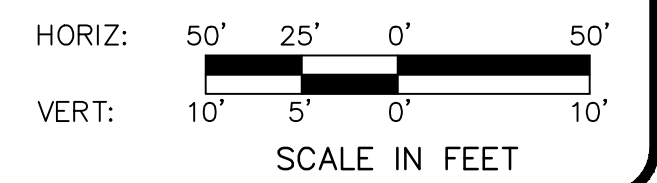

NO.	REVISION	DATE	BY

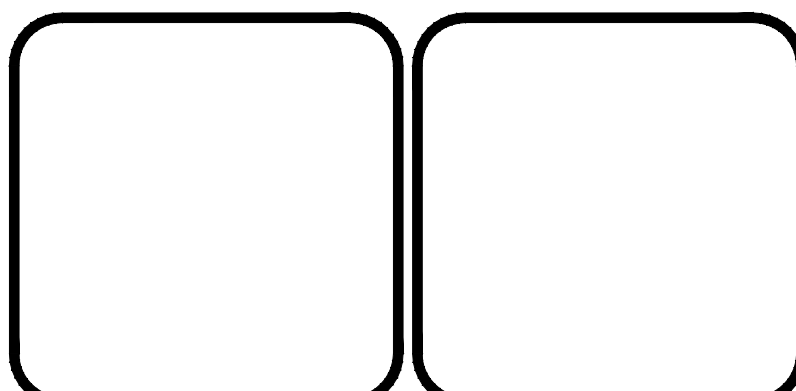

**HRG**  
Herbert, Rowland & Grubic, Inc.  
Engineering & Related Services  
AN EMPLOYEE-OWNED COMPANY

369 East Park Drive  
Harrisburg, PA 17111  
(717) 564-1121  
Fax (717) 564-1158  
hr@hrg-inc.com  
www.hrg-inc.com

**CORE5 INDUSTRIAL PARTNERS**  
1250 N. MOUNTAIN ROAD  
HARRISBURG, PA 17112  
  
(717) 461-7730

**SANITARY SEWER PLAN AND PROFILE**  
**DEODATE PUMP STATION**  
**FOR LONDONDERRY TOWNSHIP SANITARY**  
**SEWER AND WATER EXTENSION PHASE I**


LONDONDERRY TOWNSHIP    DAUPHIN COUNTY    PENNSYLVANIA

PROJ. MGR. - JTF
DESIGN - HCK
CADD - KRB
CHECKED - MDC
SCALE - AS NOTED
DATE - SEPT. 2020

DRAWING NO.  
**G2-5**  
SHEET NO.  
**44 OF 125**  
PROJECT 008048.0428


File Name: P:\008048\008048\_0428\0205\Sanitary Sewer\SMH-G2-5.dwg    Layer: 02-5    Plt: 00\_2021-125.dwt

FOR CONTINUATION SEE SHEET FM1-7

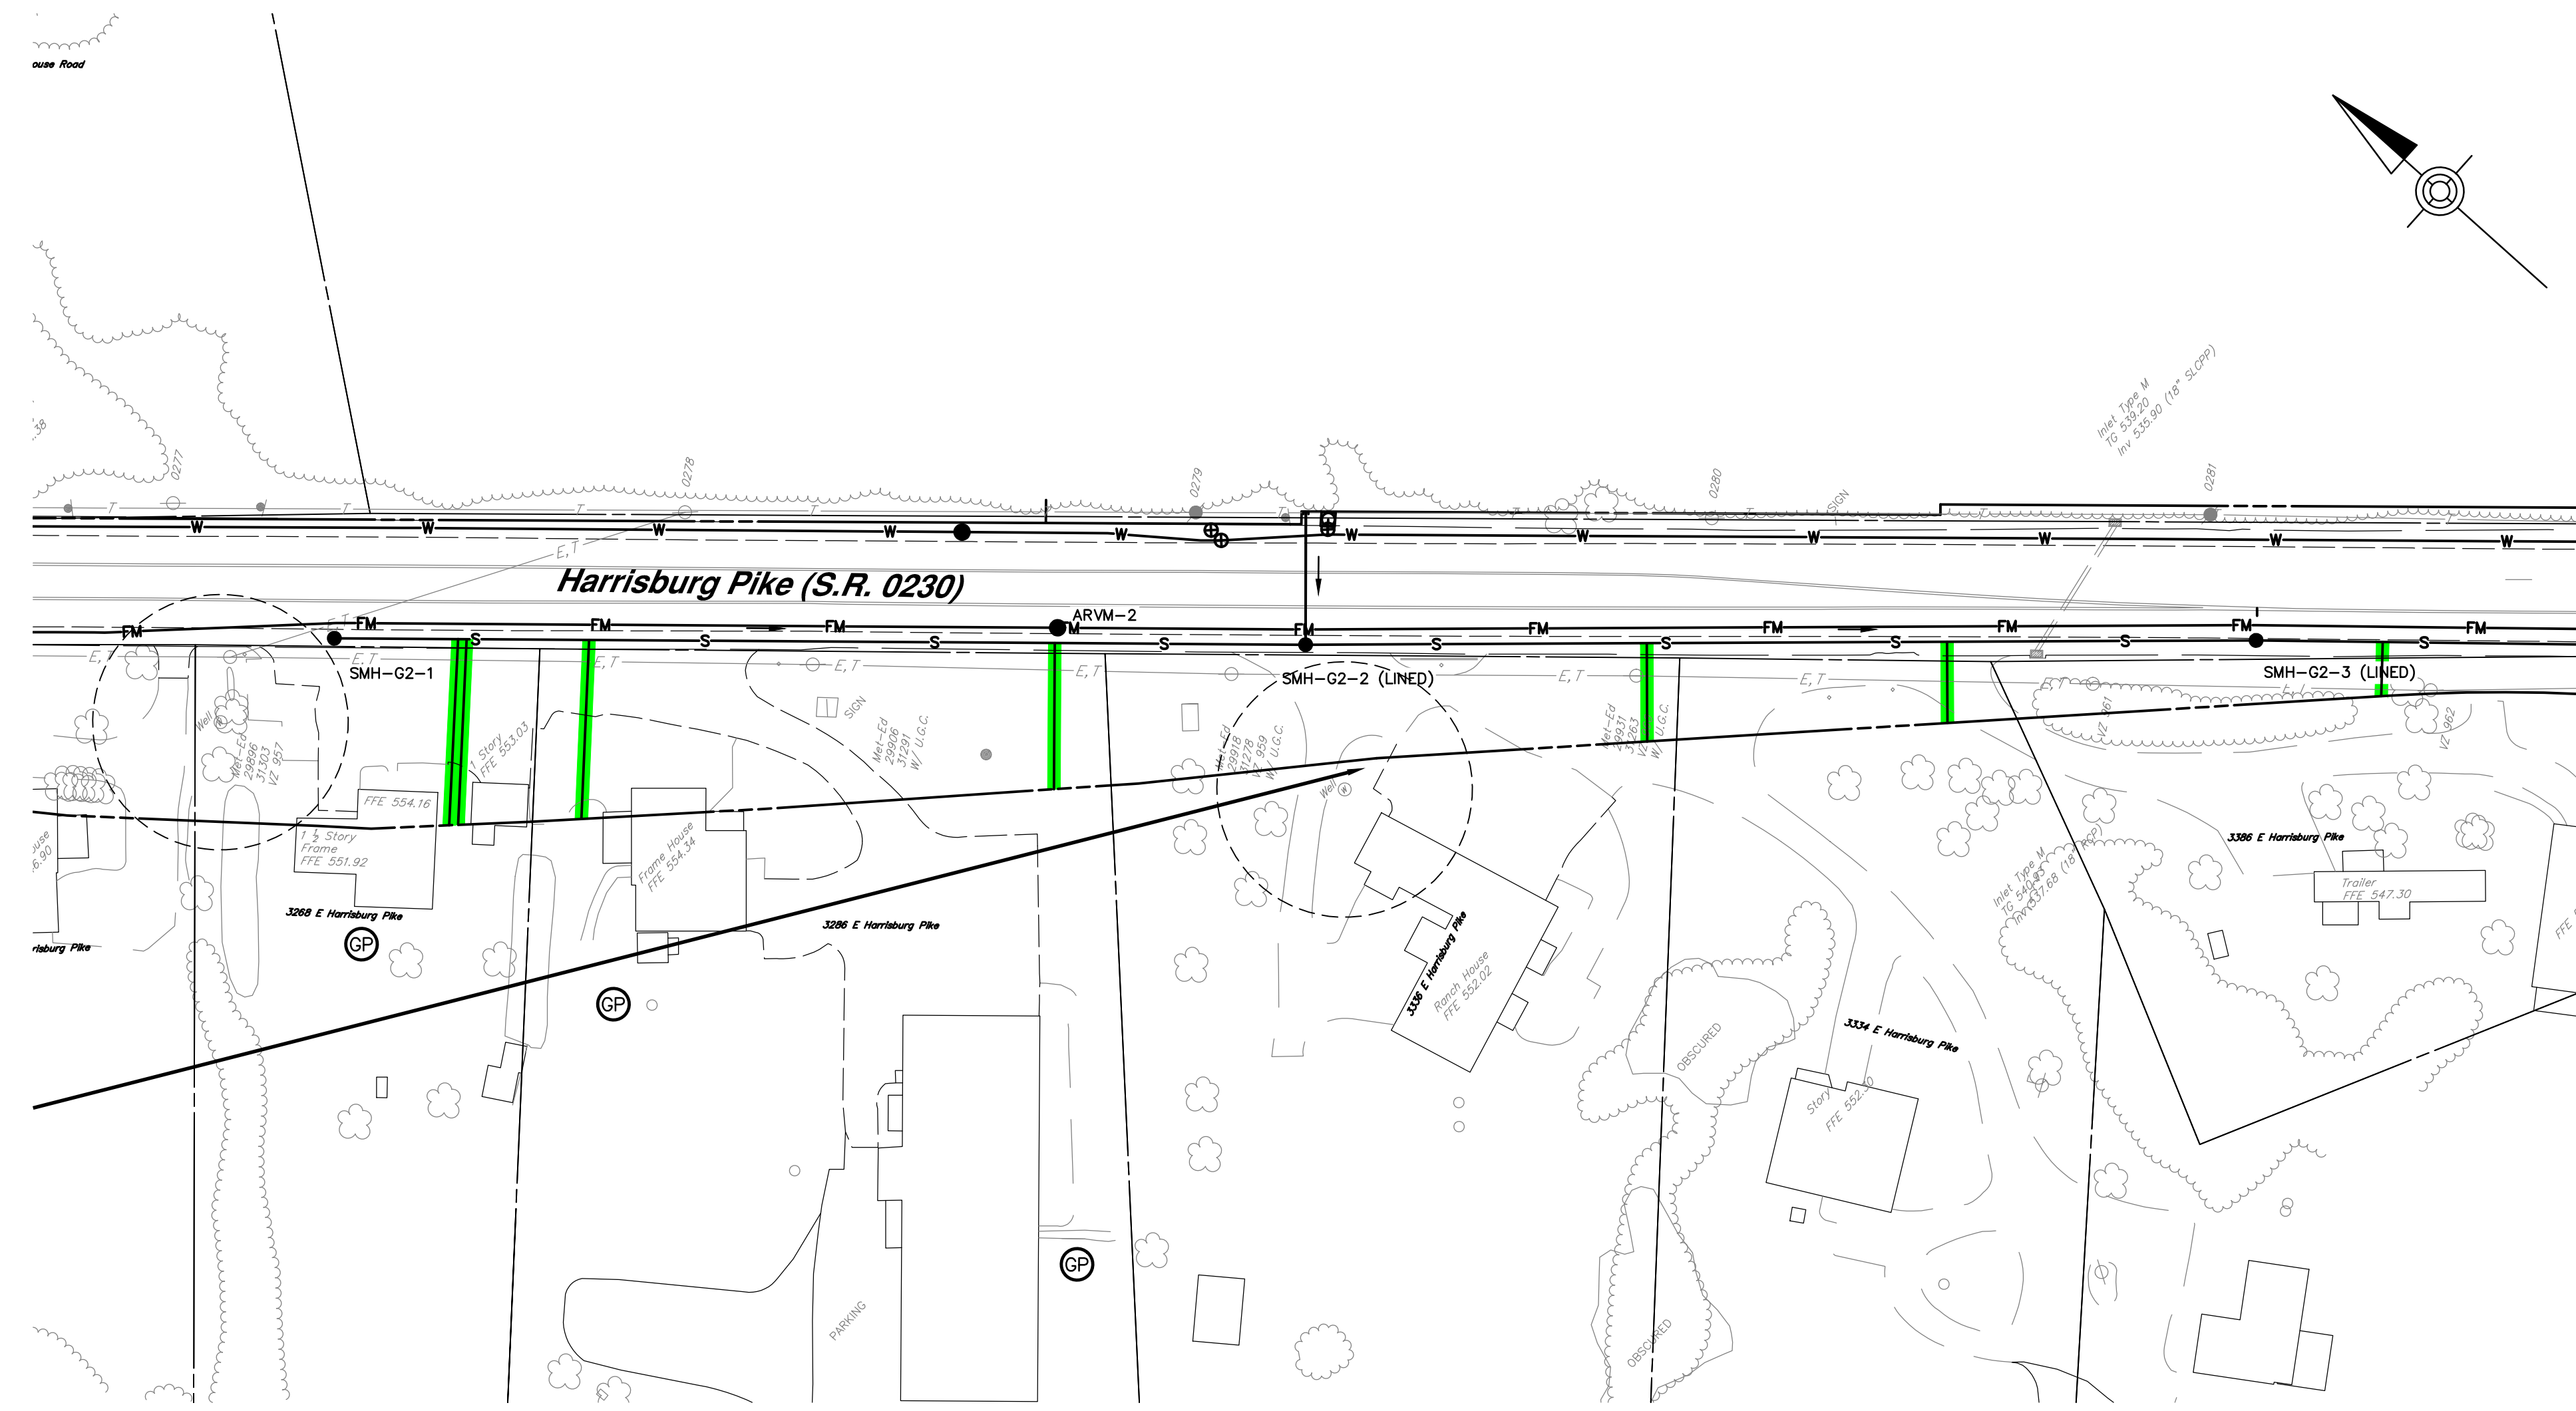


FOR CONTINUATION SEE SHEET G2-5


**SANITARY SEWER PLAN**  
SCALE: 1" = 50'

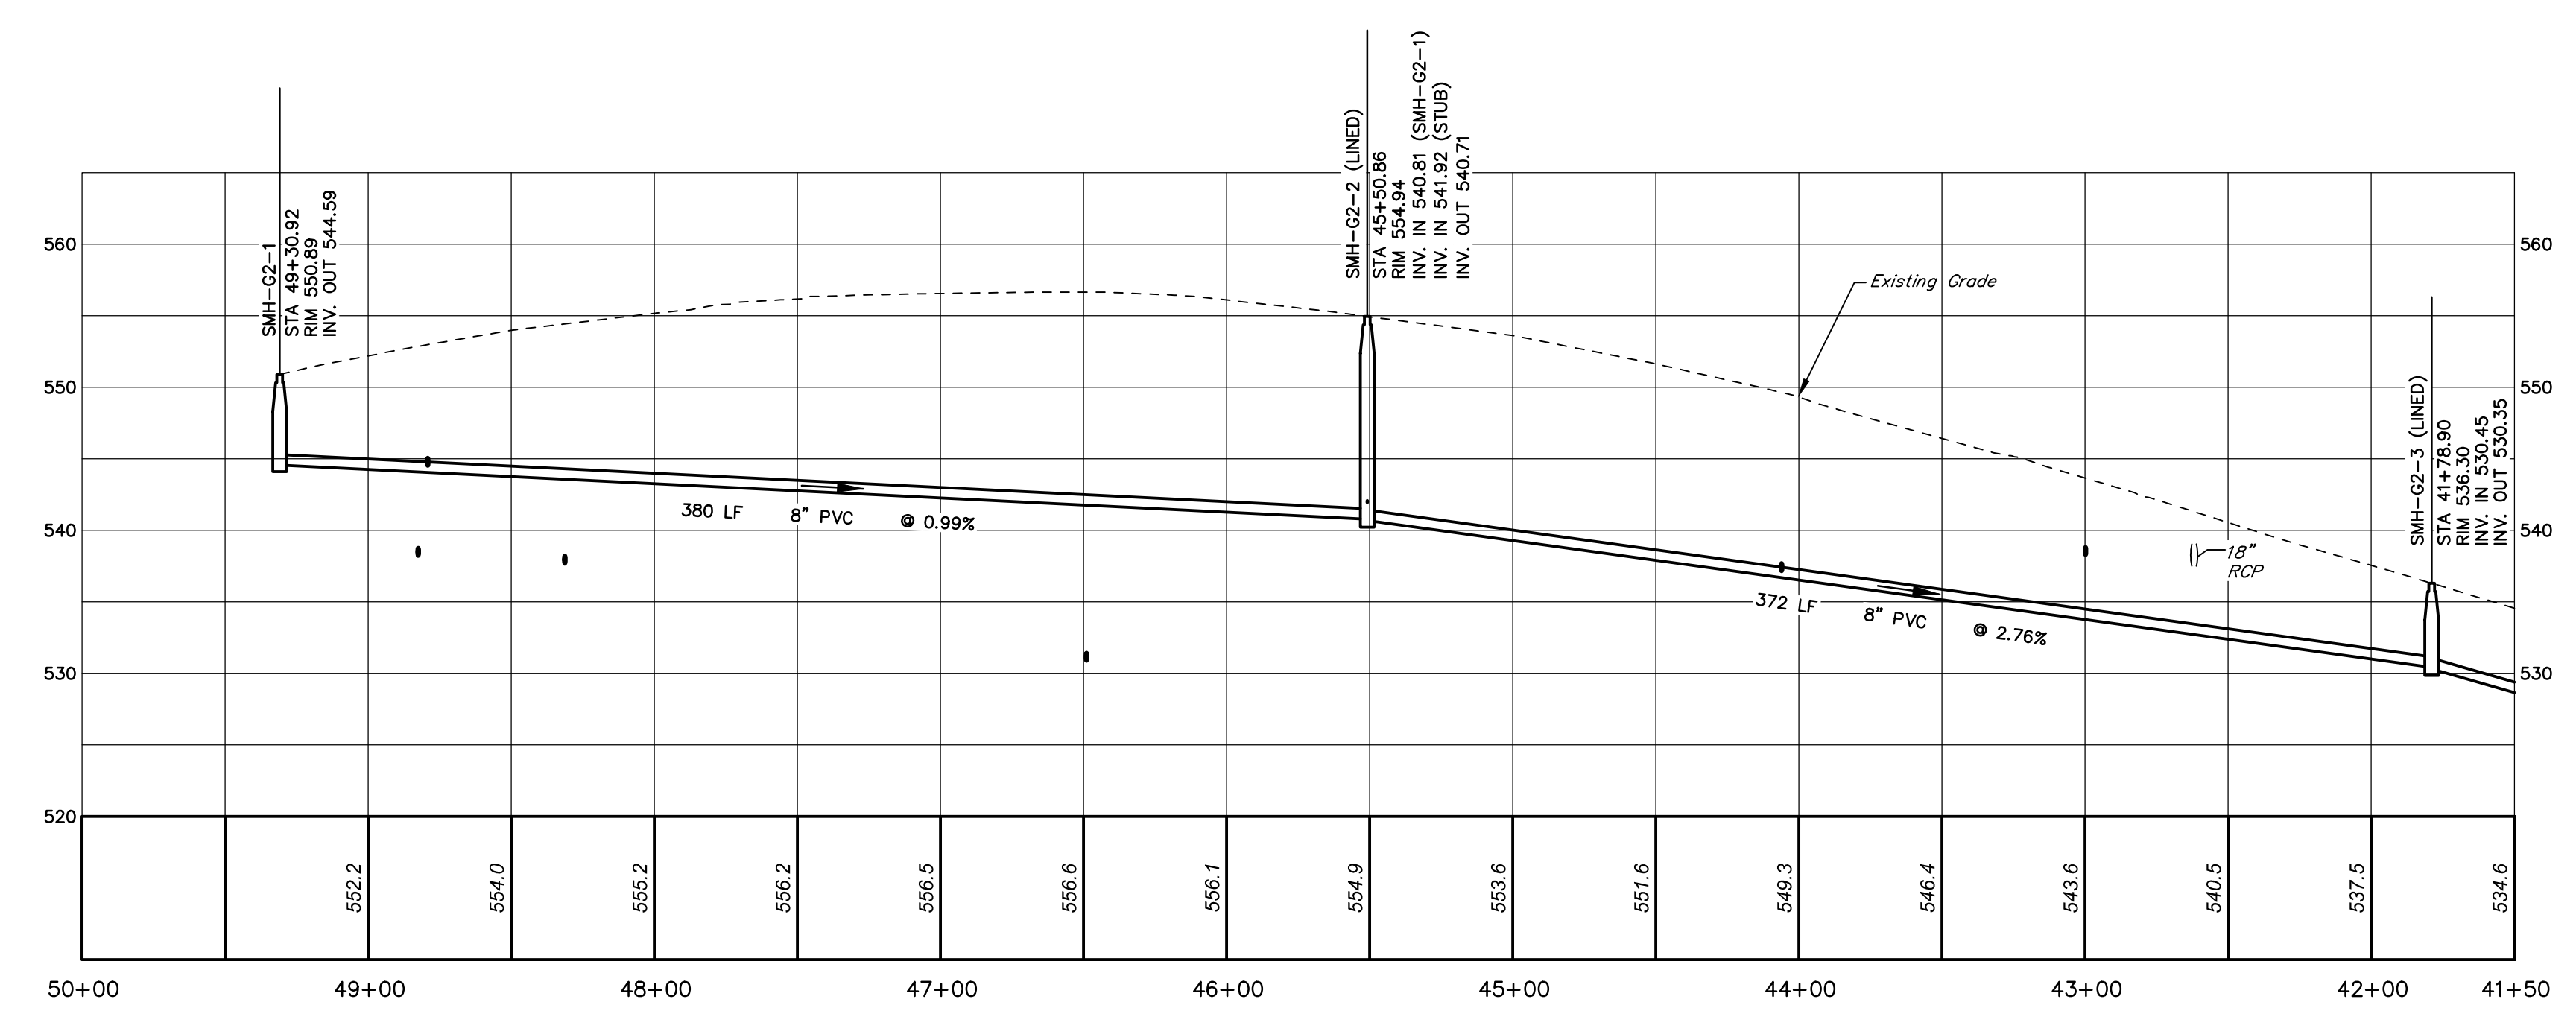

**PROFILE**  
HORIZ. SCALE: 1" = 50'  
VERT. SCALE: 1" = 10'

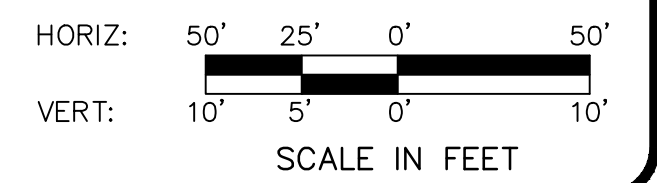

NO.	REVISION	DATE	BY

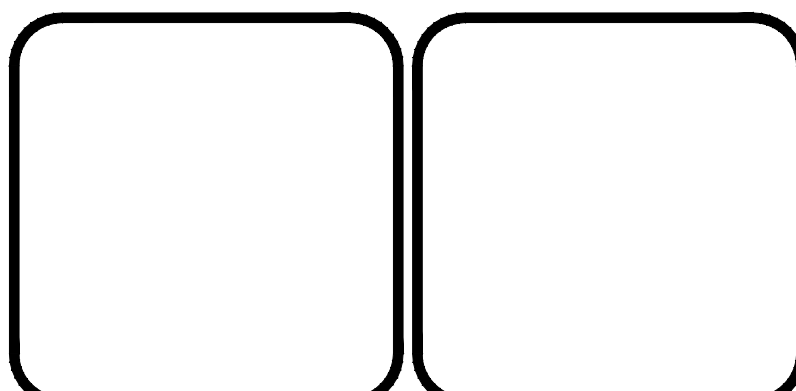

**HRG**  
Herbert, Rowland & Grubic, Inc.  
Engineering & Related Services  
AN EMPLOYEE-OWNED COMPANY

369 East Park Drive  
Harrisburg, PA 17111  
(717) 564-1121  
Fax (717) 564-1158  
hrg@hrg-inc.com  
www.hrg-inc.com

**CORE5 INDUSTRIAL PARTNERS**  
1250 N. MOUNTAIN ROAD  
HARRISBURG, PA 17112  
(717) 461-7730

**SANITARY SEWER PLAN AND PROFILE**  
**DEODATE PUMP STATION**  
**FOR LONDONDERRY TOWNSHIP SANITARY**  
**SEWER AND WATER EXTENSION PHASE I**

LONDONDERRY TOWNSHIP    DAUPHIN COUNTY    PENNSYLVANIA

PROJ. MGR. - JTF
DESIGN - HCK
CADD - KRB
CHECKED - MDC
SCALE - AS NOTED
DATE - SEPT. 2020


DRAWING NO.  
**G2-6**

SHEET NO.  
**45 OF 125**

PROJECT 008048.0428




FOR CONTINUATION SEE SHEET FM1-1

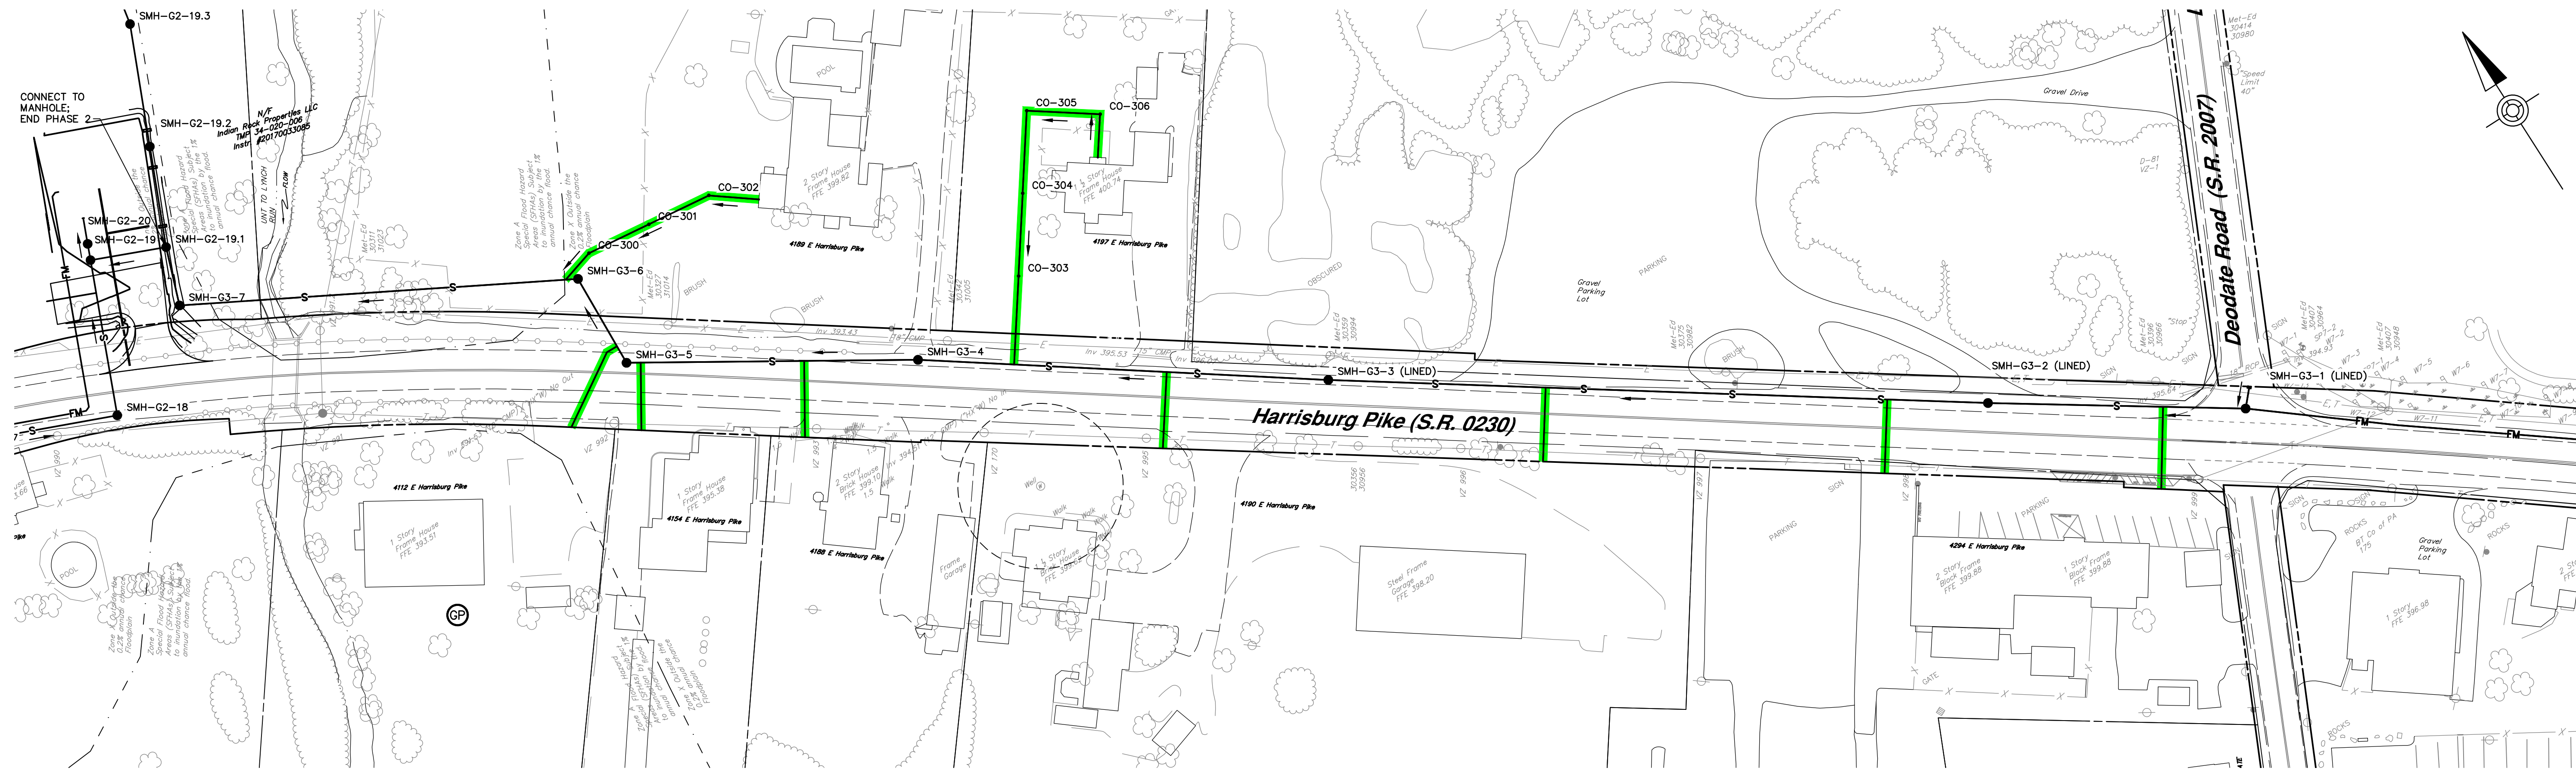

FOR CONTINUATION SEE SHEET FM3-1


**SANITARY SEWER PLAN**

SCALE: 1"=50'

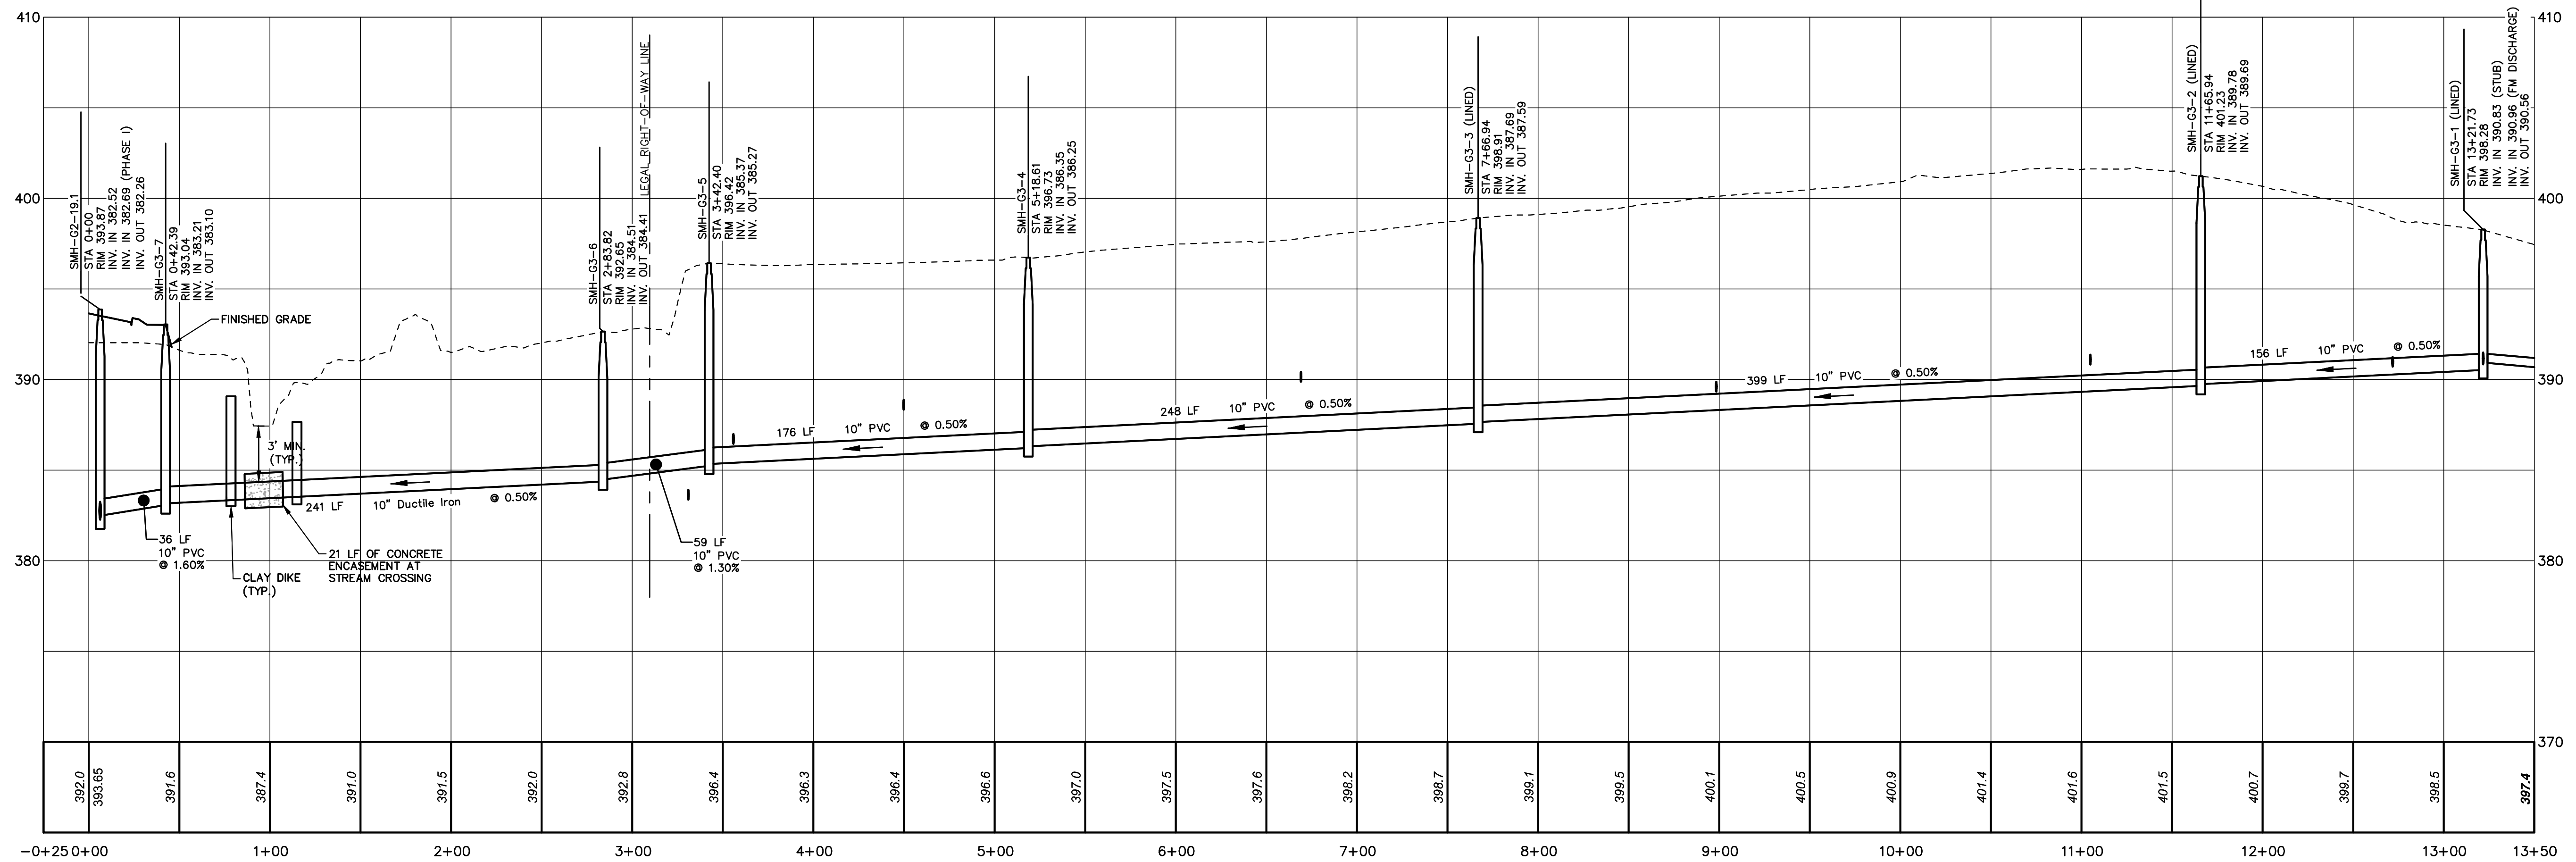


**PROFILE**

HORIZ. SCALE: 1"=50'  
VERT. SCALE: 1"=5'

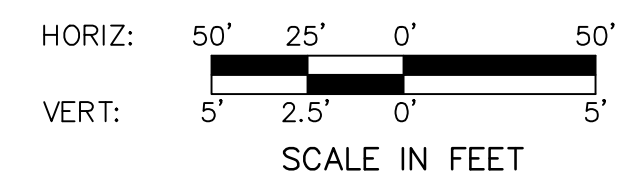

NO.	REVISION	DATE	BY

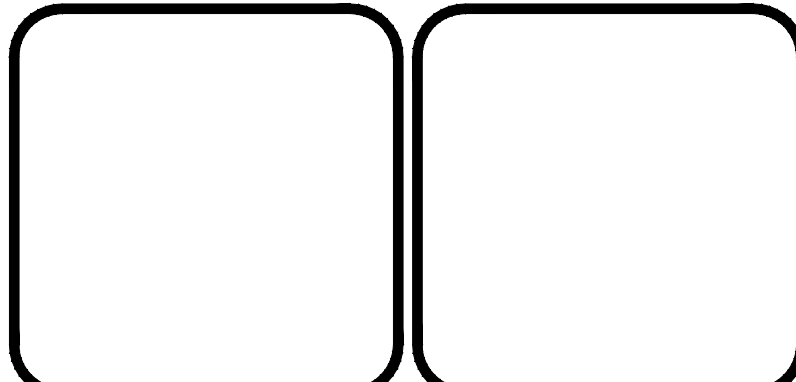

**HRG**  
Herbert, Rowland & Grubic, Inc.  
Engineering & Related Services  
AN EMPLOYEE-OWNED COMPANY

369 East Park Drive  
Harrisburg, PA 17111  
(717) 564-1121  
Fax (717) 564-1158  
hr@hr-g-inc.com  
www.hr-g-inc.com

VISION-ELIZABETHTOWN, LLC  
633 WEST GERMANTOWN PIKE, SUITE 104  
PLYMOUTH MEETING, PA 19462

(610) 940-9220

**SANITARY SEWER PLAN & PROFILE**  
**DEODATE PUMP STATION**  
**FOR LONDONDERRY SANITARY**  
**SEWER EXTENSION PHASE II**


LONDONDERRY TOWNSHIP DAUPHIN COUNTY PENNSYLVANIA

PROJ. MGR. - JTF
DESIGN - KWR
CADD - KRB
CHECKED - MDC
SCALE - AS NOTED
DATE - SEPT. 2020


DRAWING NO.  
**G3-1**

SHEET NO.  
**46 OF 125**


PROJECT 008284.0425

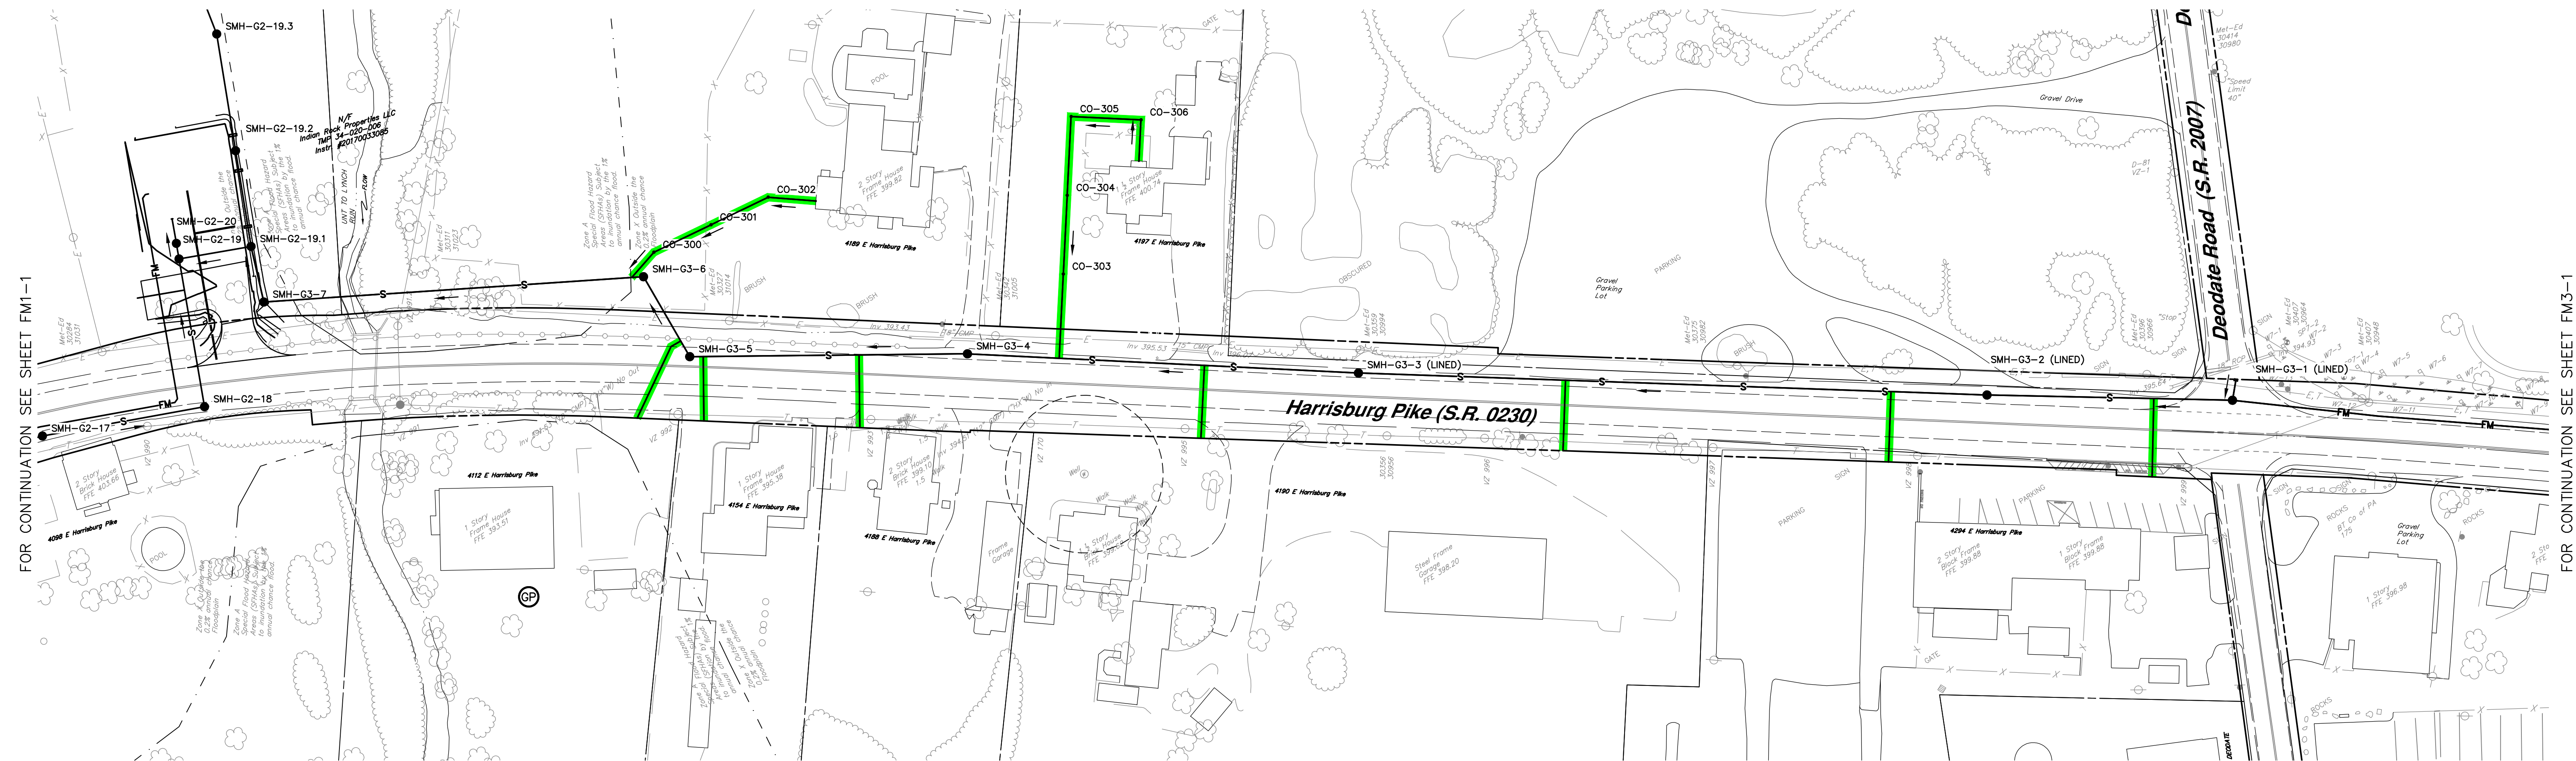


**SANITARY SEWER PLAN**  
SCALE: 1"=50'

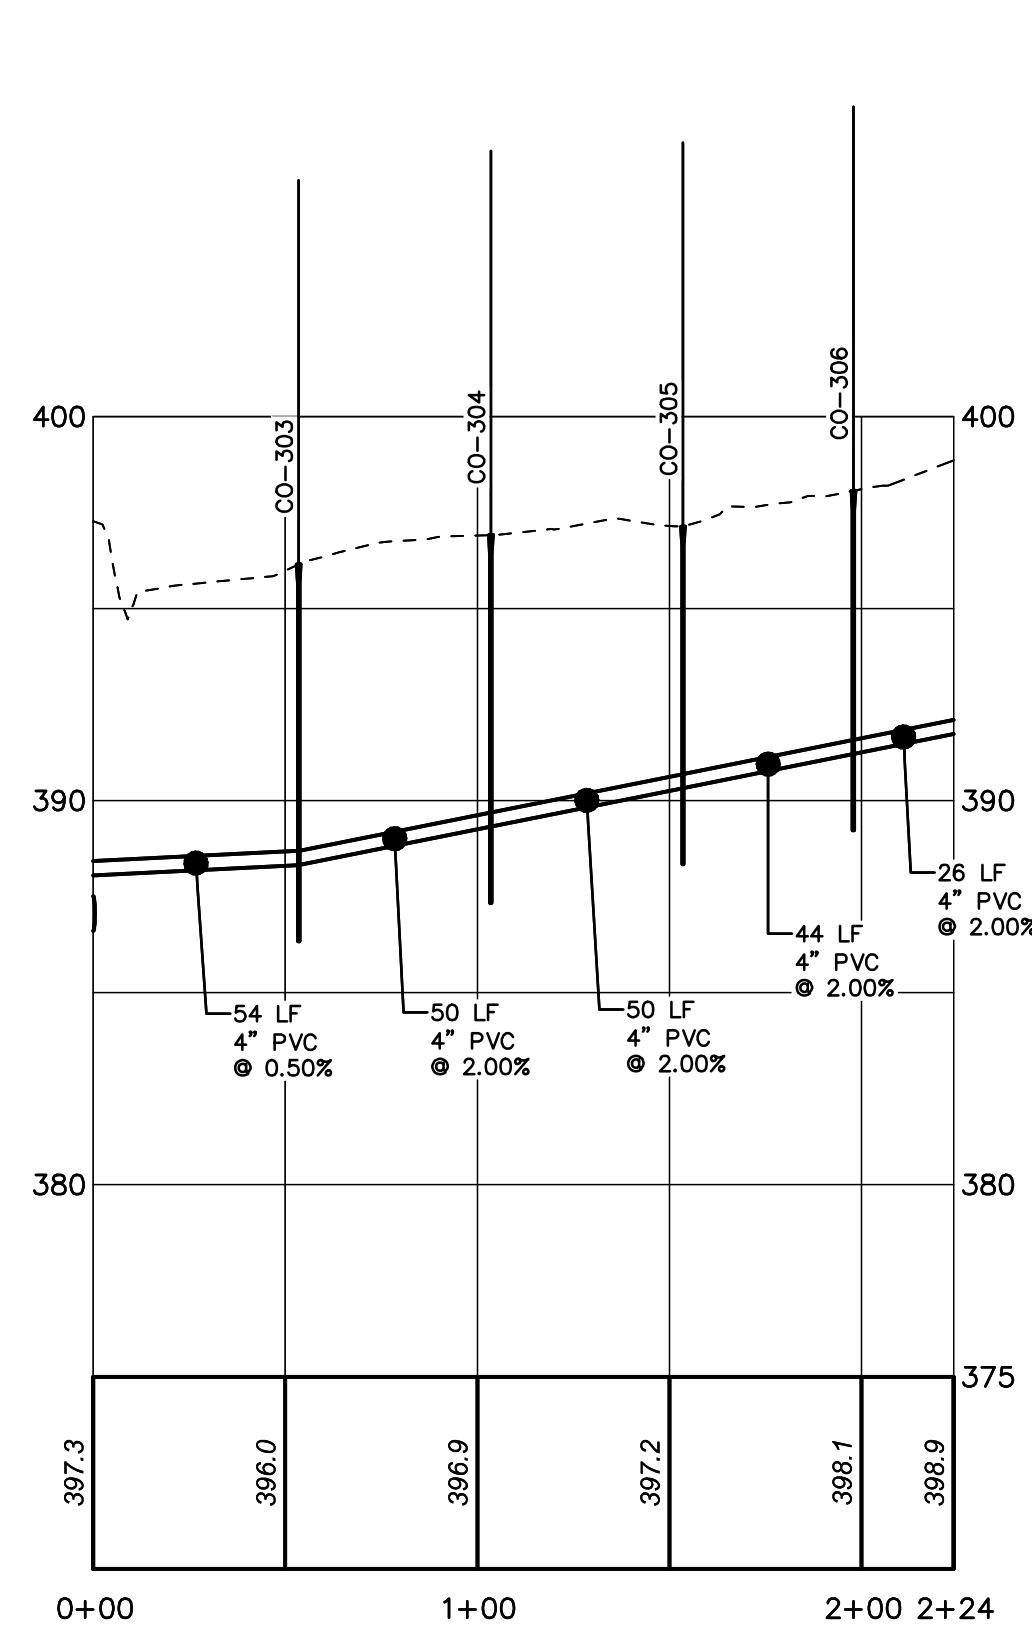



**PROFILE**  
HORIZ. SCALE: 1"=50'  
VERT. SCALE: 1"=5'

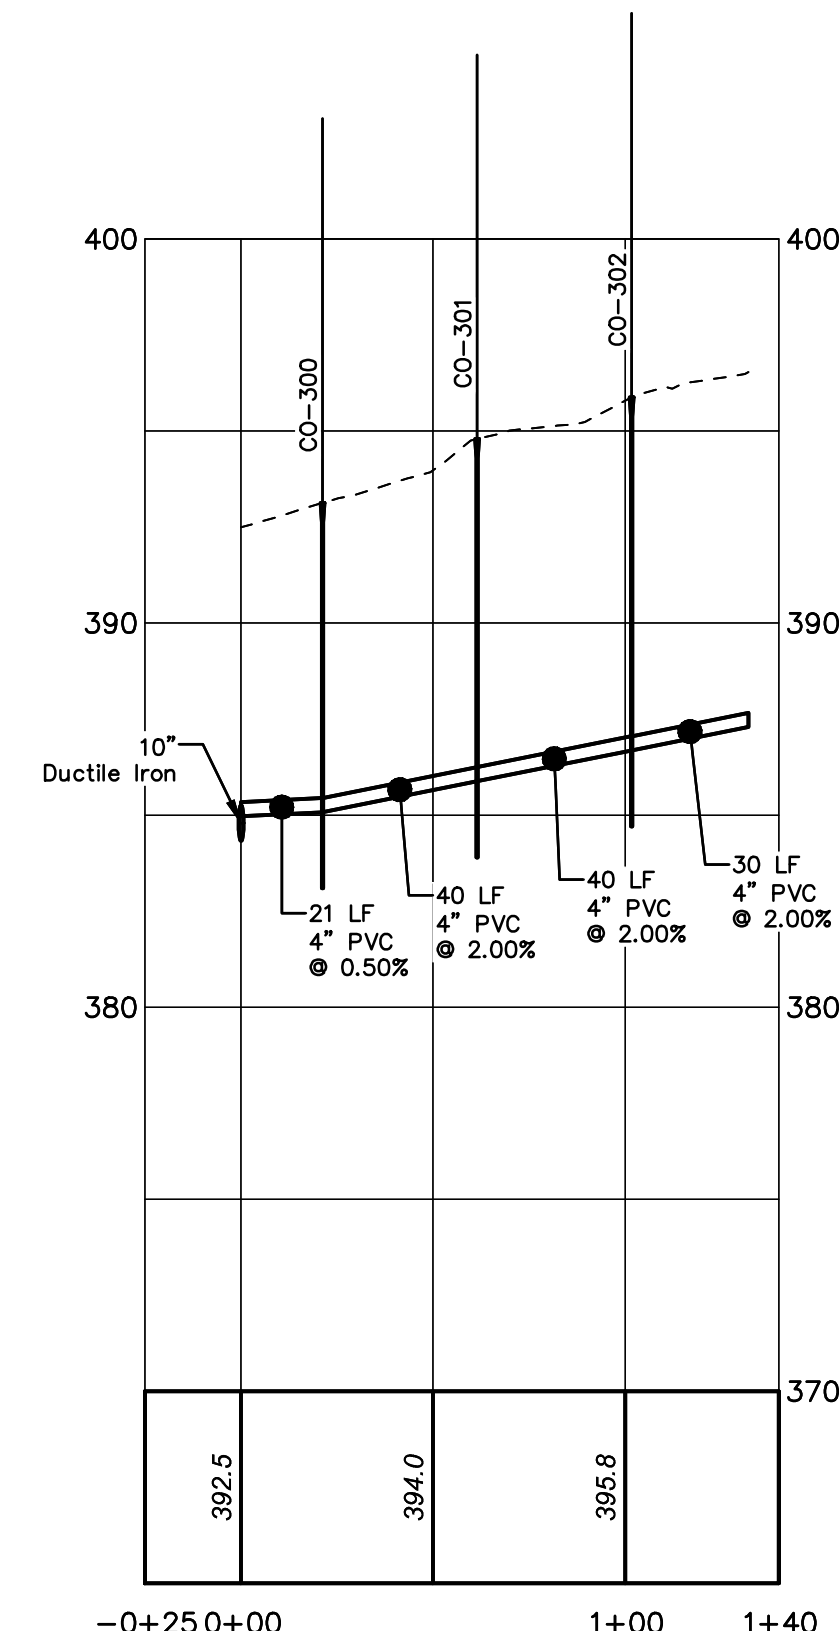

**PROFILE**  
HORIZ. SCALE: 1"=50'  
VERT. SCALE: 1"=5'

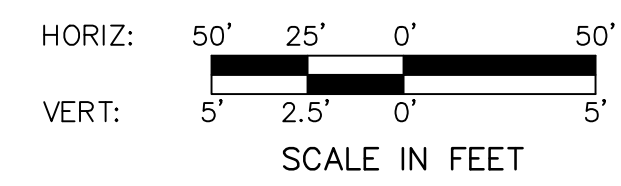

NO.	REVISION	DATE	BY

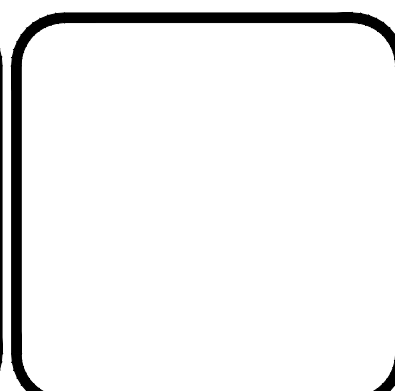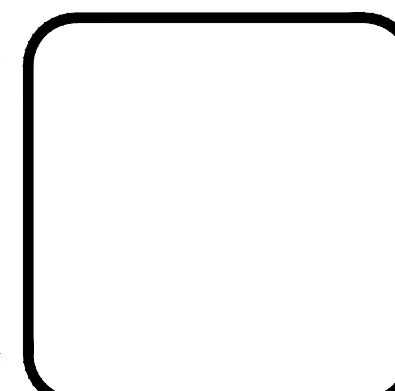

**HRG**  
Herbert, Rowland & Grubic, Inc.  
Engineering & Related Services  
AN EMPLOYEE-OWNED COMPANY

369 East Park Drive  
Harrisburg, PA 17111  
(717) 564-1121  
Fax (717) 564-1158  
hr@hr-g-inc.com  
www.hr-g-inc.com

VISION-ELIZABETHTOWN, LLC  
633 WEST GERMANTOWN PIKE, SUITE 104  
PLYMOUTH MEETING, PA 19462

(610) 940-9220


**SANITARY SEWER PLAN & PROFILE**  
LATERALS 4189 & 4197  
FOR LONDONDERRY SANITARY  
SEWER EXTENSION PHASE II

LONDONDERRY TOWNSHIP DAUPHIN COUNTY PENNSYLVANIA

PROJ. MGR. - JTF  
DESIGN - KWR  
CADD - KRB  
CHECKED - MDC  
SCALE - AS NOTED  
DATE - SEPT. 2020


DRAWING NO.  
**G3-2**  
SHEET NO.  
**47 OF 125**  
PROJECT 008284.0425

FOR CONTINUATION SEE SHEET FM3-5

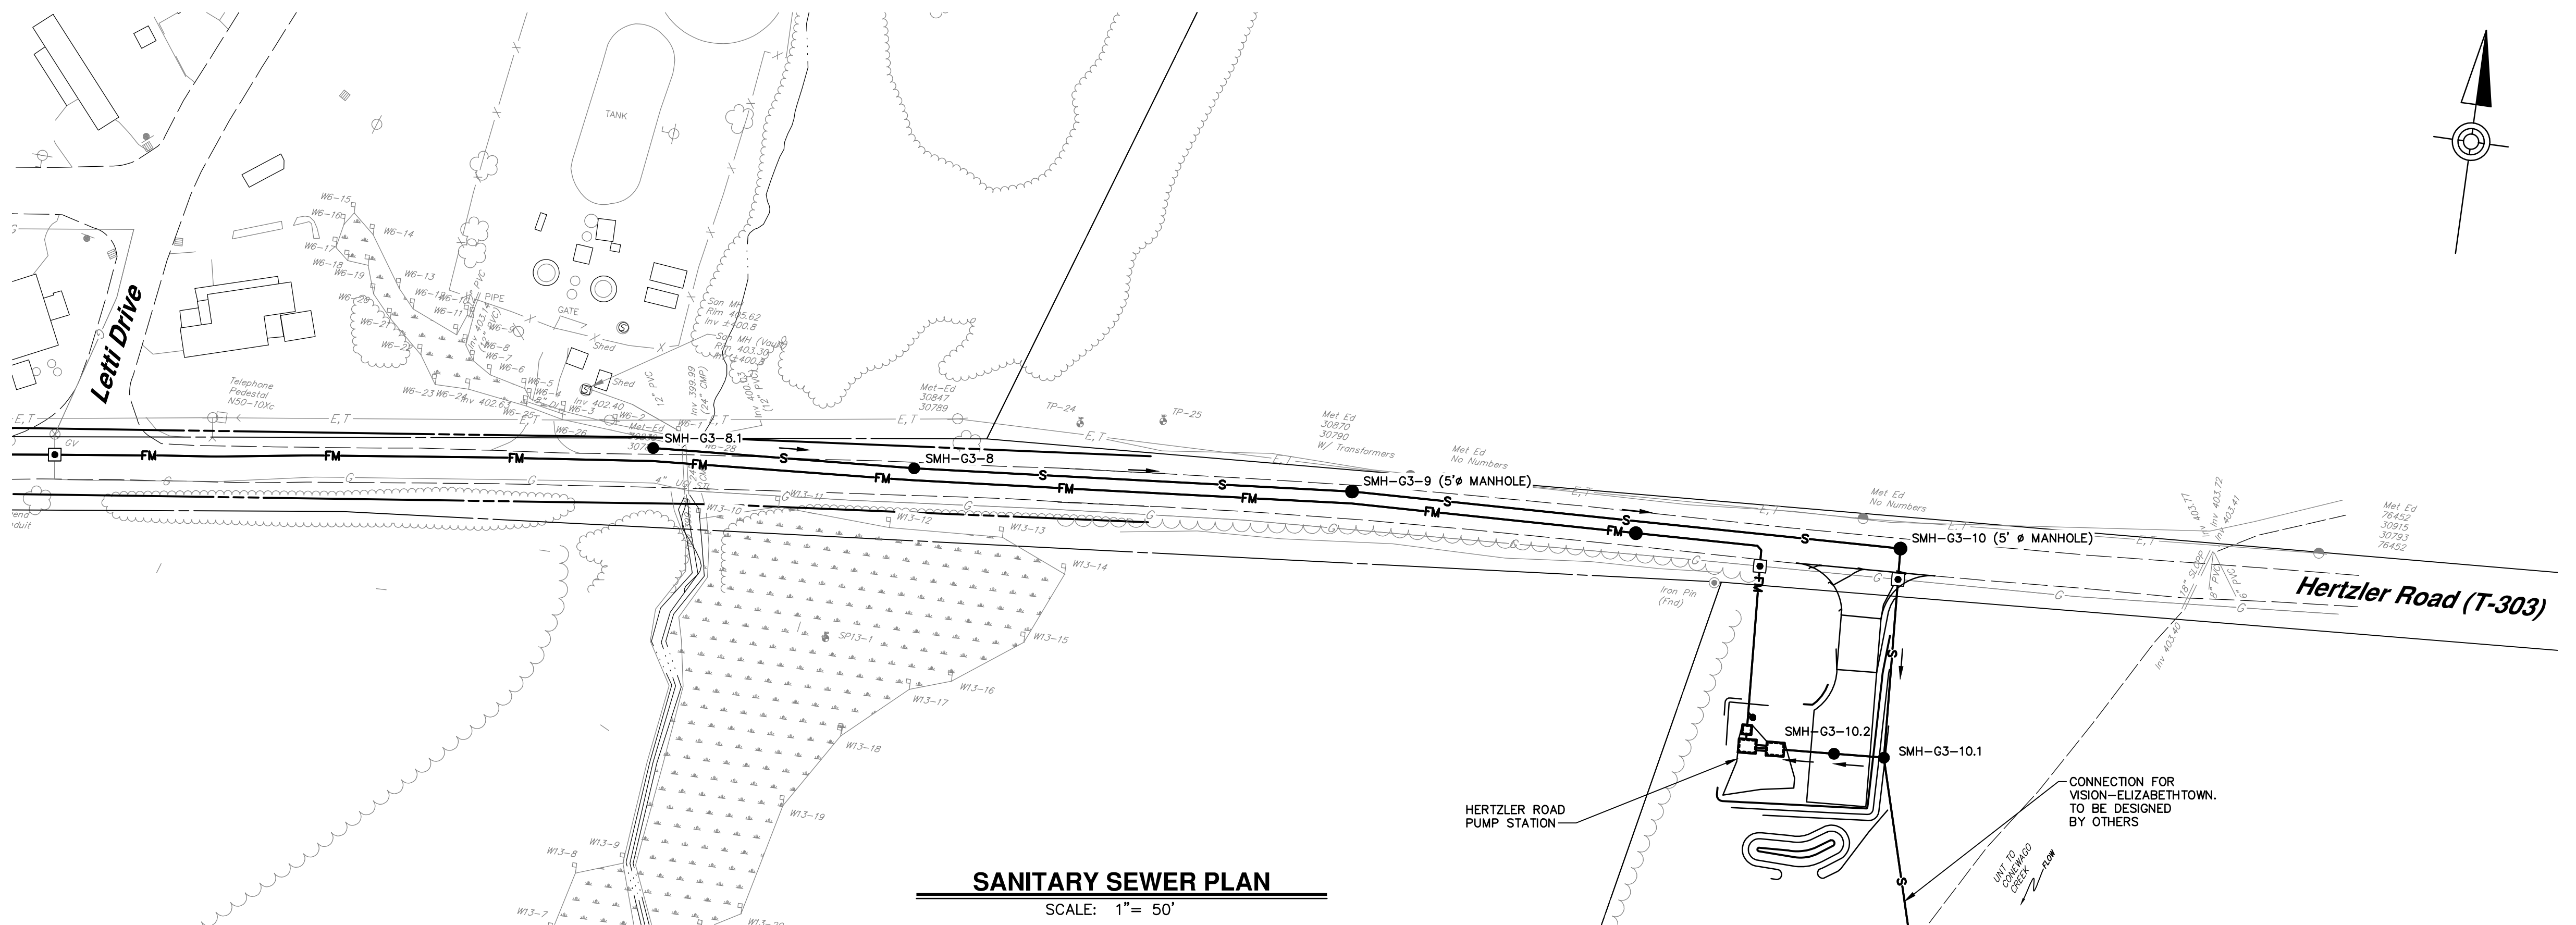


**SANITARY SEWER PLAN**

SCALE: 1" = 50'

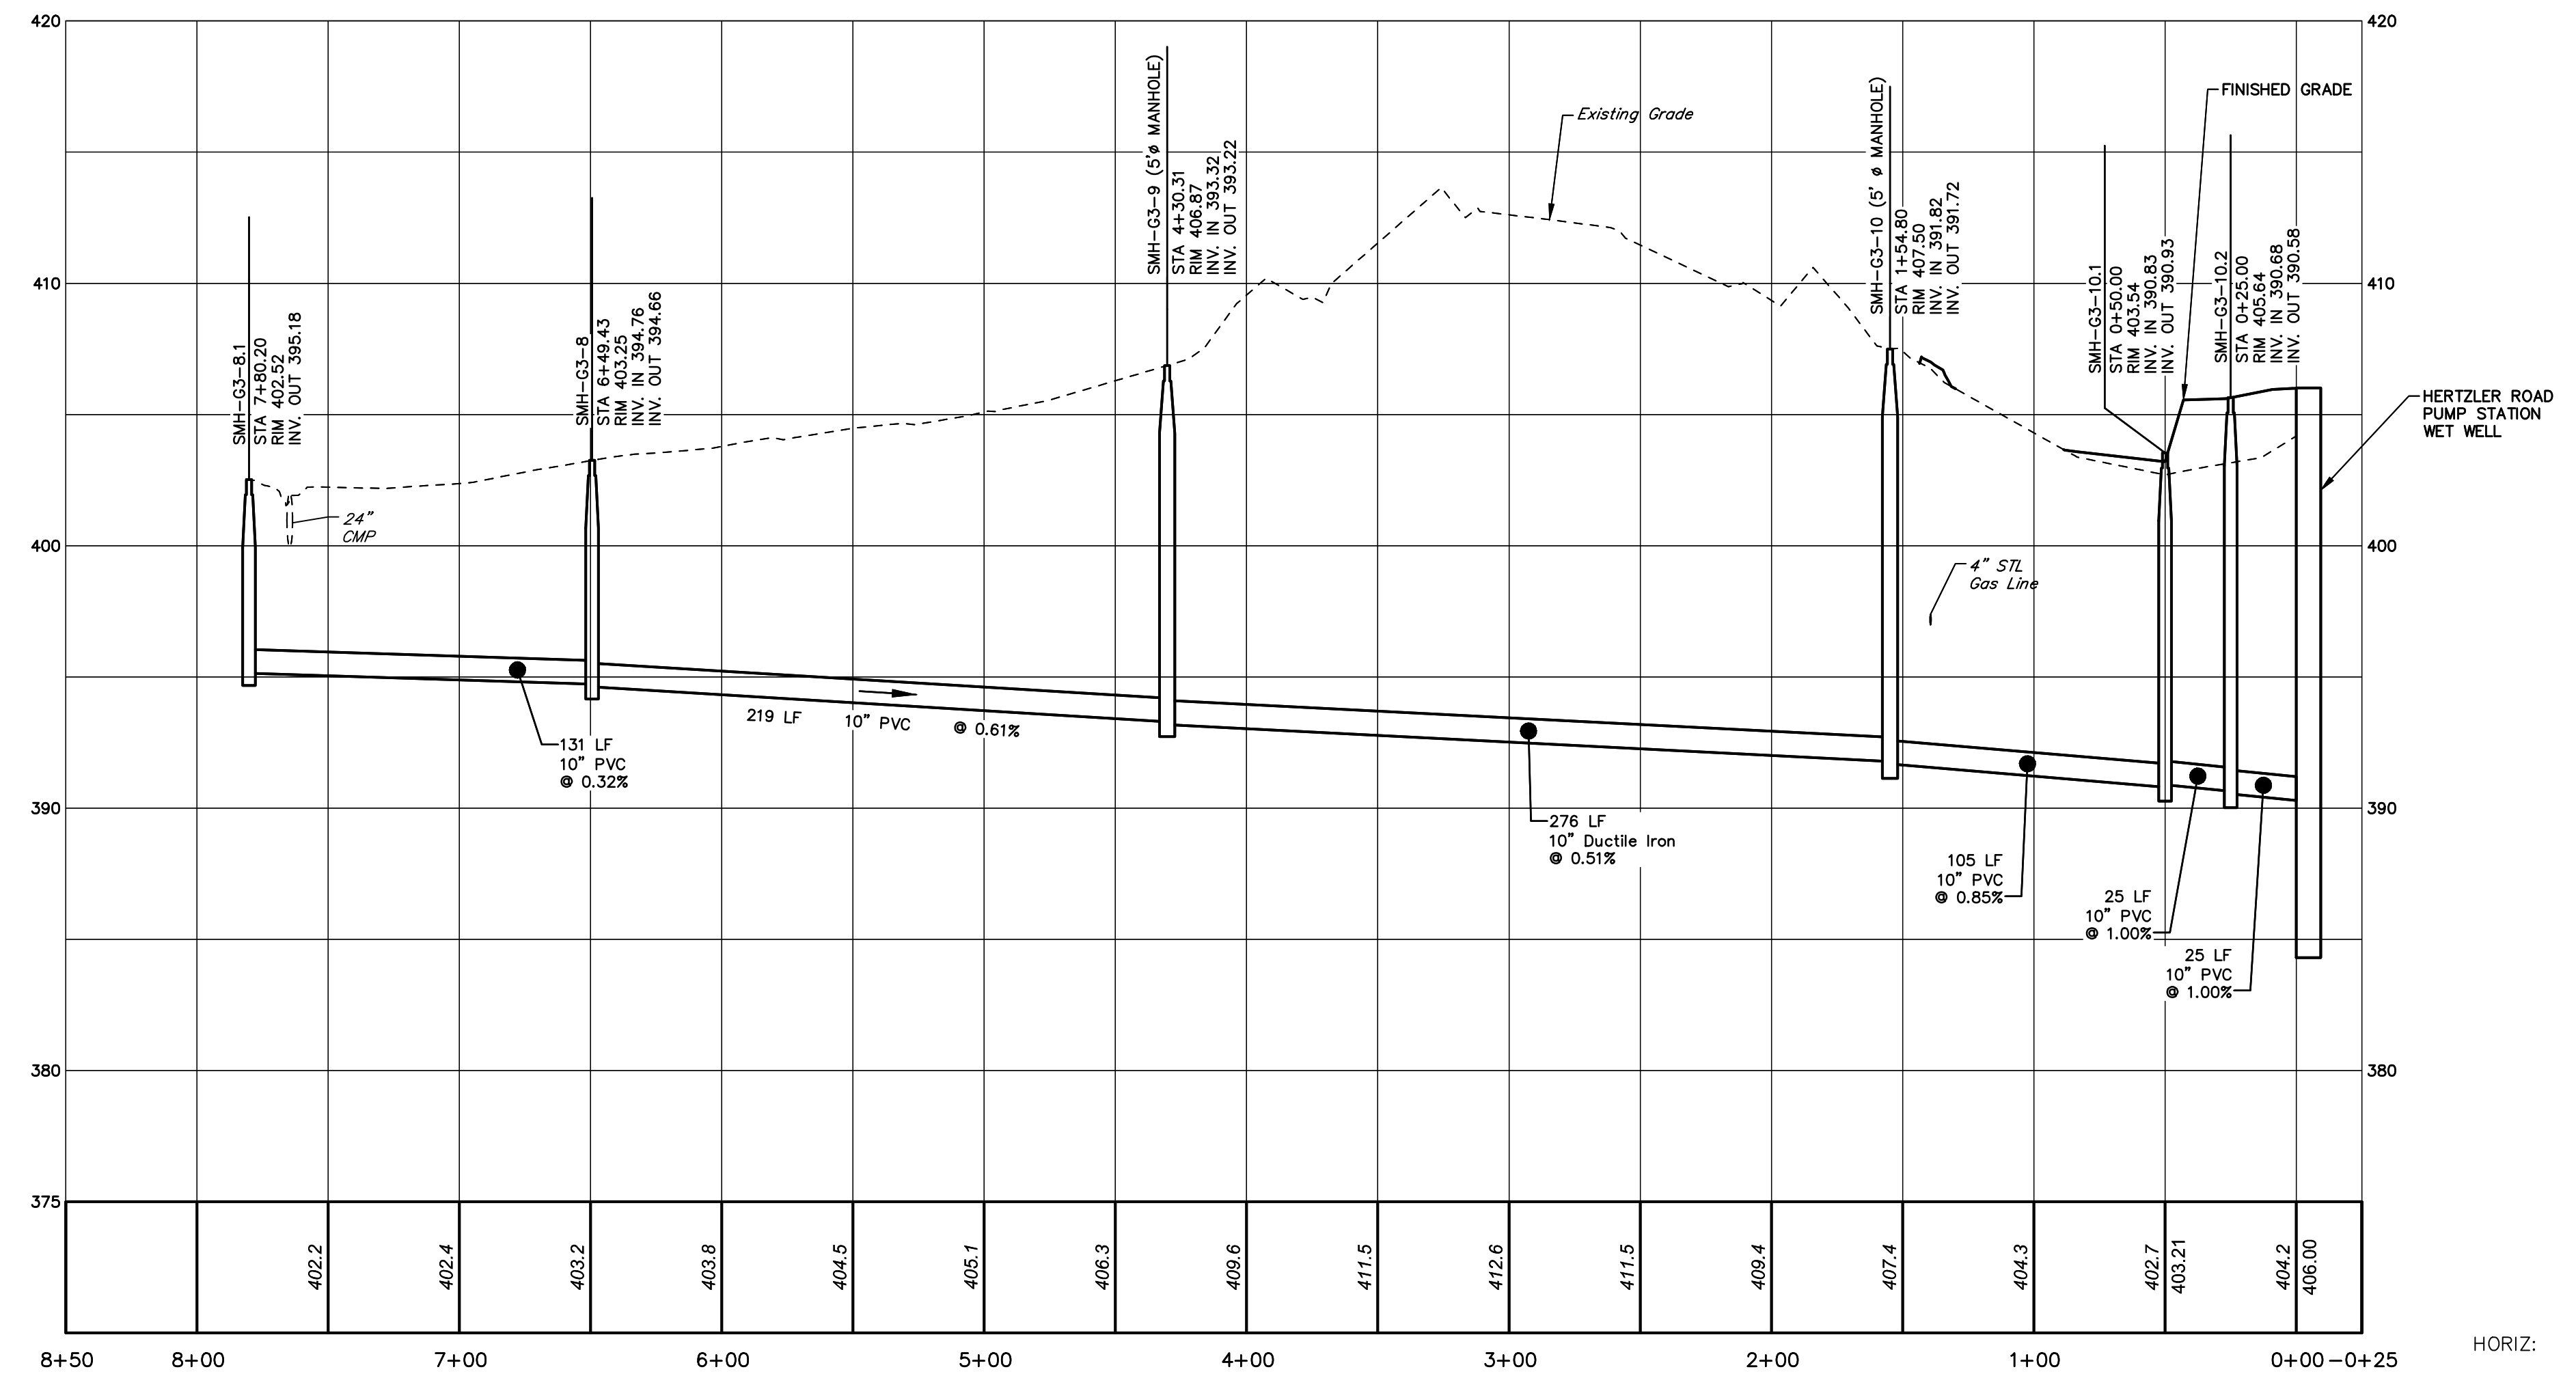

HORIZ: 50' 25' 0' 50'  
 VERT: 5' 2.5' 0' 5'  
 SCALE IN FEET

NO.	REVISION	DATE	BY

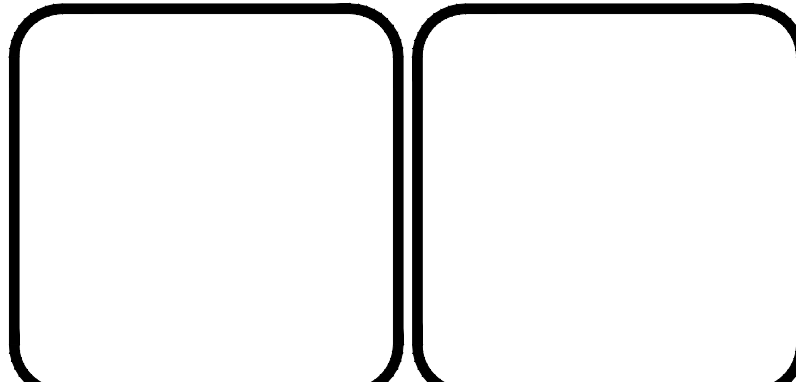

**HRG**  
 Herbert, Rowland & Grubic, Inc.  
 Engineering & Related Services  
 AN EMPLOYEE-OWNED COMPANY

369 East Park Drive  
 Harrisburg, PA 17111  
 (717) 564-1121  
 Fax (717) 564-1158  
 hr@hr-g-inc.com  
 www.hr-g-inc.com

VISION-ELIZABETHTOWN, LLC  
 633 WEST GERMANTOWN PIKE, SUITE 104  
 PLYMOUTH MEETING, PA 19462

(610) 940-9220

**SANITARY SEWER PLAN & PROFILE**  
**HERTZLER PUMP STATION**  
**FOR LONDONDERRY SANITARY**  
**SEWER EXTENSION PHASE II**

LONDONDERRY TOWNSHIP DAUPHIN COUNTY PENNSYLVANIA

PROJ. MGR. - JTF
DESIGN - KWR
CADD - KRB
CHECKED - MDC
SCALE - AS NOTED
DATE - SEPT. 2020

DRAWING NO.  
**G3-3**

SHEET NO.  
**48 OF 125**

PROJECT 008284.0425